



FRONT ELEVATION

SCALE 1:100

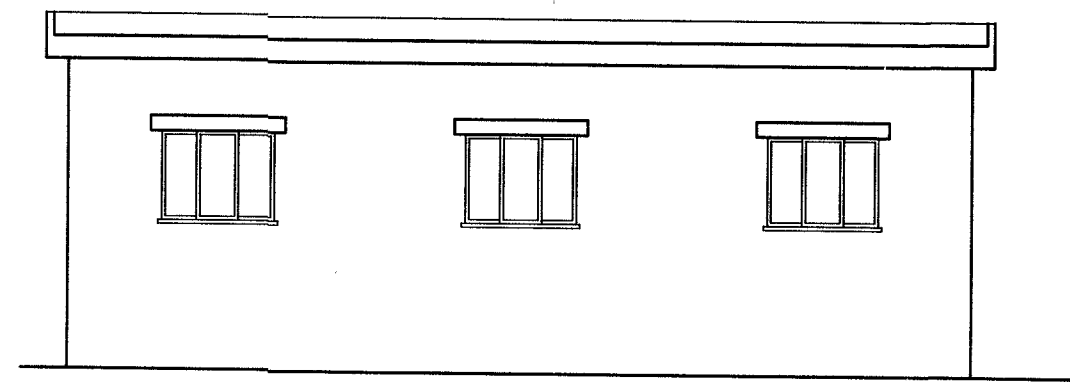


LEFT SIDE ELEVATION

SCALE 1:100

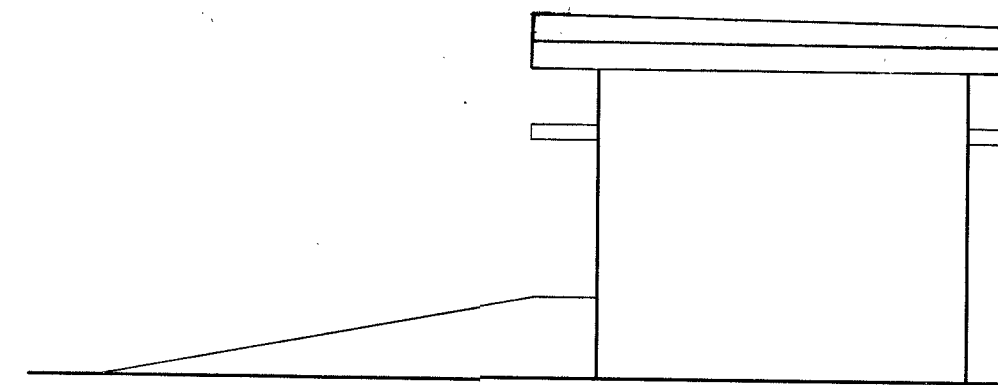


REAR ELEVATION

SCALE 1:100

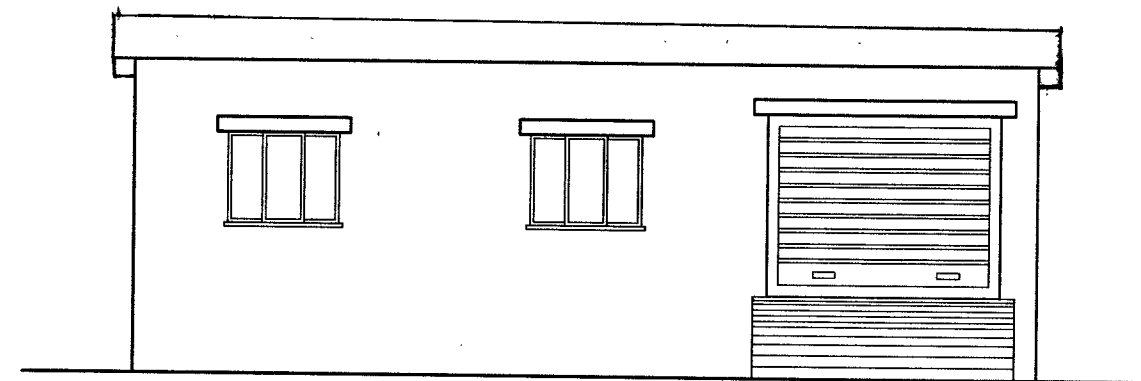


RIGHTSIDE ELEVATION

SCALE 1:100

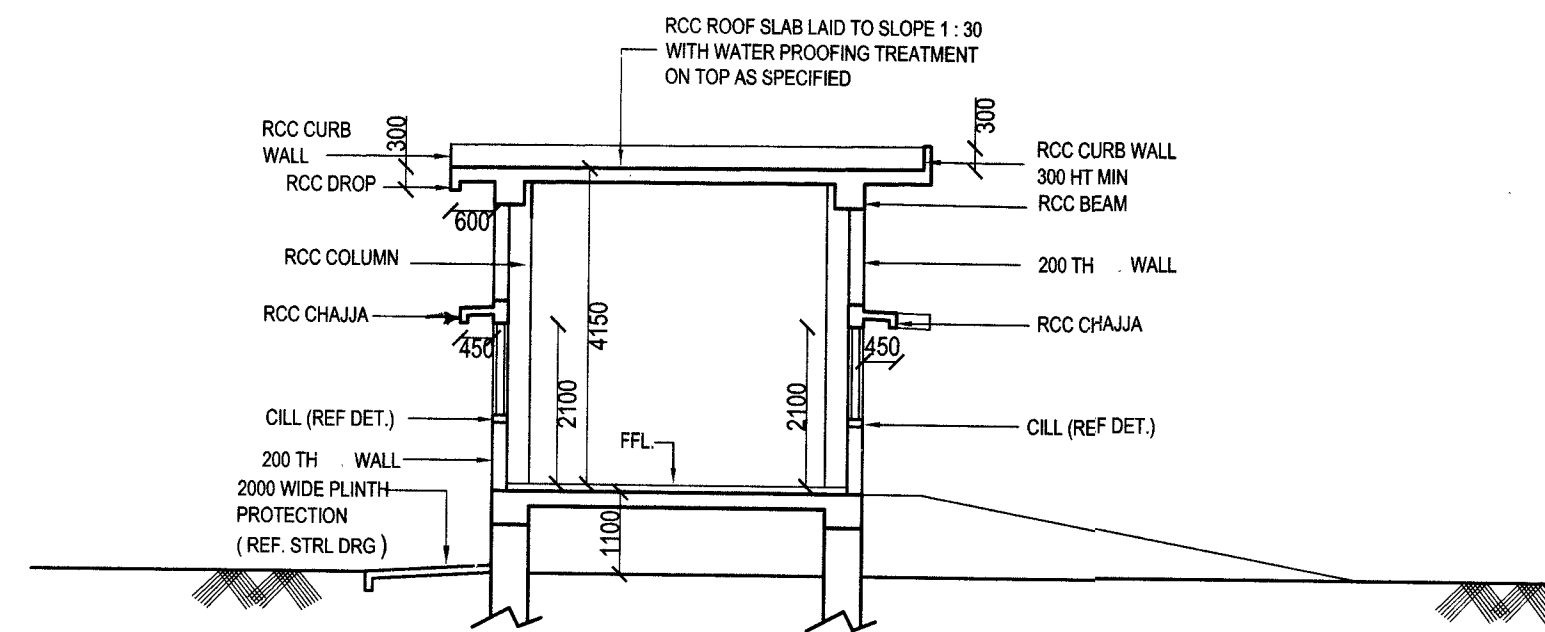


SECTION AT 'A-A'

SCALE 1:50

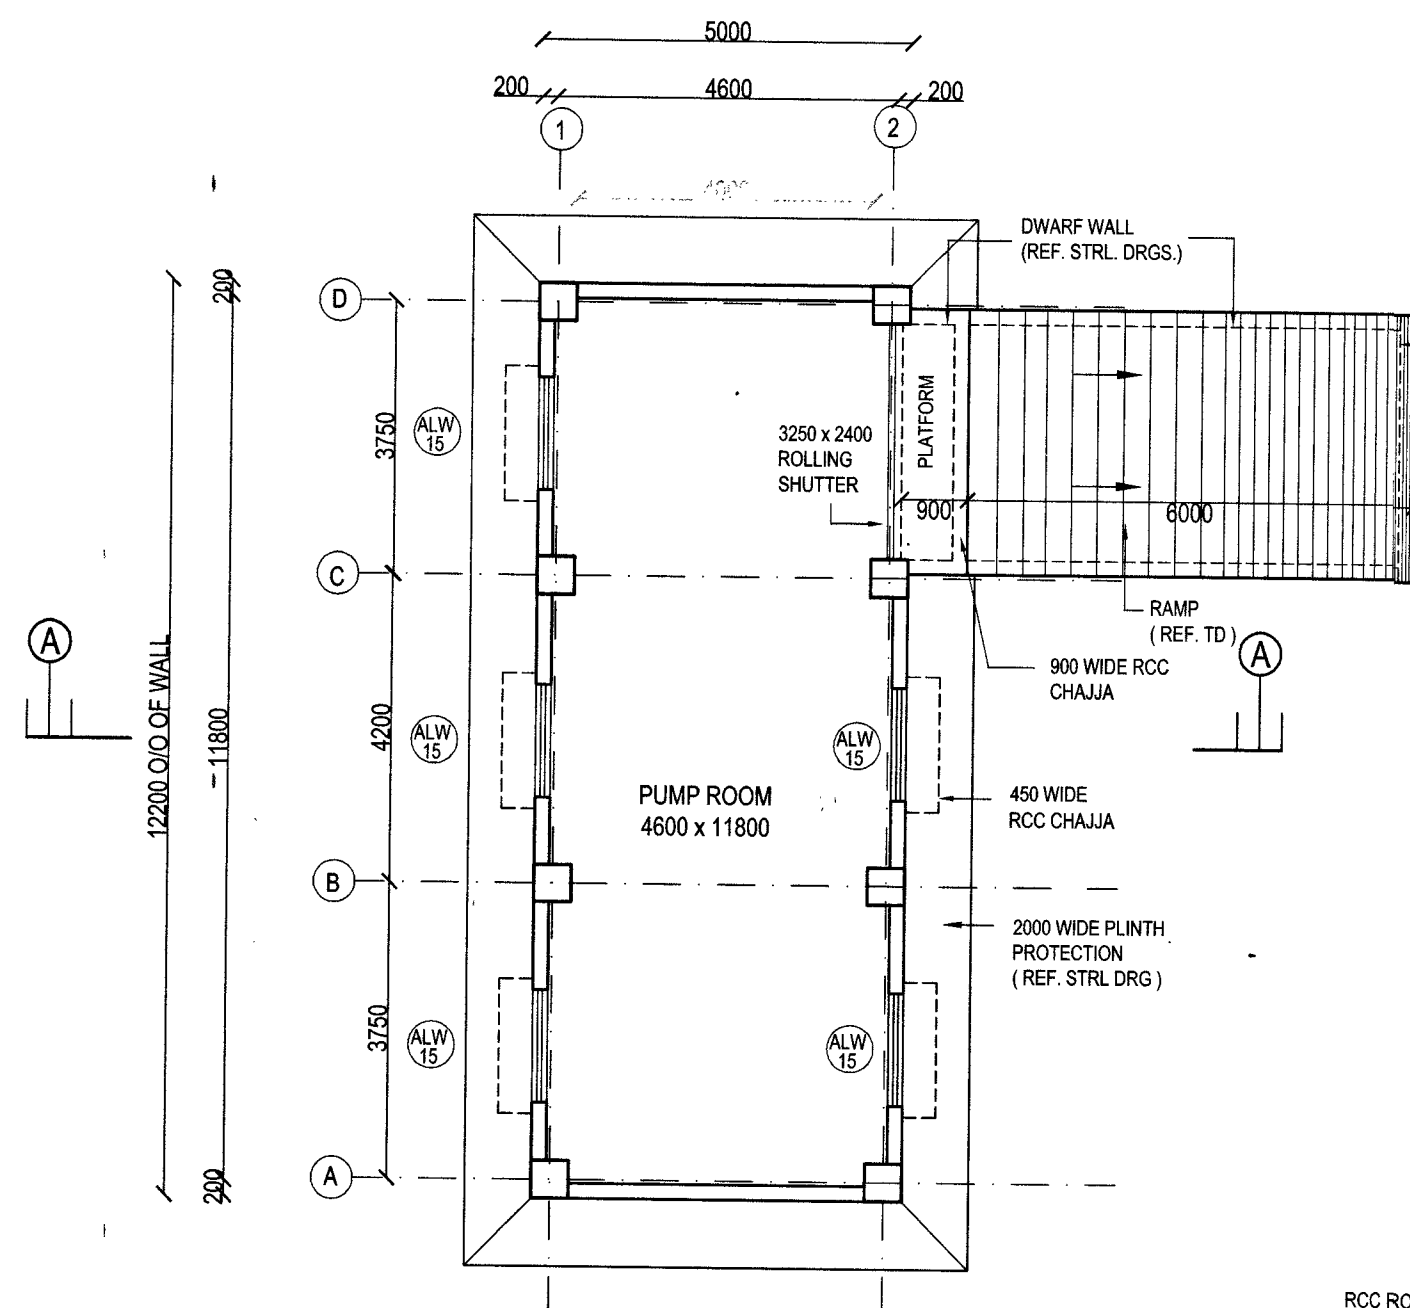


PLAN

SCALE 1:100

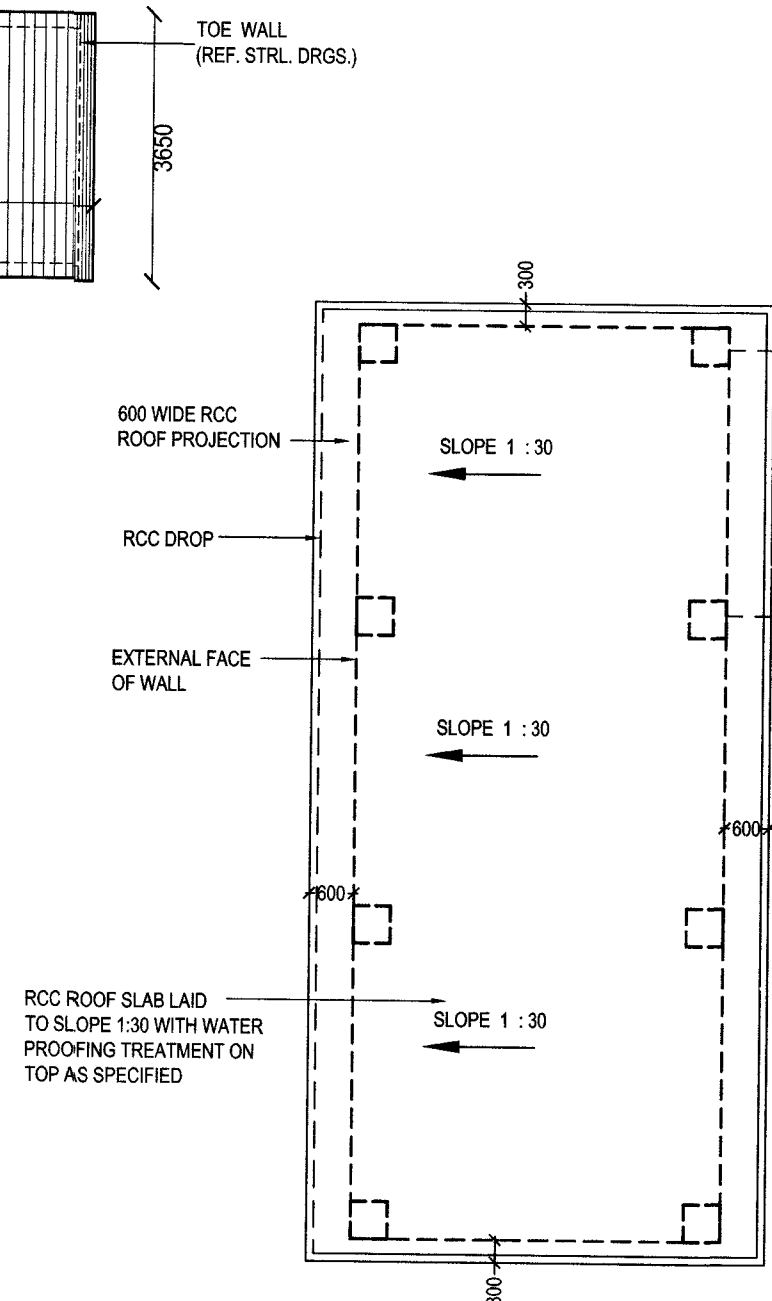

ROOF PLAN

SCALE 1:100

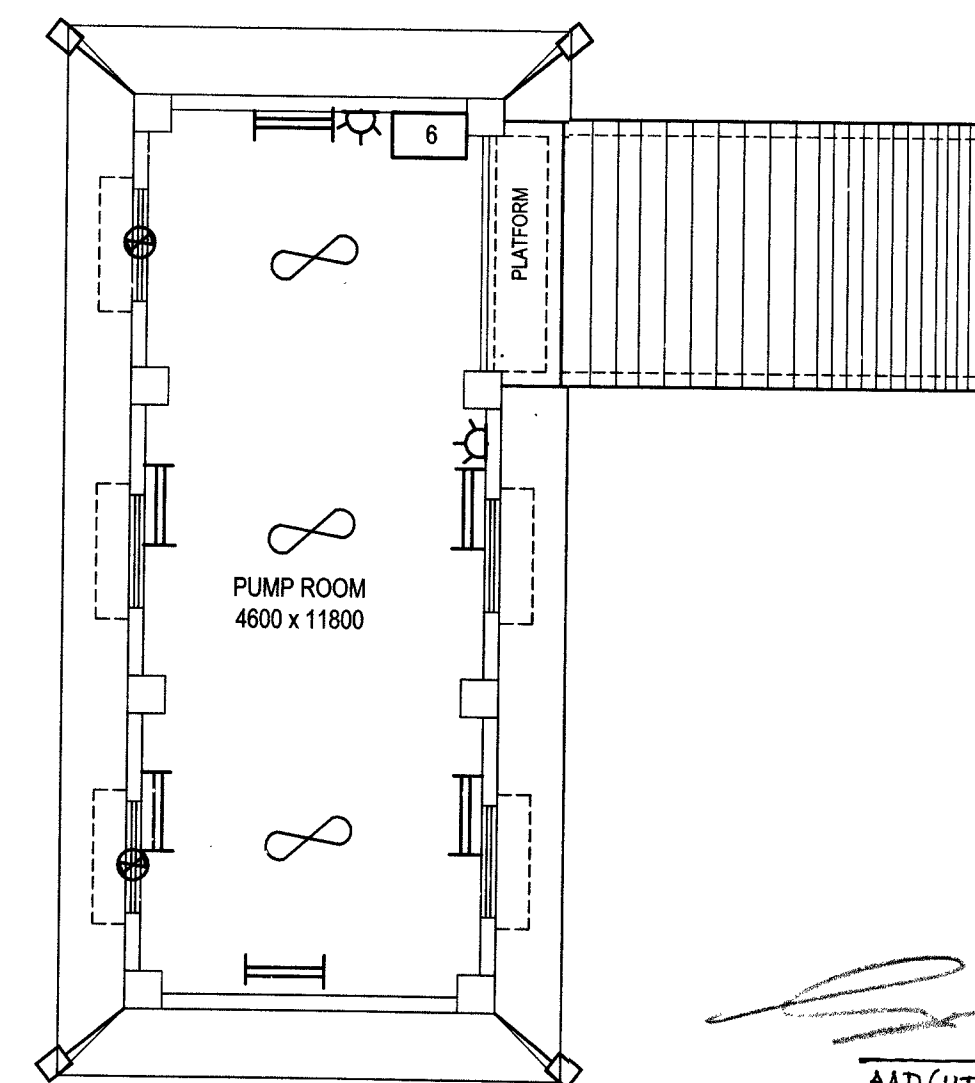

INTERNAL ELECTRIFICATION PLAN

SCALE 1:100

NOTES		
1	CONTRACTOR TO CHECK AND VERIFY ALL DIMENSIONS BEFORE EXECUTION OF THE WORK	
2	FIGURED DIMENSIONS SHALL BE FOLLOWED	
3	ALL DIMENSIONS ARE GIVEN IN MILLIMETERS UNLESS OTHERWISE SPECIFIED.	
4	FOR LIST OF DRGS REF DRG NO : CEVZ / 2022 /LD-2110 SHEET NO 1/1	
5	ALL DRAWINGS OF ARCHITECTURAL, STRUCTURAL, ELECTRICAL AND SANITARY PLUMBING ETC. FORMING PART OF THE CONTRACT SHALL BE READ IN CONNECTION WITH EACH OTHER.	
6	EXECUTIVE AUTHORITY SHALL CHEC THIS DRG. BEFORE TAKING EXECUTION IN HAND.	

LEGEND		
SL NO	DESCRIPTION	SHOWN THUS
1	CEILING FAN	
2	20 W LED TUBE LIGHT	
3	LED BUILDING SECURITY LIGHT	
4	5 AMP SWITCH SOCKET(SAME BOARD)	
5	SPN 6WAY DB	
6	EXHAUST FAN	

SL NO	DATE	DESCRIPTION	INITIAL
REVISIONS			
PROVISION OF DEFICIENT 287 SINGLE INLIVING ACCN ASSOCIATED FACILITIES FOR DSC AT NAVAL DOCKYARD, VISAKHAPATNAM (BD NO AMWP 46/2020)			
SUMP CUM PUMP HOUSE			
PLAN, ROOF PLAN, ELEVATIONSN SECTIONS AT 'A - A' AND INTERNAL ELECTRIFICATION PLAN			
DATE	11-06-2022	CHIEF ENGINEER (NAVY) VISAKHAPATNAM ZONE	SHEET NO 1 / 1
DRN	NB SUB VIJAY		
TCD	---		
CKD	---		
SCALE	1:100	REF DRG. NO. CEVZ / 2022 /WD - 2110 (S-PH)	
AAD (ARCH)		AAD (ARCH)	
JT DIR (ARCH)		DIR (ARCH) FOR CHIEF ENGINEER	