



MUMTY FLOOR PLAN


LEGEND		
SL NO	DESCRIPTION	SHOWN THUS
1	LED TUBE LIGHT FITTING 10W	
2	LED BUILDING SECURITY LIGHT 30W	

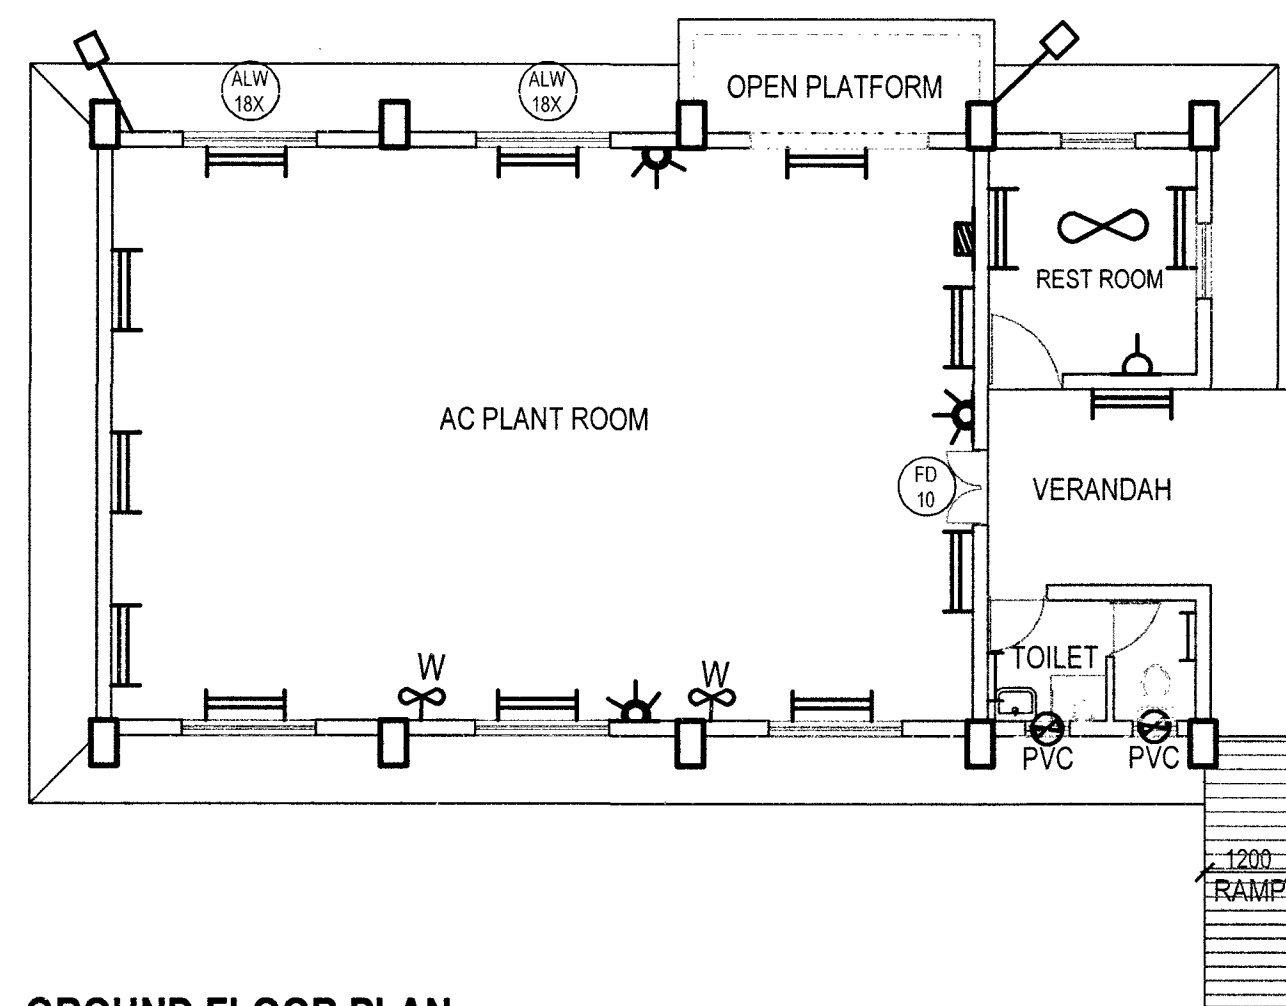


GROUND FLOOR PLAN

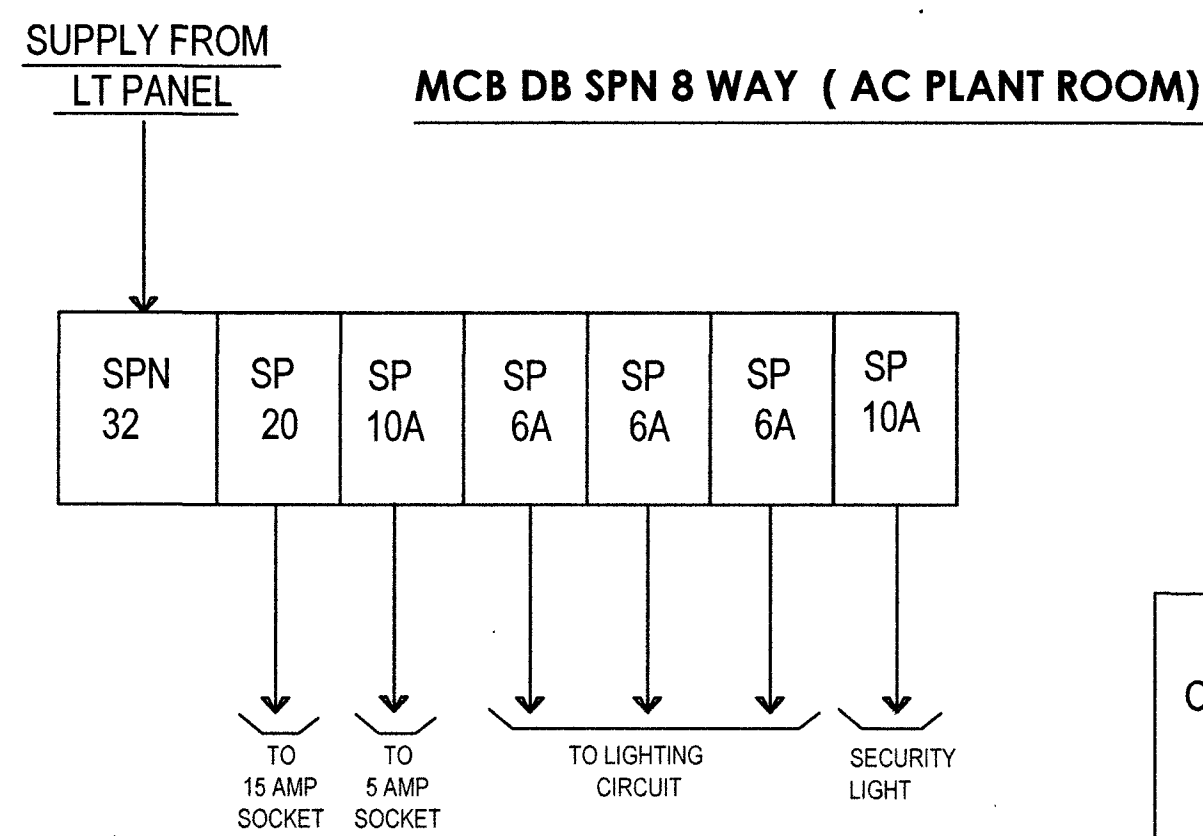

WATER SUPPLY FOR AC PLANT ROOM

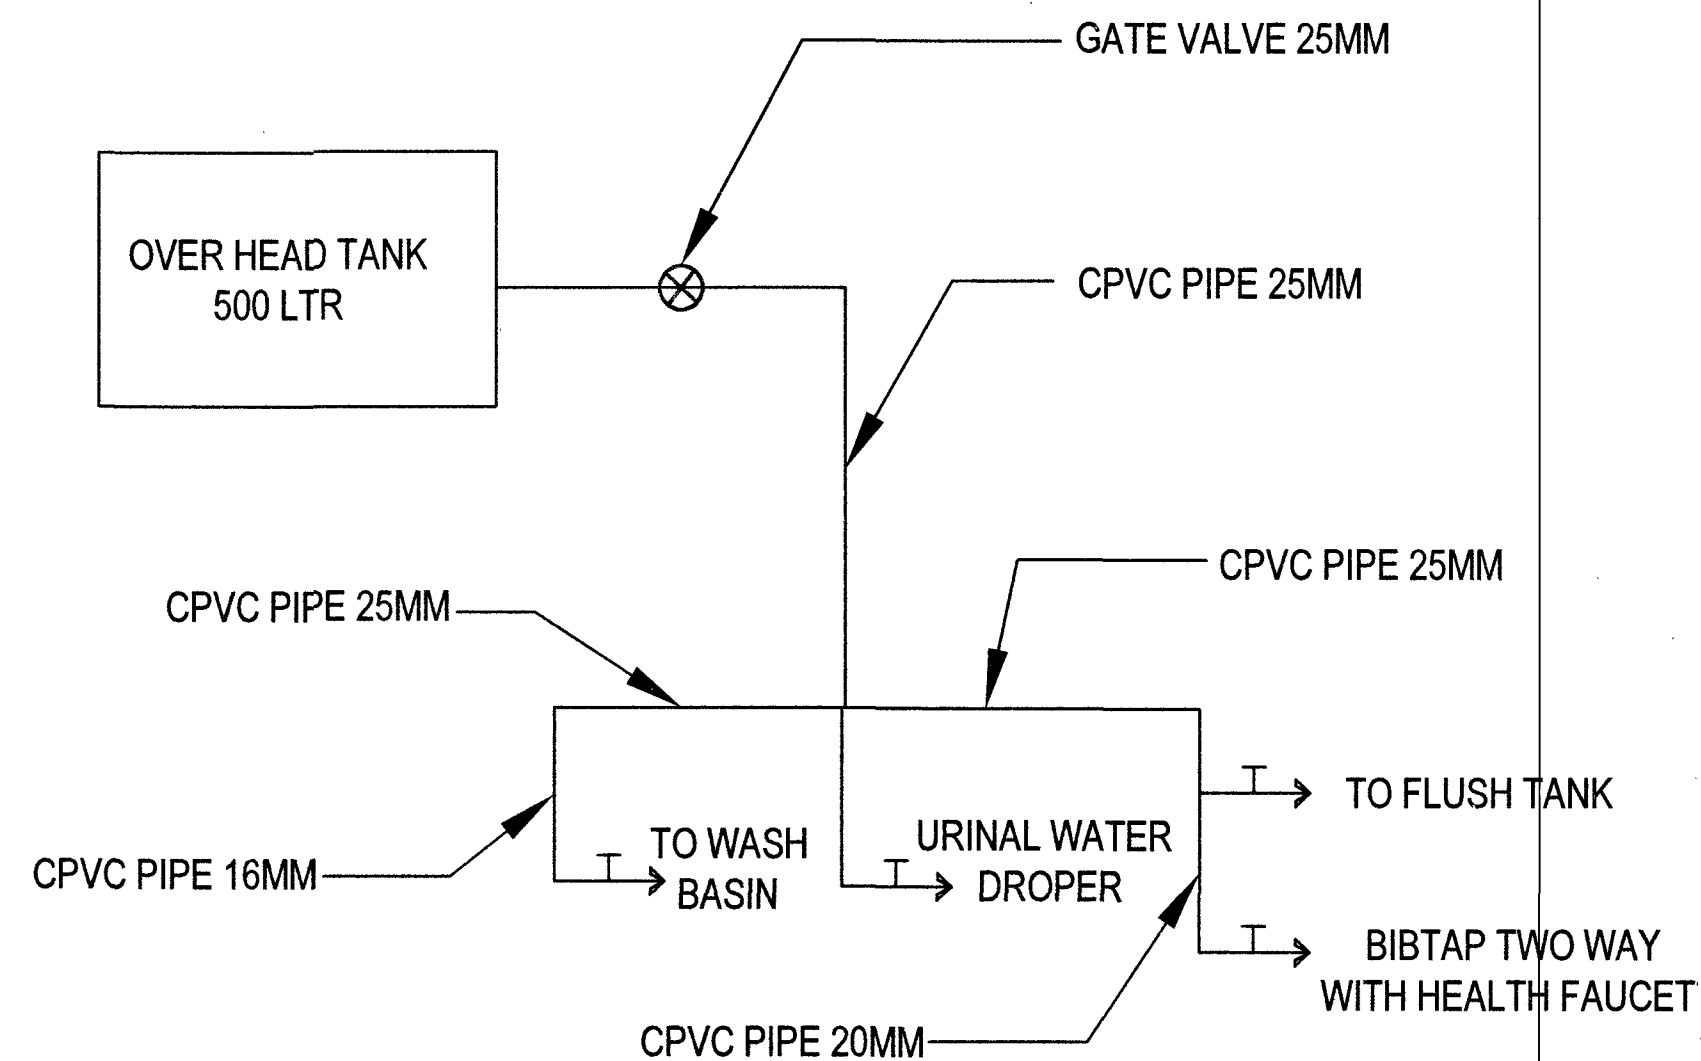

LEGEND		
SL NO	DESCRIPTION	SHOWN THUS
1	LED TUBE LIGHT FITTING 10W	
2	LED TUBE LIGHT FITTING 20W	
3	LED MIRROR LIGHT	
4	CEILING FAN	
5	EXHAUST FAN PVC BODY	
6	MCB DB SPN 8 WAY DOUBLE DOOR	
7	EXHAUST FAN METAL BODY 300MM	
8	MCB DB SPN 4 WAY DOUBLE DOOR	
9	5 AMP. SOCKET	
10	15 AMP. SOCKET	
11	LED BUILDING SECURITY LIGHT	

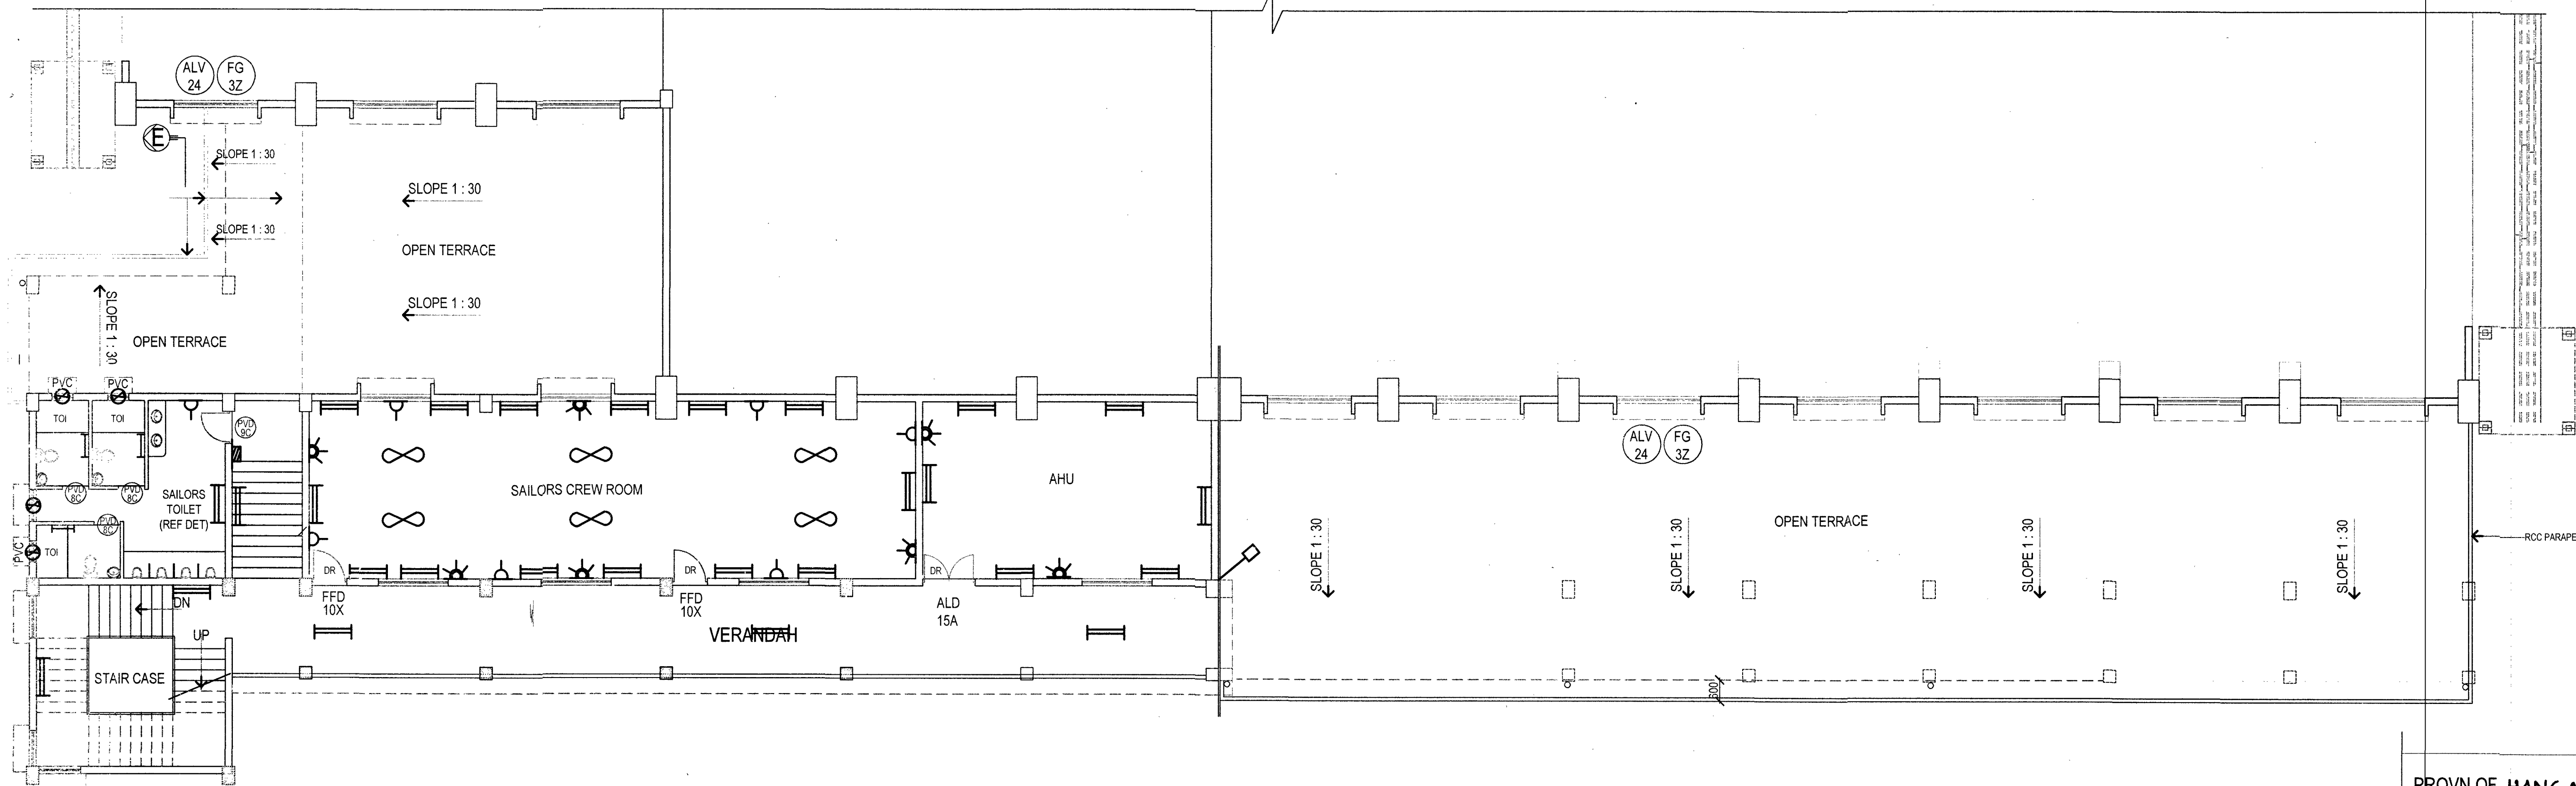

FIRST FLOOR PLAN

PROVN OF HANGAR AND ANNEXE BUILDING
AT INS DEGA VISAKHAPATNAM

INTERNAL ELECTRIFICATION PLAN OF FIRST FLOOR AND
AC PLANT ROOM

DATE	10-02-2023	CHIEF ENGINEER (NAVY) VISAKHAPATNAM ZONE	SHEET NO 11/13
DRN	NK PAVAN		
TCD	---		
CKD	---		
SCALE	1:100	REF DRG. NO. CEVZ/2022/WD-2120	

AAD(UTILITY)

ORIG. DRG. (UTILITY)
FOR CHIEF ENGINEER