




## SOAK PIT

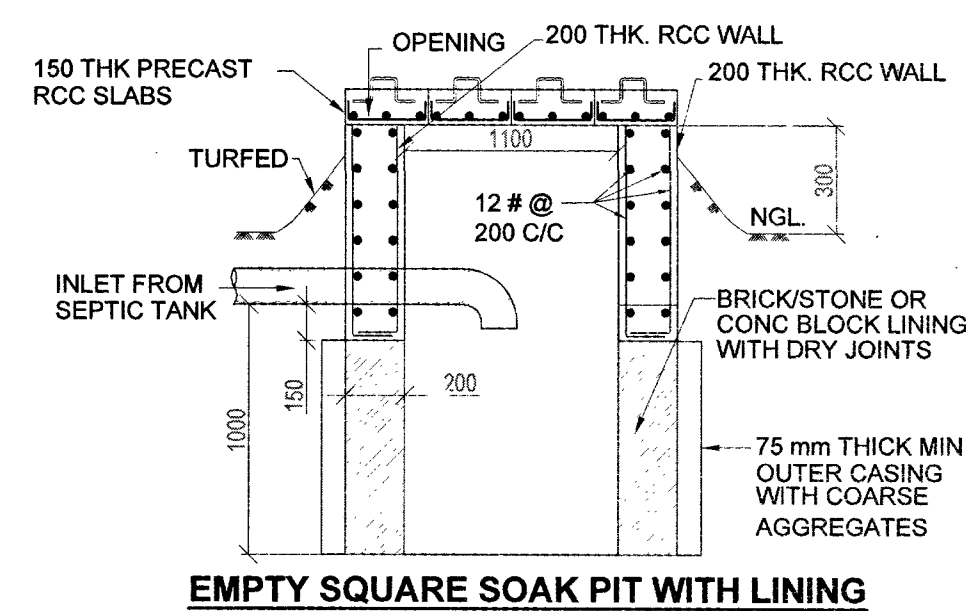


### EMPTY SQUARE SOAK PIT WITH LINING

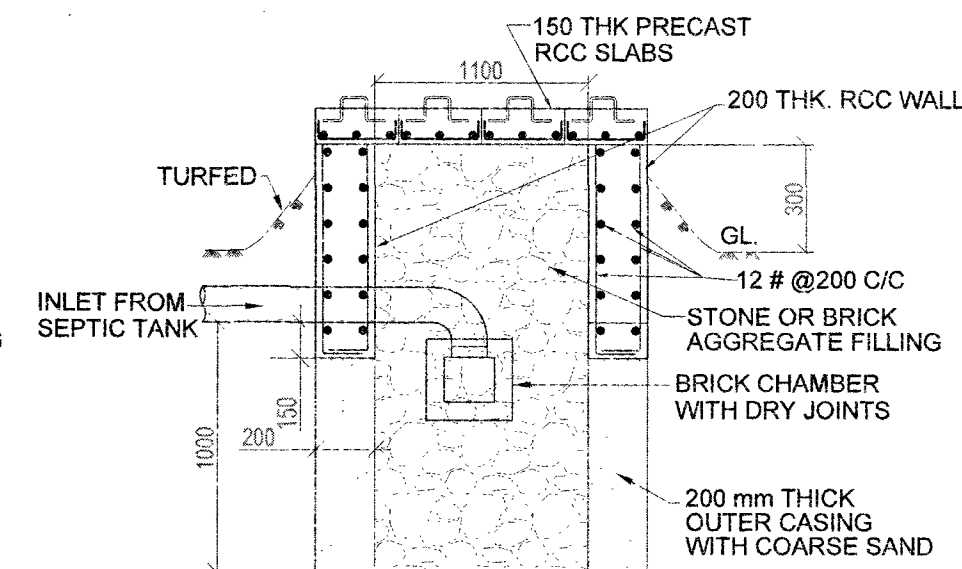


**SQUARE PIT WITH FILLING WITHOUT LINING**  
**TYPICAL ILLUSTRATIONS OF SEEPAGE PITS**

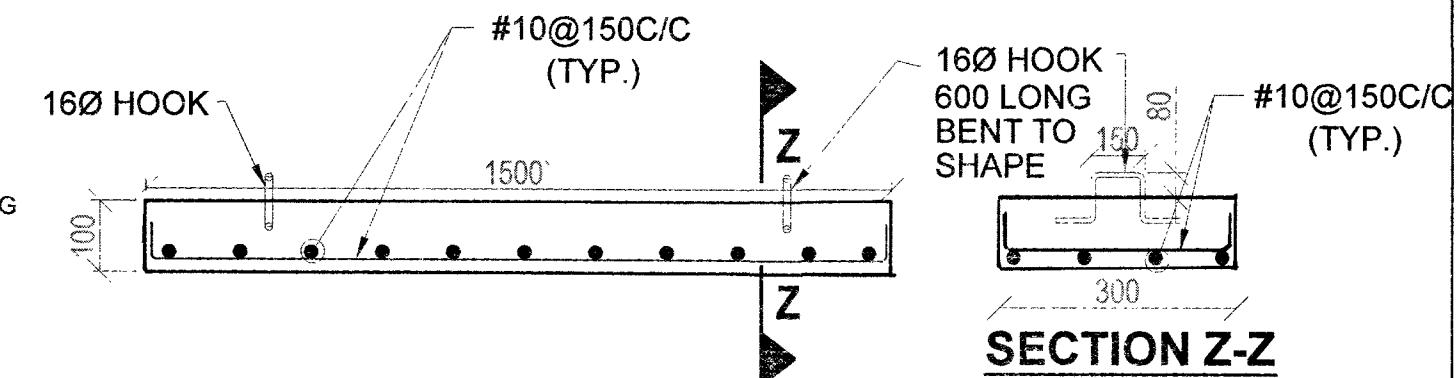


### REINFORCEMENT DETAIL OF PRECAST RCC SLAB

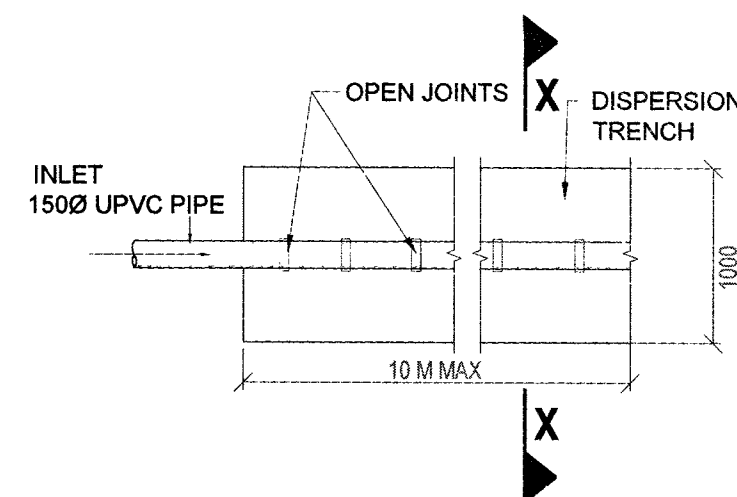

## PLAN OF DISPERSION TRENCHES

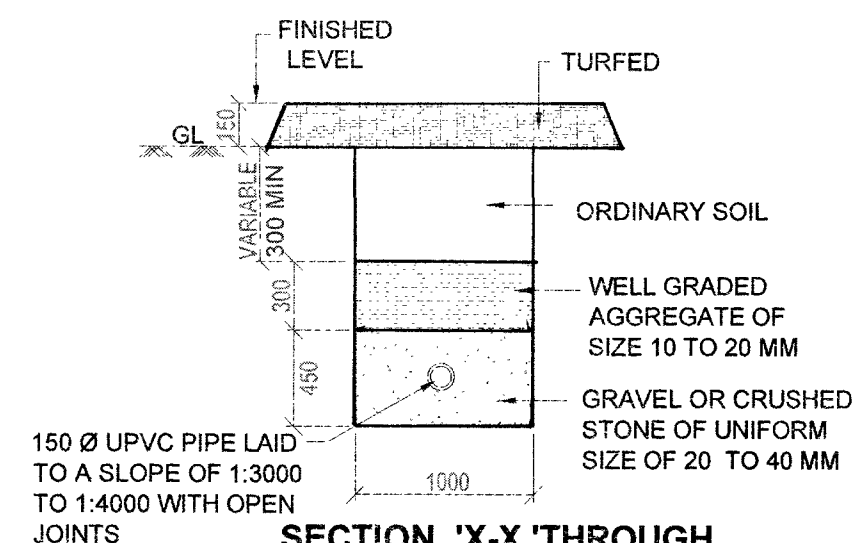

SECTION 'X-X' THROUGH  
DISPERSION TRENCH

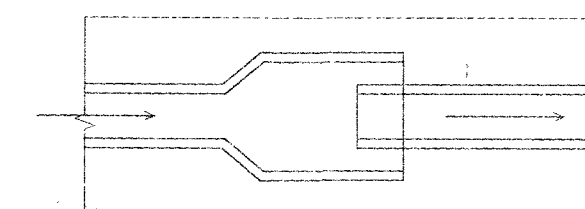

### DETAIL OF OPEN JOINT

## NOTES

1. FOR RCC NOTES REF DRG. NO. TD-389(S)  
SHEET NO 1/3.

DATE	DESCRIPTION	SIGN
	REVISIONS	

## SECONDARY TREATMENT


### SOAK PIT & DISPERSION TRENCH

SHT NO.	S-03	<b>HELIOS ENGINEERING CONSULTANTS</b> #38-34-66 FCI COLONY MARRIPALEM VISAKHAPATNAM - 530018
SCALE	AS NOTED	
DRN BY.	VIJAY	
DATE.	24-09-2019	

DESIGNED BY

ED BY

CHECKED BY


 CHECKED BY

**CHIEF ENGINEER  
(NAVY)  
VISAKHAPATNAM**

REF.DRG.NO: TD-389(S)

**Sht.No. 3/3**

M VENU GOPAL  
AECIV)  
AAD (DESIGN)

(PK SINGH, IDSE)  
SE  
DIRECTOR (DESIGN)  
FOR CHIEF ENGINEER