


THIS DESIGN AND DRAWING IS THE PROPERTY OF THE NUCLEAR POWER CORPORATION LIMITED AND SHALL NOT BE REPRODUCED OR COPIED IN ANY MANNER WITHOUT THE WRITTEN PERMISSION OF THE OWNER.

DRG. No. NPCL-KAGA-WD-ELV-DSP-120

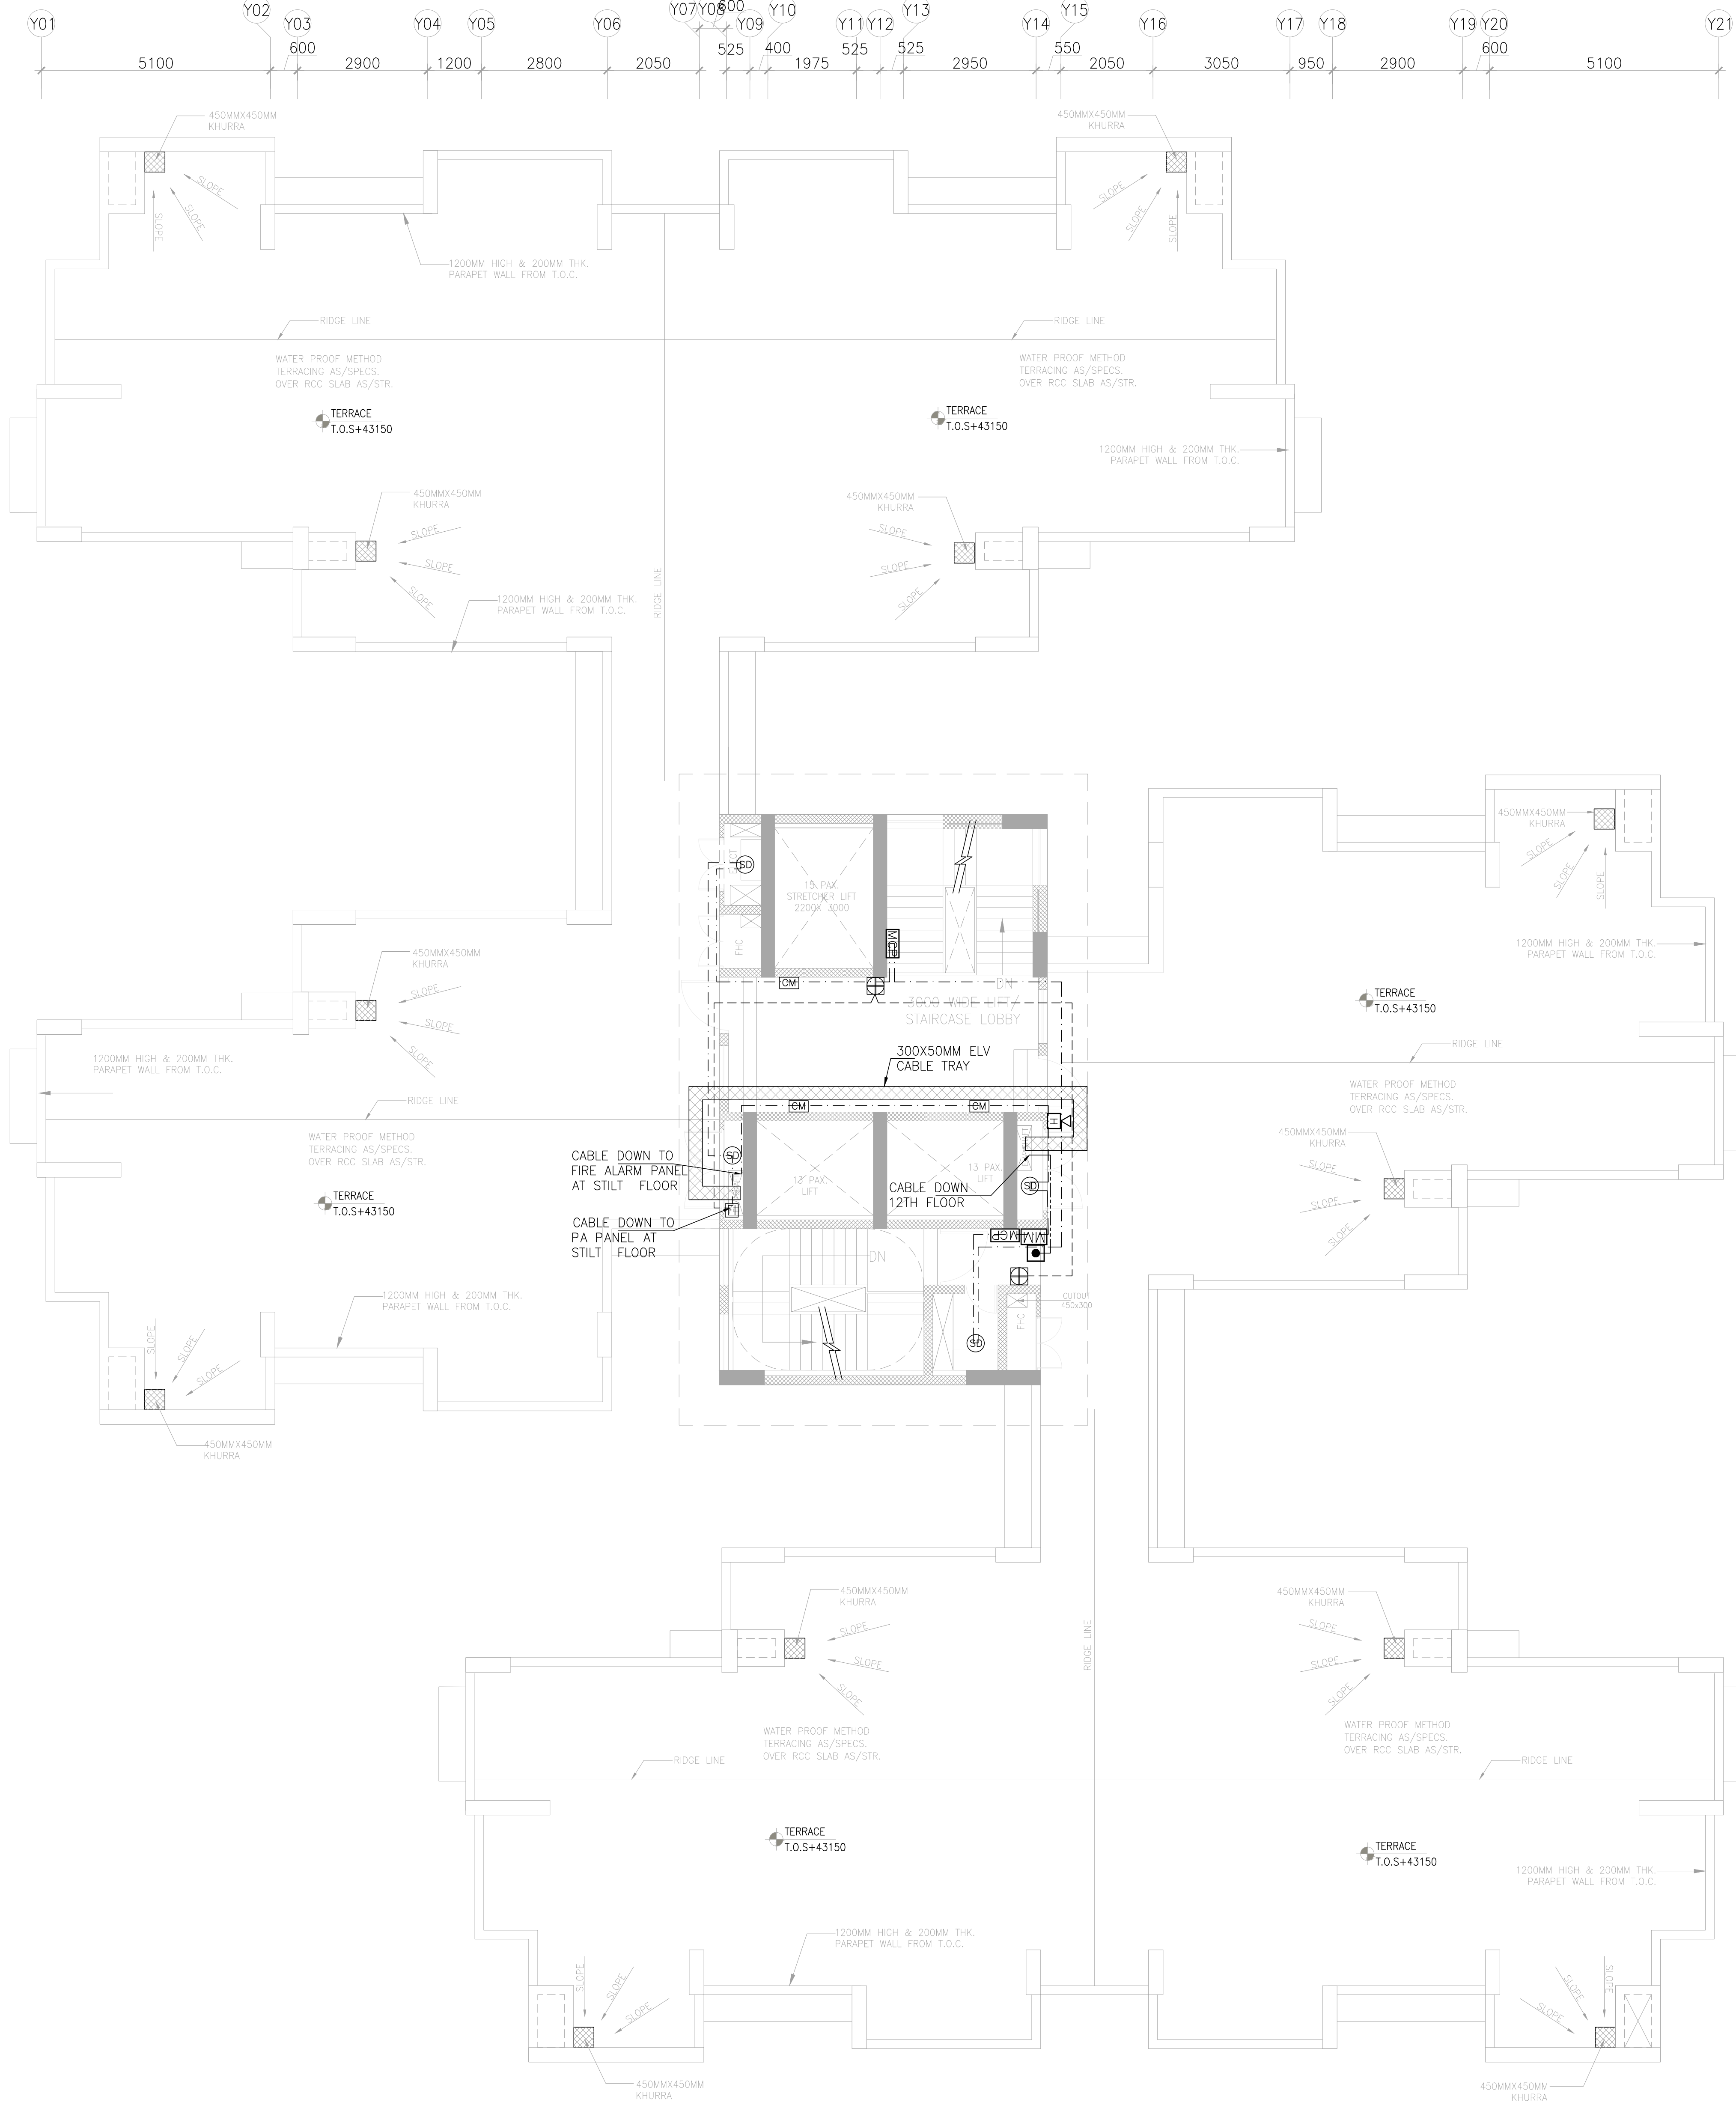

LEGENDS:-

S.NO	SYMBOL	DESCRIPTION	QTY.
01.		HOOTER WITH STROBE	01
02.		MANUAL CALL POINT	02
03.		CONTROL MODULE	03
04.		FIRE MAN'S TELEPHONE JACK	01
05.		SMOKE DETECTOR	04
06.		MONITOR MODULE	01
07.		FAULT ISOLATOR	01
08.		6W WALL MOUNTED SPEAKER	02
09.	---	2CX1.5 SQ.MM Cu. HFFR WIRE IN PVC CONDUIT	
10.	----	2CX1.5 SQ.MM Cu. HFFR WIRE IN PVC CONDUIT FOR FIRE PHONE JACK	
11.	-----	2CX1.5 SQ.MM Cu. FIRE RETARDANT INSULATED WIRE IN PVC CONDUIT FOR SPEAKER CABLE	

GENERAL NOTES:

- * ALL DIMENSIONS ARE IN MILLIMETERS, LEVELS IN METER. ALL DIMENSIONS ARE TO BE READ AND NOT MEASURED.
- * ANY/ ALL DISCREPANCIES MUST BE BROUGHT TO THE NOTICE OF THE CONSULTANT BEFORE PROCUREMENT/ EXECUTION OF WORK AT SITE.
- * THIS DRAWING MUST BE READ IN CONJUNCTION WITH ALL RELEVANT ARCHITECTURAL, STRUCTURAL, PLUMBING, FIRE FIGHTING, ELECTRICAL LAYOUTS AND RELATED SHOP-DRAWINGS.
- * ALL WALLS ARE ALIGNED TO FACE OF CONCRETE COLUMNS OR ARE ON CENTERLINE OF GRIDS UNLESS NOTED OTHERWISE.
- * ALL CIVIL WORKS AROUND/IN MEP AREAS SHALL BE CONSTRUCTED AS PER MEP CONSULTANT DETAILS & REQUIREMENT, AND SHALL BE CONSTRUCTED POST MEP SERVICES INSTALLATION/COMMISSIONING.
- * ALL FINISHES/LAYOUT OF LIFT-CORE, LOBBY, LOBBY TOILET, ETC. SHALL BE AS PER DESIGN DETAIL.
- * ALL SPARE SHAFT/UNUSED OUTOUTS OF SHAFTS SHALL BE FIRE-SEALED.
- * LIFT DOORS JAMB/WALLS/LINTELS SHALL BE EXECUTED ONLY UPON FINALIZATION OF LIFT SHOP DRAWINGS.
- * FFL, FGL, ETC. LEVELS MENTIONED ARE TO BE READ WITH REFERENCE FROM CONTIGUOUS DRIVEWAY. BLOCK DRIVEWAY LEVELS ARE TO BE REFERRED FROM SITE SETTING-OUT PLAN.

R2	06.03.2026	ISSUED FOR COMMENTS/APPROVAL	
R1	25.02.2026	ISSUED FOR COMMENTS/APPROVAL	
R0	13.10.2025	ISSUED FOR COMMENTS/APPROVAL	
REV.	DATE	REVISION NOTE	

NUCLEAR POWER CORPORATION OF INDIA LIMITED
(A GOVERNMENT OF INDIA ENTERPRISE)

REVIEWED:	APPROVED:
NAME:	NAME:
DATE:	DATE:

DRAWING NO. (NPCIL INTERNAL DWG. NO.) KAIGA-1-6/91214/5001/ELV/R0	REVISION NO. R0
--	--------------------

ARCHITECT:
 VYOM
ARCHITECTS & ENGINEERS
E-147, OKHLA PHASE-3, NEW DELHI 110020.
T: +91 11 2691 0018 / 0019
E: INFO@VYOM.IN W: WWW.VYOM.IN

TITLE :- FIRE ALARM & PA SYSTEM LAYOUT
TYPE-D SPECIAL (TERRACE FLOOR)

DES'D. DATE	DR'N. DATE	IA 06/03/2026	REV'D. DATE	AD 06/03/2026
DES. CHK'D. DATE	DRG. CHK'D. DATE	AD 06/03/2026	APP'D. DATE	AD 06/03/2026

PROJECT	KAIGA-5&6 TOWNSHIP	SCALE	1:100
		PROJECTION	

DRG. No. NPCL-KAGA-WD-ELV-DSP-120	REV. No. R2
-----------------------------------	----------------

FLOPPY/CD No. FILE NAME: TYPE-D SPECIAL

DRG. TO BE READ IN CONJUNCTION WITH DCN/FCN/ECN, IF ANY.

A1

A

B

C

D

E

F

G

H

I

J

K

L

M

N

O

P

Q

R

S

T

U

V

W

X

Y

Z

AA

AB

AC

AD

AE

AF

AG

AH

AI

AJ

AK

AL

AM

AN

AO

AP

AQ

AR

AS

AT

AU

AV

AW

AX

AY

AZ

BA

BB

BC

BD

BE

BF

BG

BH

BI

BJ

BK

BL

BM

BN

BO

BP

BQ

BR

BS

BT

BU

BV

BW

BX

BY

BZ

CA

CB

CC

CD

CE

CF

CG

CH

CI

CJ

CK

CL

CM

CN

CO

CP

CQ

CR

CS

CT

CU

CV

CW

CX

CY

CZ

DA

DB

DC

DD

DE

DF

DG

DH

DI

DJ

DK

DL

DM

DN

DO

DP

DQ

DR

DS

DT

DU

DV

DW

DX

DY

DZ

EA

EB

EC

ED

EE

EF

EG

EH

EI

EJ

EK

EL

EM

EN

EO

EP

EQ

ER

ES

ET

EU

EV

EW

EX

EY

EZ

FA

FB

FC

FD

FE

FF

FG

FH

FI

FJ

FK

FL

FM

FN

FO

FP

FQ

FR

FS

FT

FU

FV

FW

FX

FY

FZ

GA

GB

GC

GD

GE

GF

GG

GH

GI

GJ

GK

GL

GM

GN

GO

GP

GQ

GR

GS

GT

GU

GV

GW

GX

GY

GZ

HA

HB

HC

HD

HE

HF

HG

HH

HI

HJ

HK

HL

HM

HN

HO

HP

HQ

HR

HS

HT

HU

HV

HW

HX

HY

HZ

IA

IB

IC

ID

IE

IF

IG

IH

II

IJ

IK

IL

IM

IN

IO

IP

IQ

IR

IS

IT

IU

IV

IW

IX

IY

IZ

JA

JB

JC

JD

JE

JF

JG

JH

JI

IJ

JK

IL

JM

JN

JO

JP

JQ

JR

JS

JT

JU

JV

JW

JX

JY

JZ

KA

KB

KC

KD

KE

KF

KG

KH

KI

KJ

KK

KL

KM

KN

KO

KP

KQ

KR

KS

KT

KU

KV

KW

KX