


THIS DESIGN AND DRAWING IS THE PROPERTY OF THE NUCLEAR POWER CORPORATION. IT MUST BE RETURNED WITH QUOTATION / OR UPON DELIVERY OF MATERIAL / EQUIPMENT AND MUST NOT BE USED EXCEPT BY PERMISSION OF THE OWNER.

DRG. No. NPCL-KAGA-WD-PHE-DSP-121

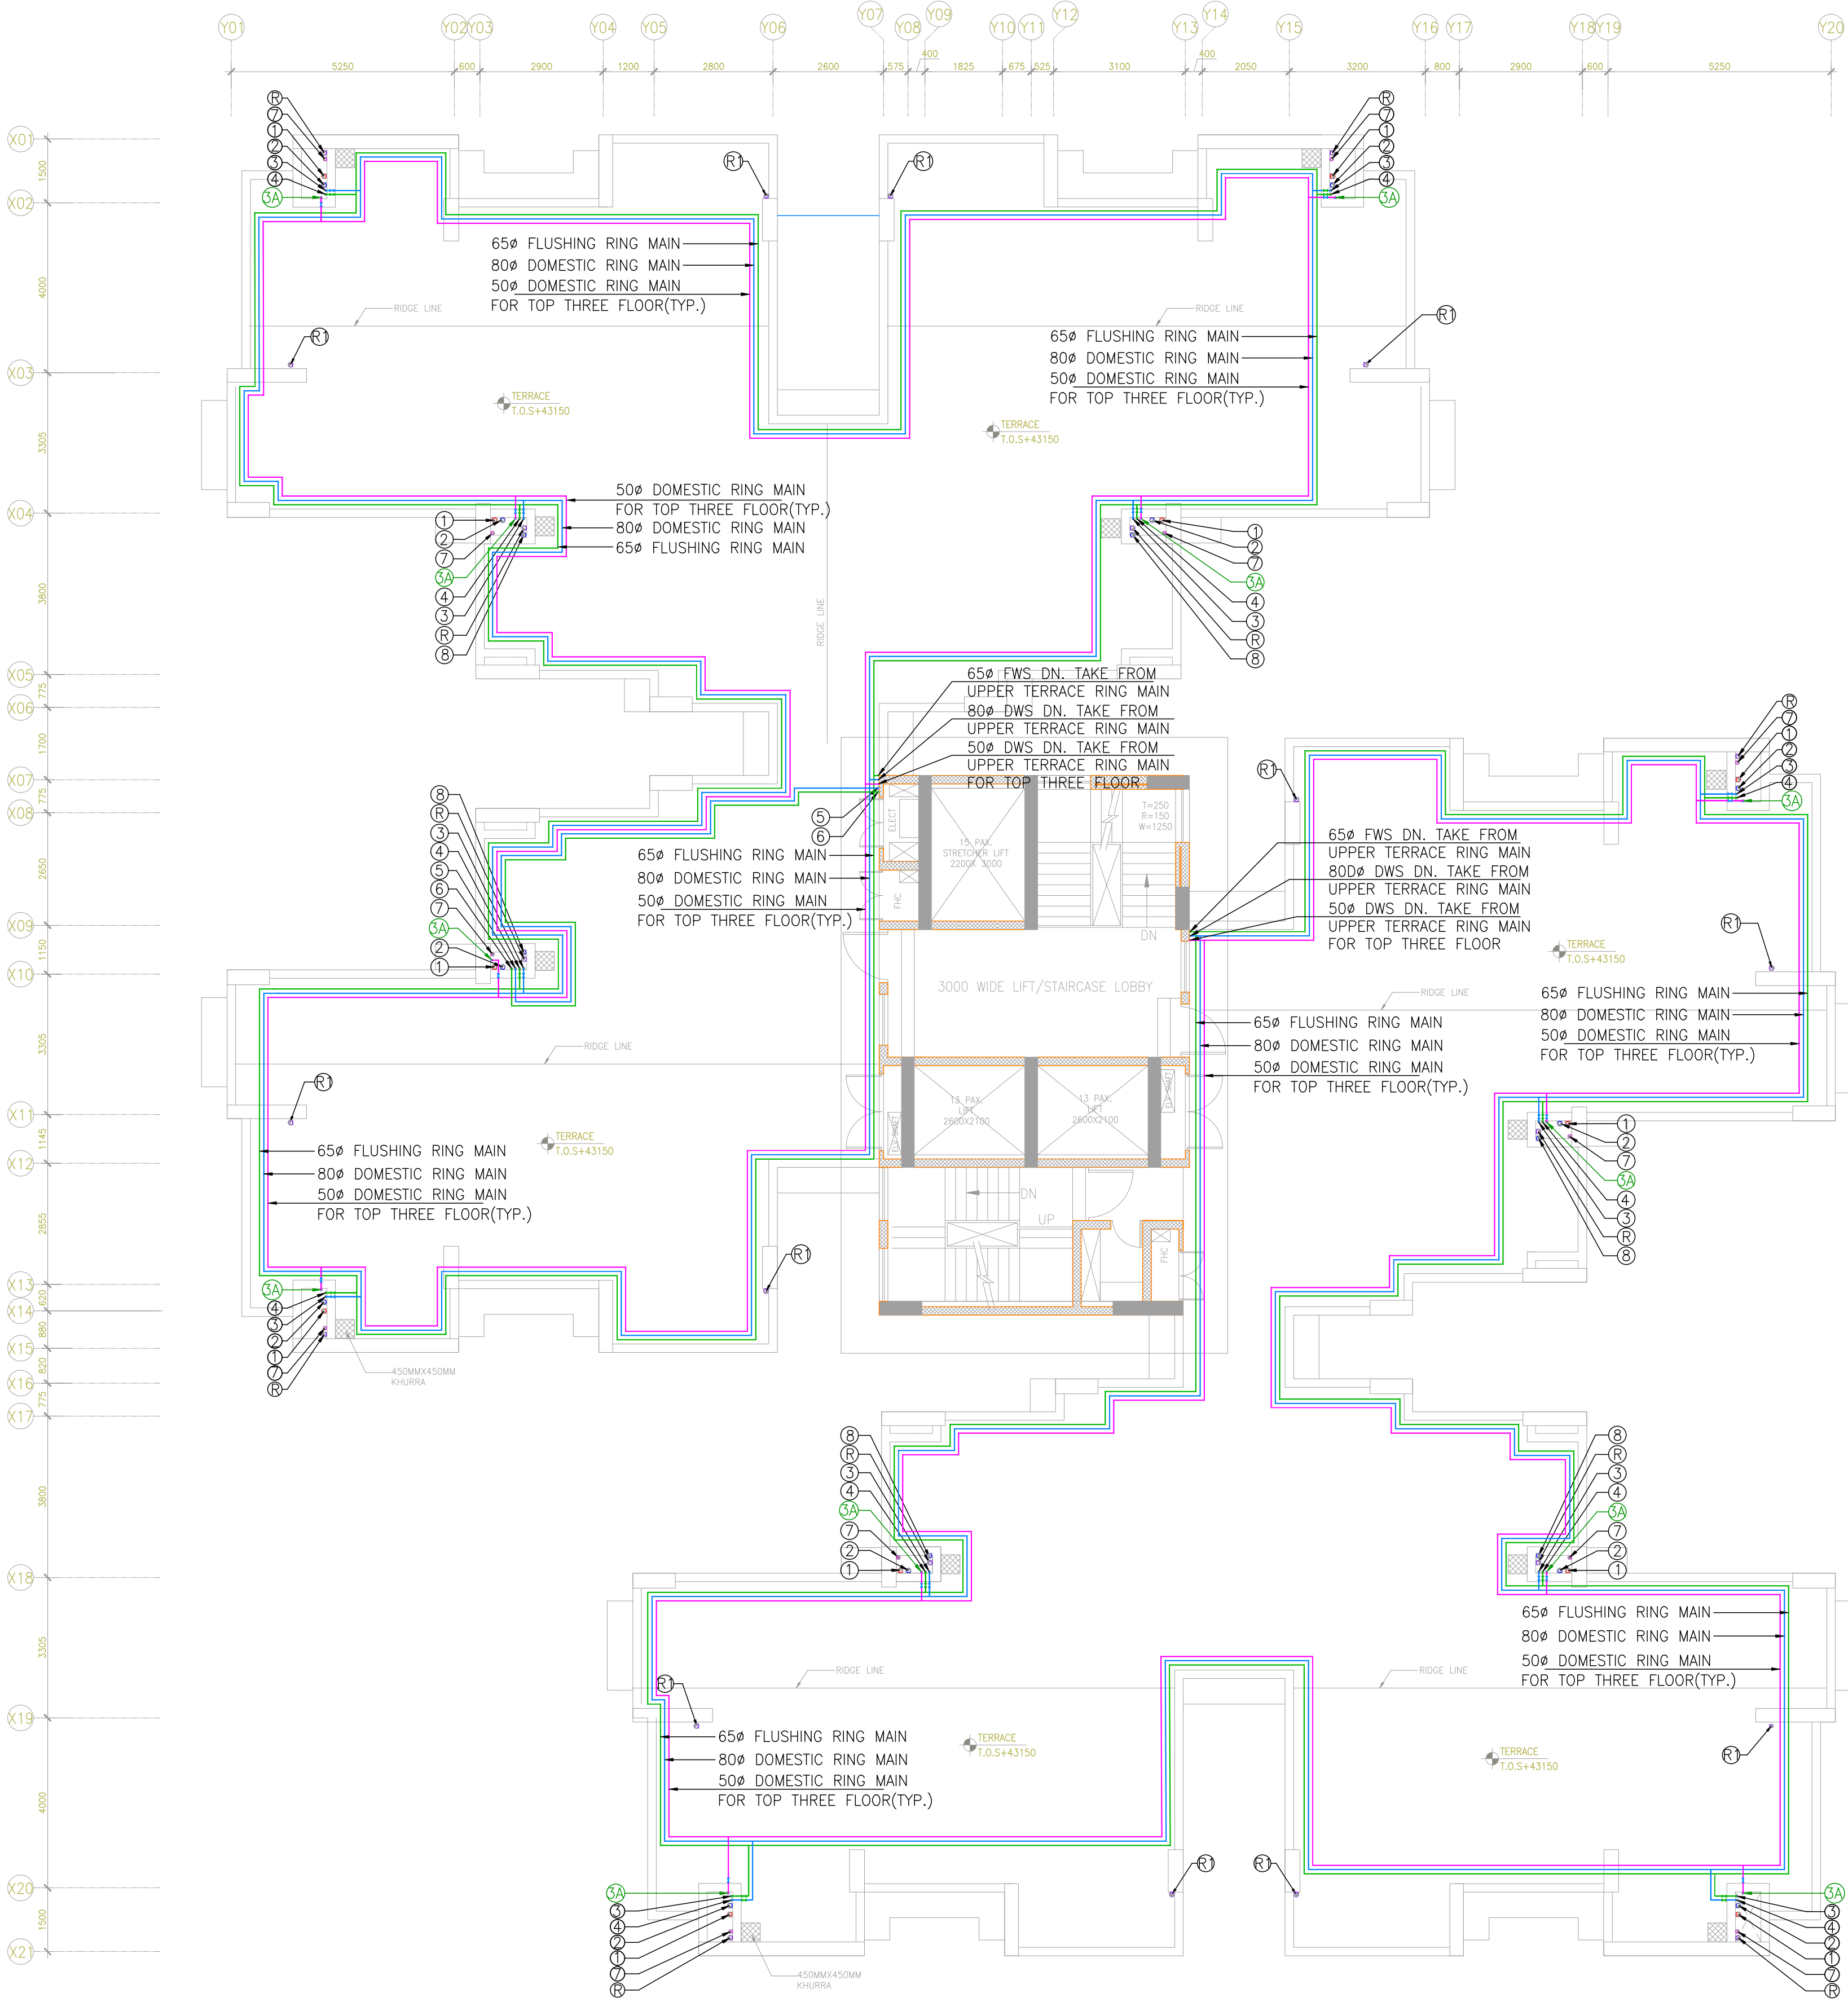

03 TERRACE PLAN  
SCALE 1:100

LEGENDS	
SYMBOL	DESCRIPTION
	DOMESTIC WATER SUPPLY PIPE (DWS)
	FLUSHING WATER SUPPLY PIPE (FWS)
	HOT WATER WATER SUPPLY PIPE (HWS)
	DOMESTIC WATER SUPPLY PIPE (FOR TOP THREE FLOOR)
①	110 OD SOIL & VENT PIPE
②	110 OD WASTE & VENT PIPE
③	DOMESTIC WATER SUPPLY PIPE
5A	DOMESTIC WATER SUPPLY PIPE (FOR TOP THREE FLOOR)
④	FLUSHING WATER SUPPLY PIPE
⑤	65Ø DOMESTIC WATER RISER PIPE
⑥	50Ø FLUSHING WATER RISER PIPE
⑦	75Ø AIR SYPHONAGE PIPE (ASP)
⑧	110 OD KITCHEN WASTE & VENT PIPE
R	110 OD RAIN WATER PIPE (TERRACE)
R	110 OD RAIN WATER PIPE (BALCONY)

GENERAL NOTES:

- \* ALL DIMENSIONS ARE IN MILLIMETERS, LEVELS IN METER. ALL DIMENSIONS ARE TO BE READ AND NOT MEASURED.
- \* ANY/ ALL DISCREPANCIES MUST BE BROUGHT TO THE NOTICE OF THE CONSULTANT BEFORE PROCUREMENT/ EXECUTION OF WORK AT SITE.
- \* THIS DRAWING MUST BE READ IN CONJUNCTION WITH ALL RELEVANT ARCHITECTURAL, STRUCTURAL, PLUMBING, FIRE FIGHTING, ELECTRICAL LAYOUTS AND RELATED SHOP-DRAWINGS.
- \* ALL WALLS ARE ALIGNED TO FACE OF CONCRETE COLUMNS OR ARE ON CENTERLINE OF GRIDS UNLESS NOTED OTHERWISE.
- \* ALL CIVIL WORKS AROUND/IN MEP AREAS SHALL BE CONSTRUCTED AS PER MEP CONSULTANT DETAILS & REQUIREMENT, AND SHALL BE CONSTRUCTED POST MEP SERVICES INSTALLATION/COMMISSIONING.
- \* ALL FINISHES/LAYOUT OF LIFT-CORE, LOBBY, LOBBY TOILET, ETC. SHALL BE AS PER DESIGN DETAIL.
- \* ALL SPARE SHAFT/UNUTILIZED OUTOUTS OF SHAFTS SHALL BE FIRE-SEALED.
- \* LIFT DOORS JAMB/WALLS/LINTELS SHALL BE EXECUTED ONLY UPON FINALIZATION OF LIFT SHOP DRAWINGS.
- \* FFL, FGL, ETC. LEVELS MENTIONED ARE TO BE READ WITH REFERENCE FROM CONTIGUOUS DRIVEWAY. BLOCK DRIVEWAY LEVELS ARE TO BE REFERRED FROM SITE SETTING-OUT PLAN.

R1	17.12.2025	ISSUED FOR COMMENTS/APPROVAL	
R0	06.08.2025	ISSUED FOR COMMENTS/APPROVAL	

REV.	DATE	REVISION NOTE
------	------	---------------

NUCLEAR POWER CORPORATION OF INDIA LIMITED  
( A GOVERNMENT OF INDIA ENTERPRISE )

REVIEWED:		APPROVED:	
NAME:		NAME:	
DATE:		DATE:	
DRAWING NO. (NPCIL INTERNAL DWG. NO.)		REVISION NO.	

ARCHITECT:  
 **VYOM**  
ARCHITECTS & ENGINEERS  
E-147, OKHLA PHASE-3, NEW DELHI 110020.  
T: +91 11 2691 0018 / 0019  
E: INFO@VYOM.IN W: WWW.VYOM.IN

TITLE :- WATER SUPPLY LAYOUT TERRACE  
FLOOR PLAN TYPE-D SPECIAL

DES'D. DATE	DR'N. DATE	SK 17/12/2025	REV'D. DATE	AD 17/12/2025
DES. CHK'D. DATE	DRG. CHK'D. DATE	AD 17/12/2025	APP'D. DATE	AD 17/12/2025

PROJECT KAIGA-5&6 TOWNSHIP  
SCALE 1:100  
PROJECTION

DRG. No. NPCL-KAGA-WD-PHE-DSP-121  
FLOPPY/CD No. FILE NAME: TYPE-D SPECIAL  
REV. No. R1

DRG. TO BE READ IN CONJUNCTION WITH DCN/FCN/ECN, IF ANY.