

PROJECT TITLE

IIM SHILLONG
AUDITORIUM BLOCK

DRAWING TITLE

STAGE GRID LAYOUT
AUDITORIUM

AV & ACOUSTIC CONSULTANT



DATE 25-06-2025

SCALE NTS

DRAWN BY S.K


DEALT BY S.K

CHECKED BY A.G

REVISION NO R1

DRAWING NO:
IMPCE/ICC/RB/AV/001

PLAN (CURTAIN & LIGHT BAR)

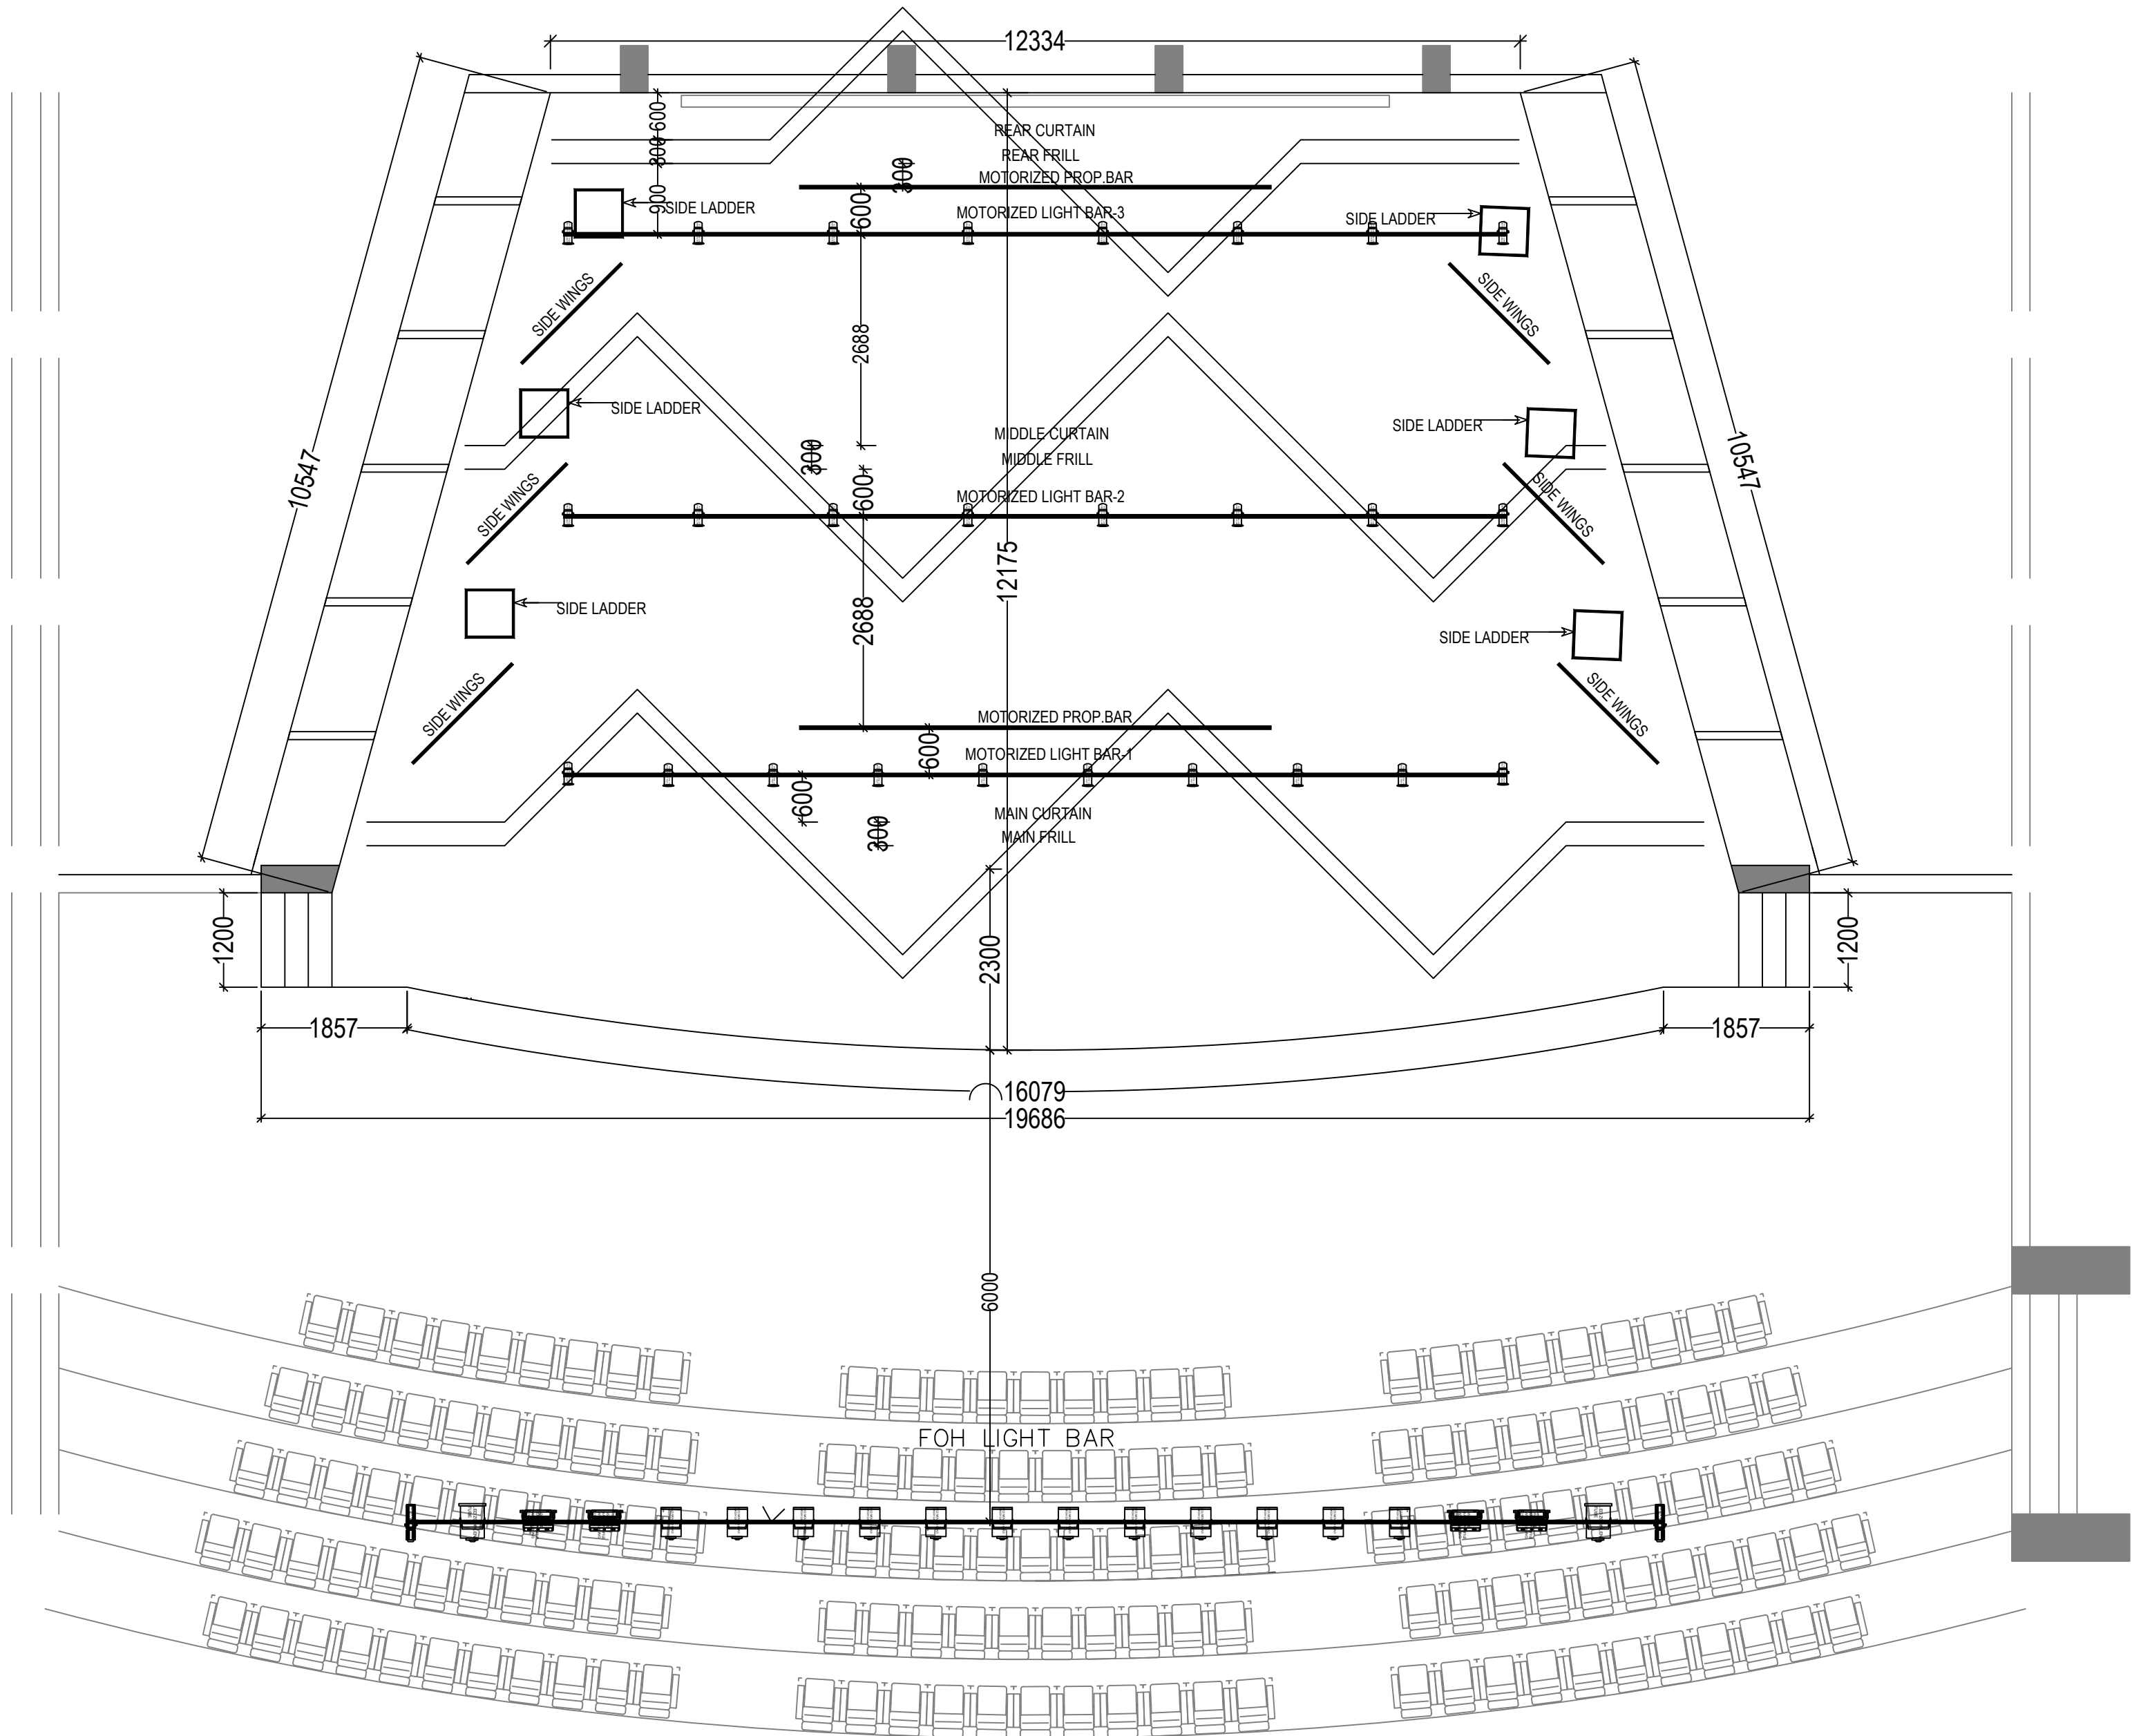

LEGEND		
S.No.	SYMBOL	ITEM NAME : TOTAL
1.		Main Curtain 01 no.
2.		Middle Curtain 01 no.
3.		Rear Curtain 01 no.
4.		Main Frill 01 no.
5.		Middle Frill 01 no.
6.		Rear Frill 01 no.
7.		Side Wings 06 nos.
8.		Side Ladder 06 nos.
9.		Motorized Light Bar 03 nos.
10.		Fixed FOH Light Bar 01 no.
11.		Motorized Prop.Light Bar 02 nos.
12.		19x40watt RGBW AURA LED MOVING HEAD WASH 12 nos.
13.		550watt LED BASED PROFILE WITH FRAMING 04 nos.
14.		FULL COLOR LED ELLIPSOIDAL PROFILE 02 nos.
15.		ELP ZOOMLESS TUBE 02 nos.
16.		EXTRA BRIGHT VERSION OF SUCCESSFUL 20 nos.
17.		COMPACT LED WITH MOVING HEAD PROFILE WITH CMY COLOR 06 nos.
18.		SIDE LADDER LIGHT 12 nos.

PROJECT TITLE

IIM SHILLONG
AUDITORIUM BLOCK

DRAWING TITLE

STAGE LIGHTING LAYOUT
AUDITORIUM

AV & ACOUSTIC CONSULTANT



DATE 25-06-2025

SCALE NTS

DRAWN BY S.K

DEALT BY S.K


CHECKED BY A.G

REVISION NO R1

DRAWING NO:

IMPCE/ICC/RB/AV/002

SECTION THROUGH CURTAIN

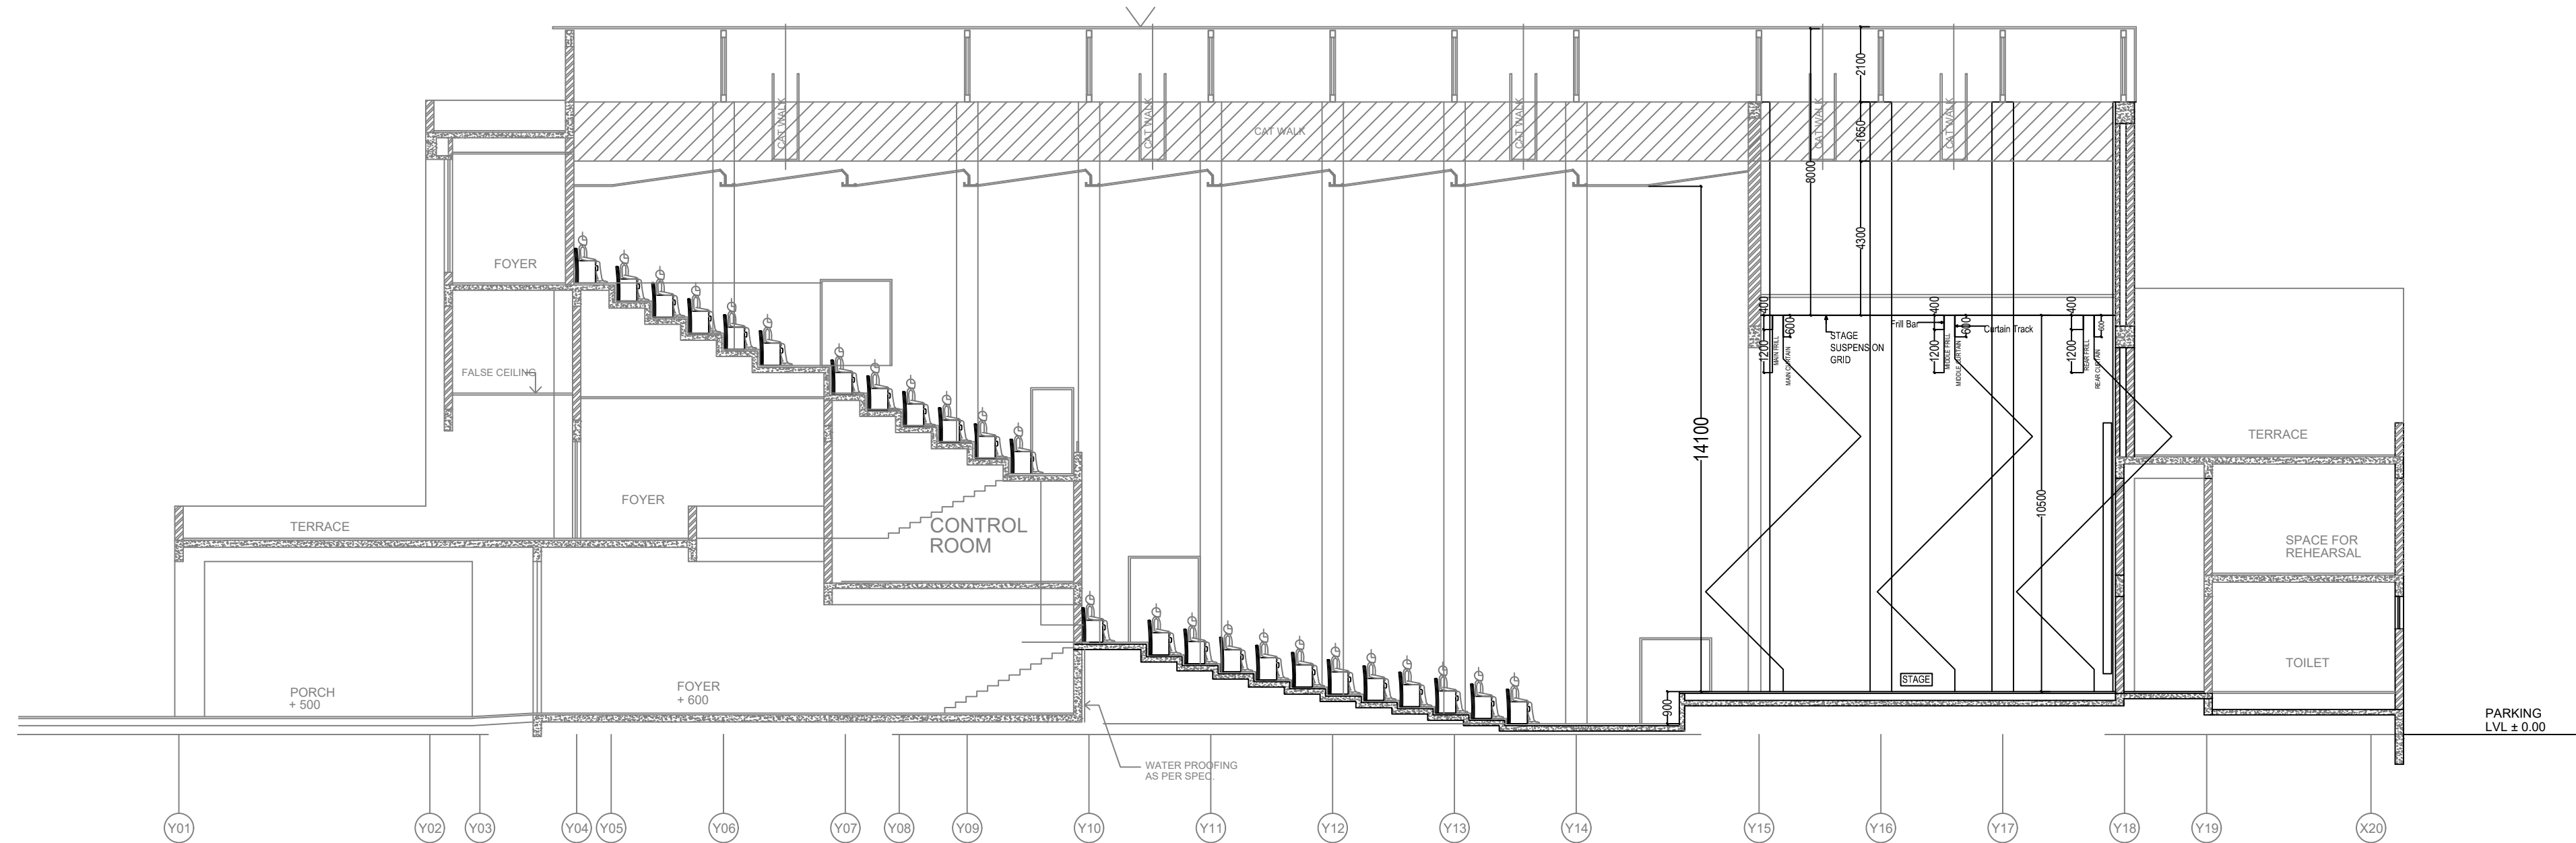

LEGEND			
S.No.	SYMBOL	ITEM NAME :	TOTAL
1.		Main Curtain	01 no.
2.		Middle Curtain	01 no.
3.		Rear Curtain	01 no.
4.		Main Frill	01 no.
5.		Middle Frill	01 no.
6.		Rear Frill	01 no.
7.		Side Wings	06 nos.
8.		Side Ladder	06 nos.
9.		Motorized Light Bar	03 nos.
10.		Fixed FOH Light Bar	01 no.
11.		Motorized Prop.Light Bar	02 nos.
12.		19x40watt RGBW AURA LED MOVING HEAD WASH	12 nos.
13.		550watt LED BASED PROFILE WITH FRAMING	04 nos.
14.		FULL COLOR LED ELLIPSOIDAL PROFILE	02 nos.
15.		ELP ZOOMLESS TUBE	02 nos.
16.		EXTRA BRIGHT VERSION OF SUCCESSFUL	20 nos.
17.		COMPACT LED WITH MOVING HEAD PROFILE WITH CMY COLOR	06 nos.
18.		SIDE LADDER LIGHT	12 nos.

PROJECT TITLE

IIM SHILLONG
AUDITORIUM BLOCK

DRAWING TITLE

STAGE FURNISHING SECTION
AUDITORIUM

AV & ACOUSTIC CONSULTANT



DATE 25-06-2025

SCALE NTS

DRAWN BY S.K


DEALT BY S.K

CHECKED BY A.G


REVISION NO R1

DRAWING NO:


IMPCE/ICC/RB/AV/003

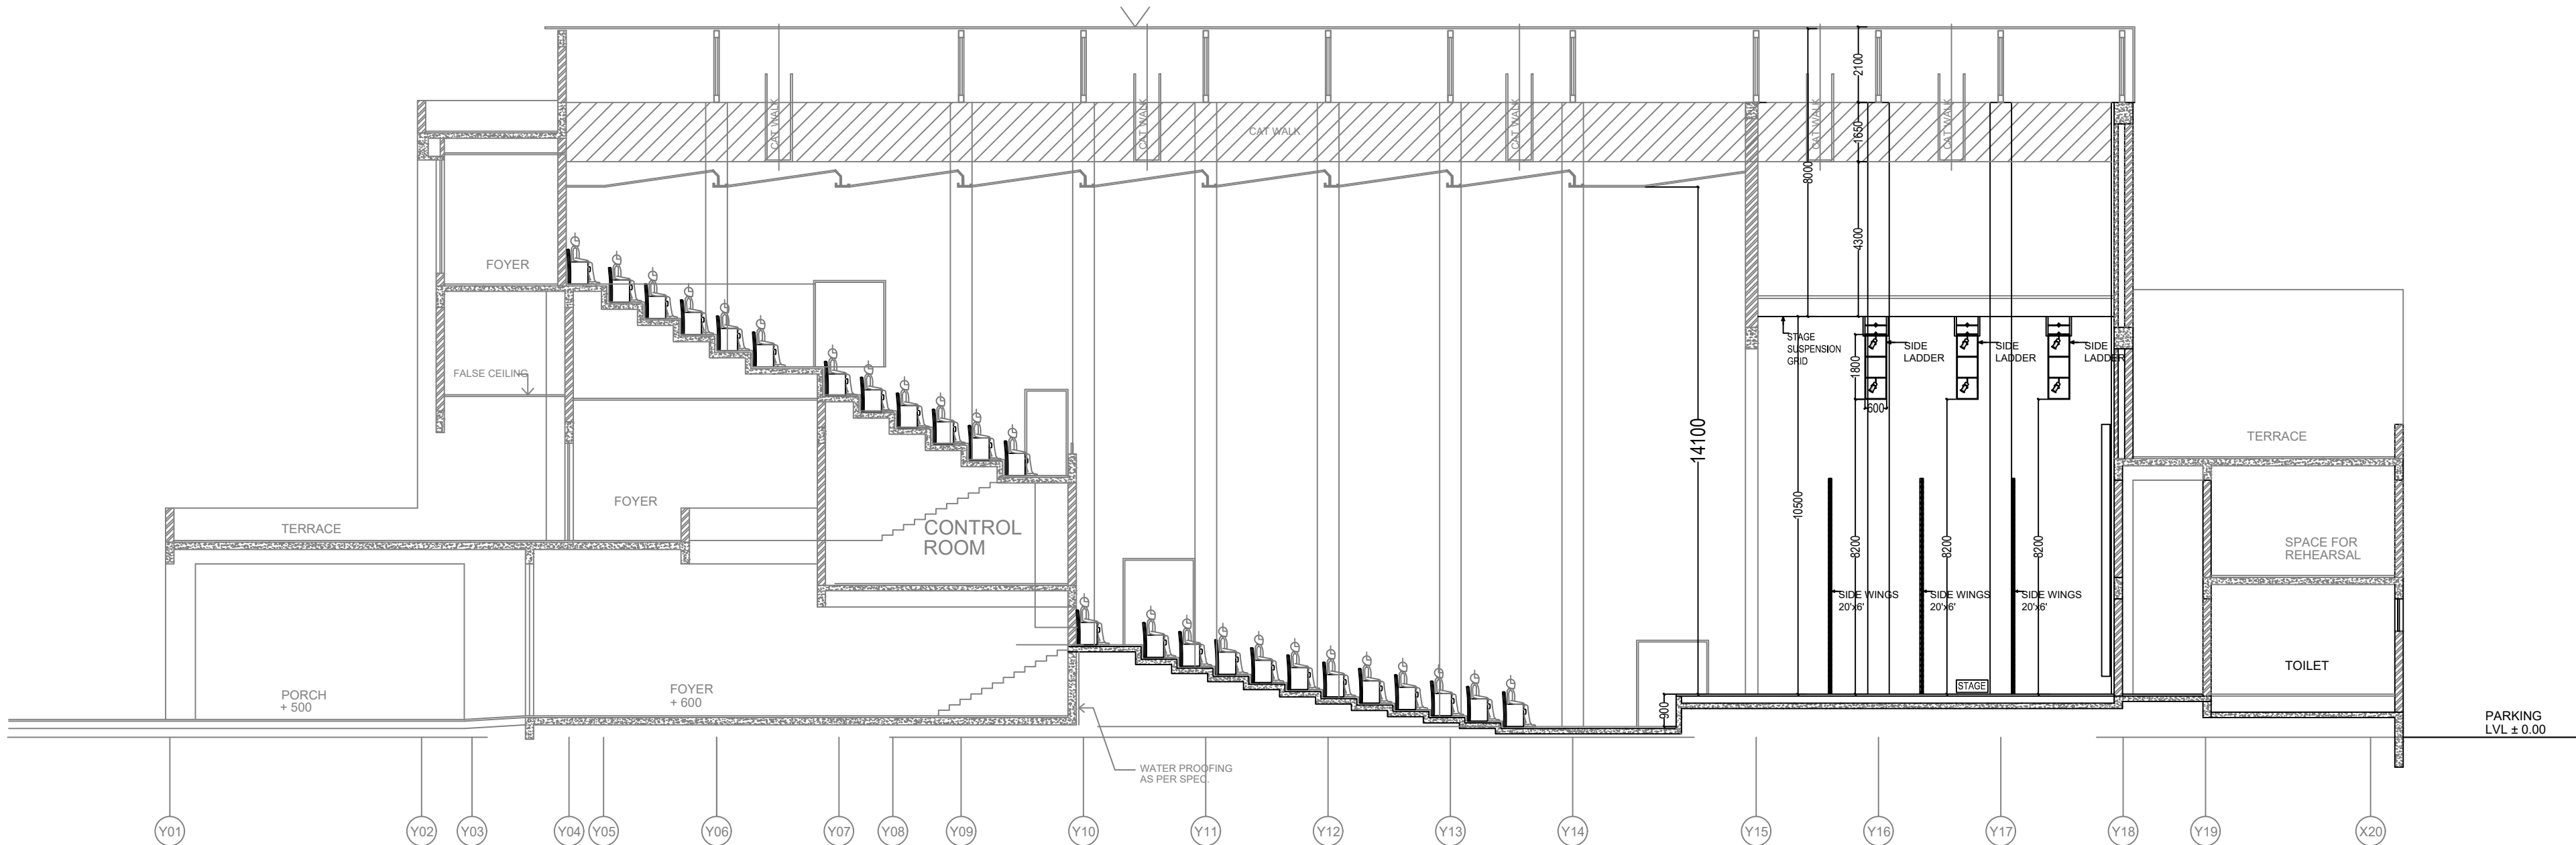

LEGEND			
S.No.	SYMBOL	ITEM NAME :	TOTAL
1.		Main Curtain	01 no.
2.		Middle Curtain	01 no.
3.		Rear Curtain	01 no.
4.		Main Frill	01 no.
5.		Middle Frill	01 no.
6.		Rear Frill	01 no.
7.		Side Wings	06 nos.
8.		Side Ladder	06 nos.
9.		Motorized Light Bar	03 nos.
10.		Fixed FOH Light Bar	01 no.
11.		Motorized Prop.Light Bar	02 nos.
12.		19x40watt RGBW AURA LED MOVING HEAD WASH	12 nos.
13.		550watt LED BASED PROFILE WITH FRAMING	04 nos.
14.		FULL COLOR LED ELLIPSOIDAL PROFILE	02 nos.
15.		ELP ZOOMLESS TUBE	02 nos.
16.		EXTRA BRIGHT VERSION OF SUCCESSFUL	20 nos.
17.		COMPACT LED WITH MOVING HEAD PROFILE WITH CMY COLOR	06 nos.
18.		SIDE LADDER LIGHT	12 nos.

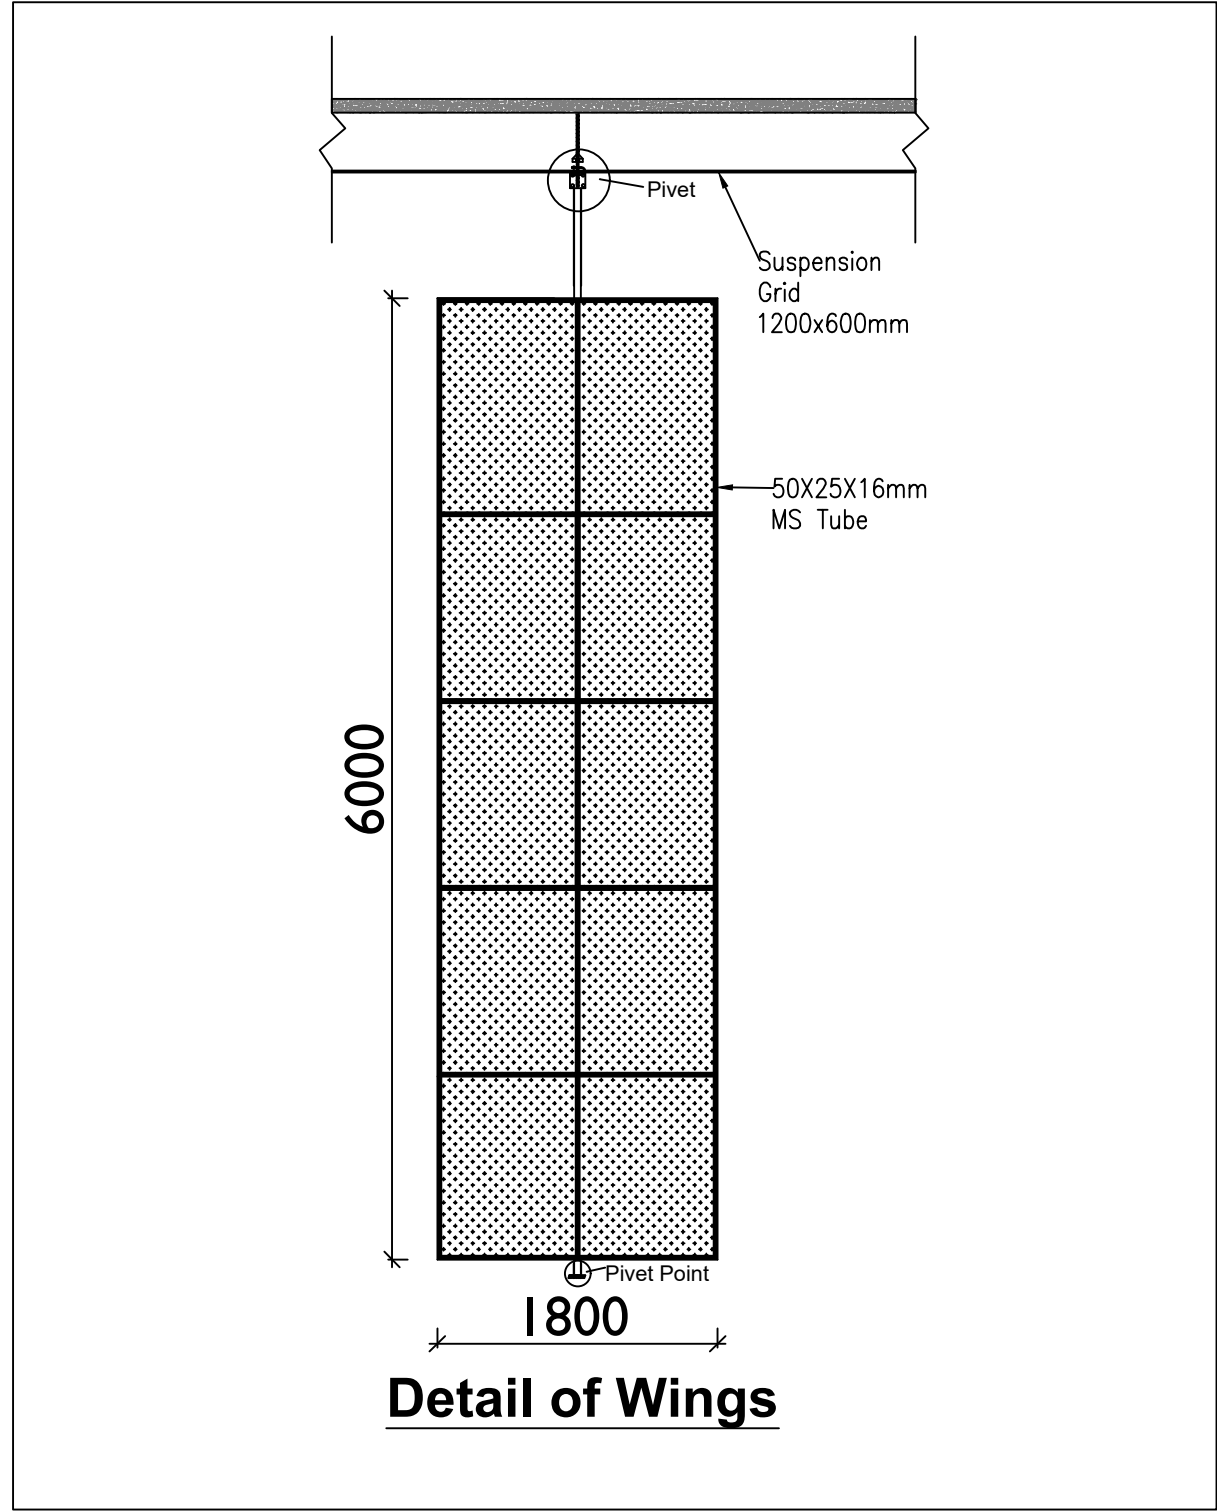

SECTION THROUGH SIDE WINGS

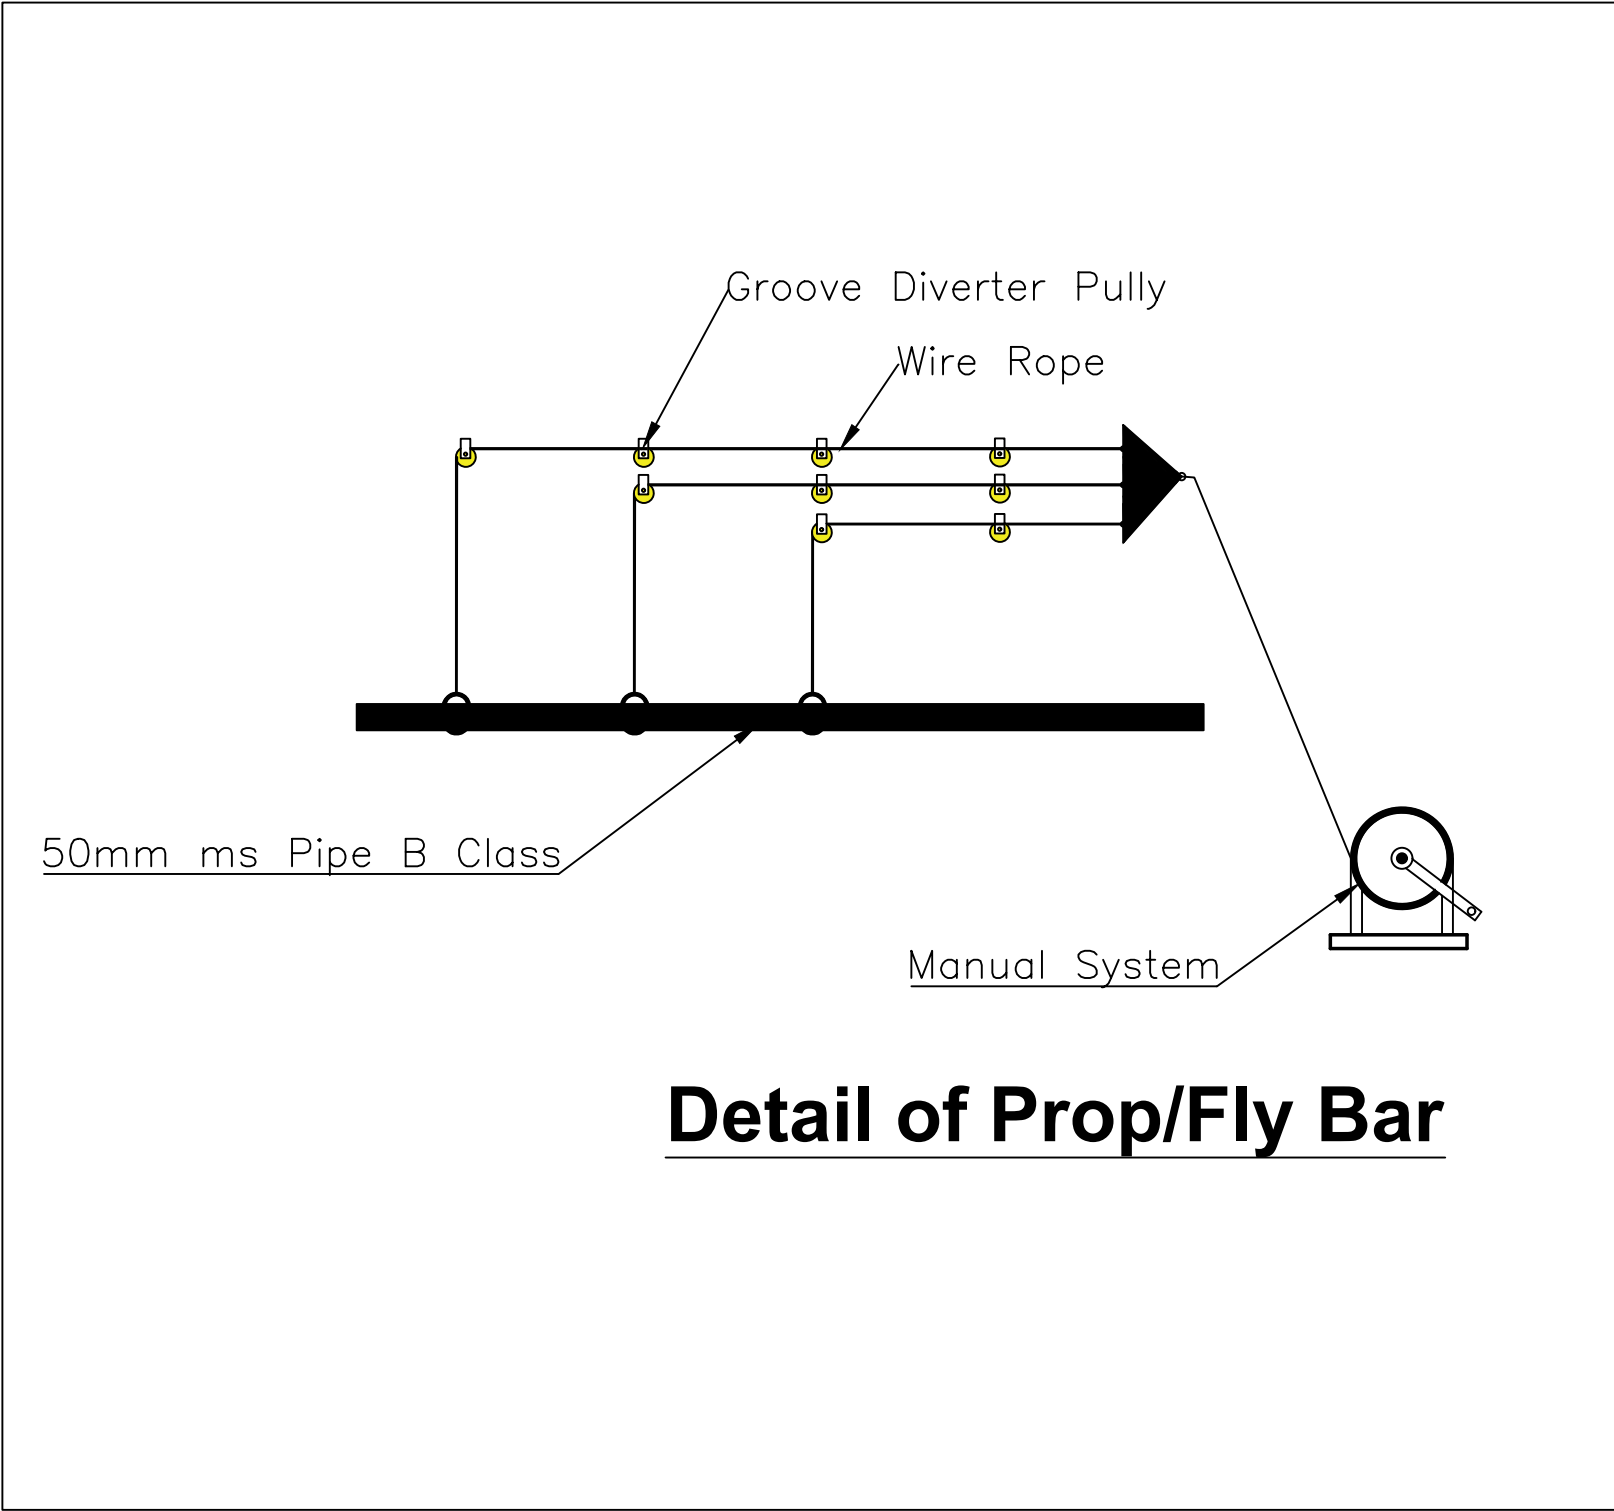

PROJECT TITLE	
IIM SHILLONG AUDITORIUM BLOCK	
DRAWING TITLE	
STAGE SIDE WINGS SECTION AUDITORIUM	
AV & ACOUSTIC CONSULTANT	
DATE	25-06-2025
SCALE	NTS
DRAWN BY	S.K
DEALT BY	S.K
CHECKED BY	A.G
REVISION NO	R1
DRAWING NO:	
IMPCE/ICC/RB/AV/004	