



S.NO.	LEGENDS TABLE FIRE ALARM SYSTEM
01.	FIRE ALARM CONTROL PANEL
02.	SMOKE DETECTOR ON FALSE CEILING
03.	SMOKE DETECTOR ON SLAB
04.	HEAT DETECTOR ON SLAB
05.	MANUAL CALL POINT DEVICE
06.	RESPONSE INDICATOR
07.	HOOTER CUM STROBE
08.	CONTROL MODULE DEVICE
09.	MONITOR MODULE DEVICE @FHC's SHAFT
10.	FAULT ISOLATOR DEVICE AS PER LOOP @25D
11.	RELAY MODULE DEVICE
12.	BEAM DETECTOR
13.	BEAM RECEIVER
14.	TALK BACK DEVICE

S.NO.	LEGENDS TABLE CCTV SYSTEM
01.	NETWORK VIDEO RECORDER AS PER SITE
02.	DOME CAMERA
03.	BULLEET CAMERA
04.	PTZ CAMERA

S.NO.	LEGENDS TABLE PUBLIC ADDRESS SYSTEM
01.	AMPLIFIER UNIT
02.	CEILING MOUNTED SPEAKER
03.	WALL MOUNTED SPEAKER
04.	MICROPHONE
05.	VOLUME CONTROLLER


PROJECT NAME
IIM SHILLONG, UMSAWLI CAMPUS SHILLONG

ARCHITECT
AKSHAYA JAIN & ASSOCIATES
ARCHITECTURE. PLANNING. INTERIOR DESIGN
C-6 / 6098, VASANT KUNJ, NEW DELHI - 110070
TELEPHONES +91-11-26136098, 26132304, 41601615
FAX +91-11-26132304 E-Mail : mail@okshayajain.com

ELECTRICAL SERVICES CONSULTANT
ECMS INDIA PVT. LTD.
WP-21 C-282, BASEMENT
NOIDA SECTOR-71,
UTTAR PRADESH-201307
E-mail: ecms.tech01@gmail.com
URL: www.ecmsindia.com
Ph.No. 0120-3502815

DRAWING TITLE-
EL- FAS, PAS & CCTV LAYOUT (BASEMENT PLAN)
CONVENTION CENTRE (SITE - 10)-AUDI

<input type="checkbox"/> FOR APPROVAL	<input type="checkbox"/> ADVANCE COPY
<input checked="" type="checkbox"/> TENDER DRAWING	<input type="checkbox"/> GOOD FOR CONSTRUCTION
DRAWN BY MIHIR	REV NO. R0(25.06.2025)
CKD BY YASHI	SCALE 1:180(A2)
FIN. YEAR 2024-25	JOB NO. 2516
DRAWING NO. IIM/ECMS/CON./CENTRE/AUDI/BASE./FAS/PAS/CCTV-01	

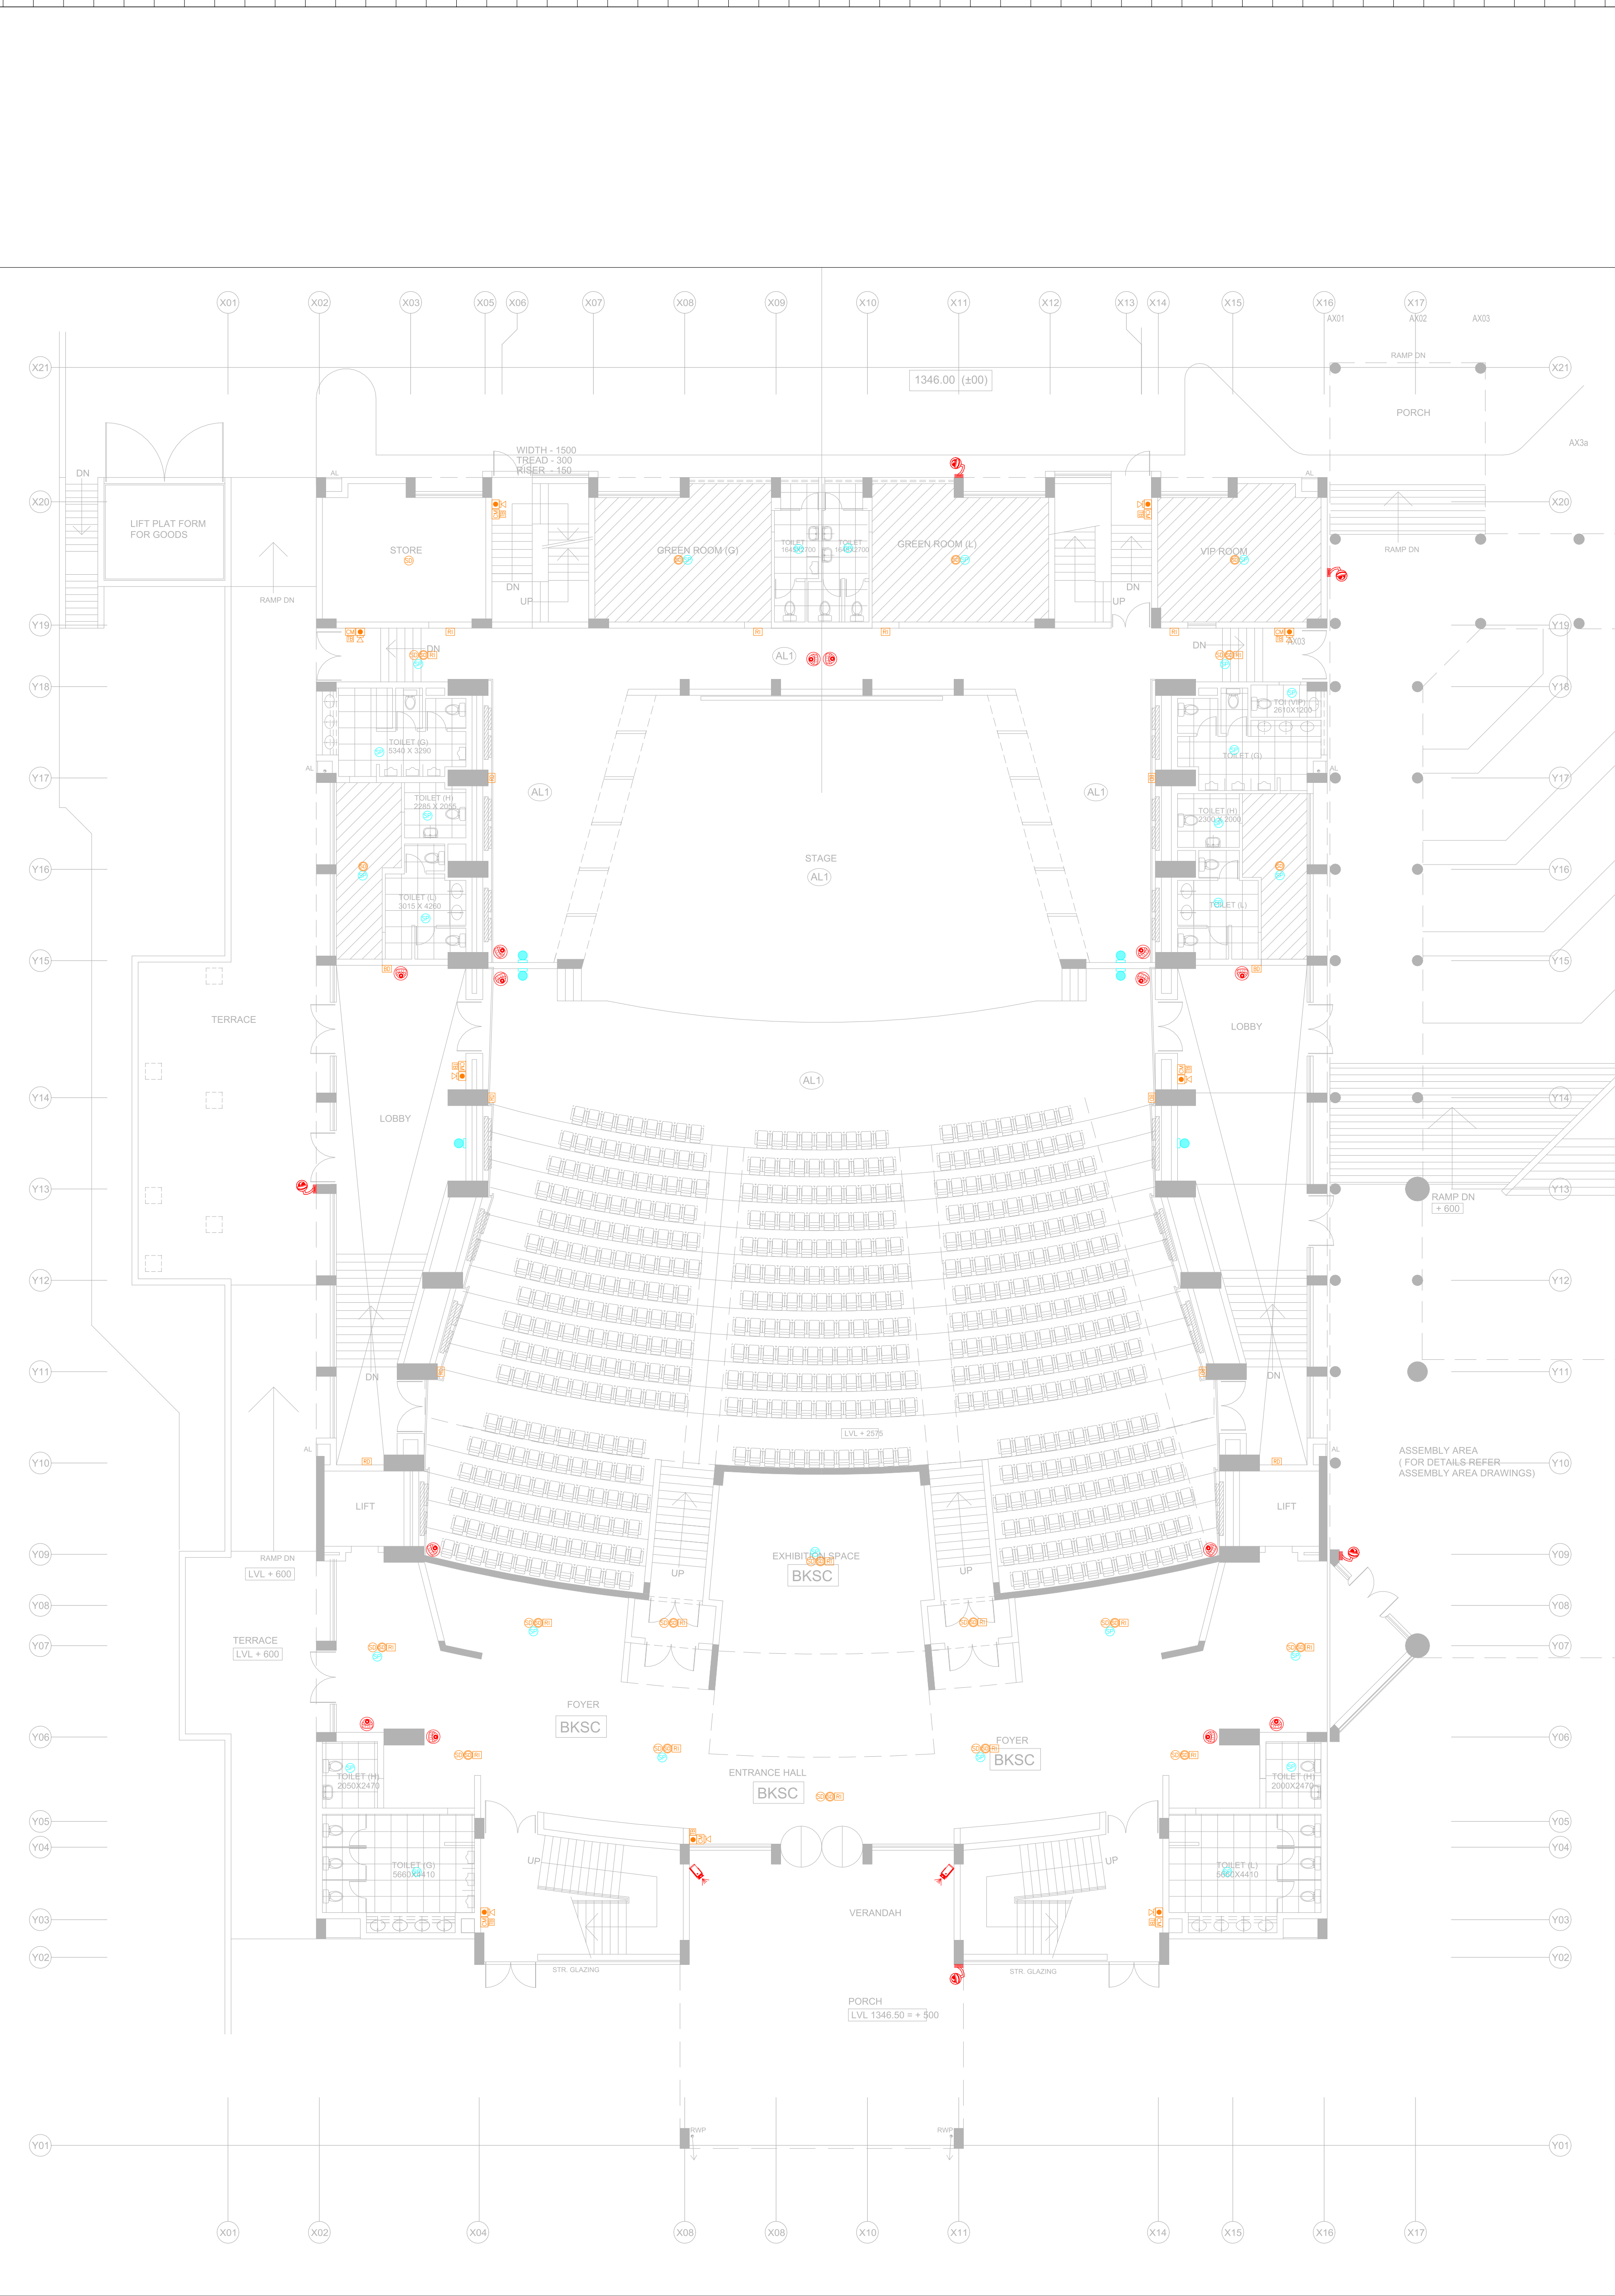

S.NO.	LEGENDS TABLE FIRE ALARM SYSTEM
01.	FIRE ALARM CONTROL PANEL
02.	SMOKE DETECTOR ON FALSE CEILING
03.	SMOKE DETECTOR ON SLAB
04.	HEAT DETECTOR ON SLAB
05.	MANUAL CALL POINT DEVICE
06.	RESPONSE INDICATOR
07.	HOOTER CUM STROBE
08.	CONTROL MODULE DEVICE
09.	MONITOR MODULE DEVICE @FHC's SHAFT
10.	FAULT ISOLATOR DEVICE AS PER LOOP @25D
11.	RELAY MODULE DEVICE
12.	BEAM DETECTOR
13.	BEAM RECEIVER
14.	TALK BACK DEVICE

S.NO.	LEGENDS TABLE CCTV SYSTEM
01.	NETWORK VIDEO RECORDER AS PER SITE
02.	DOME CAMERA
03.	BULLET CAMERA
04.	PTZ CAMERA

S.NO.	LEGENDS TABLE PUBLIC ADDRESS SYSTEM
01.	AMPLIFIER UNIT
02.	CEILING MOUNTED SPEAKER
03.	WALL MOUNTED SPEAKER
04.	MICROPHONE
05.	VOLUME CONTROLLER

PROJECT NAME
IIM SHILLONG, UMSAWLI CAMPUS SHILLONG

ARCHITECT
AKSHAYA JAIN & ASSOCIATES
ARCHITECTURE. PLANNING. INTERIOR DESIGN
C-6 / 6098, VASANT KUNJ, NEW DELHI - 110070
TELEPHONES +91-11-26136098, 26132304, 41601615
FAX +91-11-26132304 E-Mail : mail@okshayajain.com

ELECTRICAL SERVICES CONSULTANT
**ECMS INDIA PVT. LTD.**
WP-21 C-282, BASEMENT
NOIDA SECTOR-71,
UTTAR PRADESH-201307
E-mail: ecms.tech01@gmail.com
URL: www.ecmsindia.com
Ph.No. 0120-3502815

DRAWING TITLE-
EL- FAS, PAS & CCTV LAYOUT (PLAN LEVEL -1)
CONVENTION CENTRE (SITE - 10)-AUDI


FOR APPROVAL	ADVANCE COPY
TENDER DRAWING	GOOD FOR CONSTRUCTION

DRAWN BY MIHIR REV NO. R0(25.06.2025)

CKD BY YASHI SCALE 1:180(A2)

FIN. YEAR 2024-25 JOB NO. 2516

DRAWING NO. IIM/ECMS/CON./CENTRE/AUDI/LVL.-1/FAS/PAS/CCTV-02

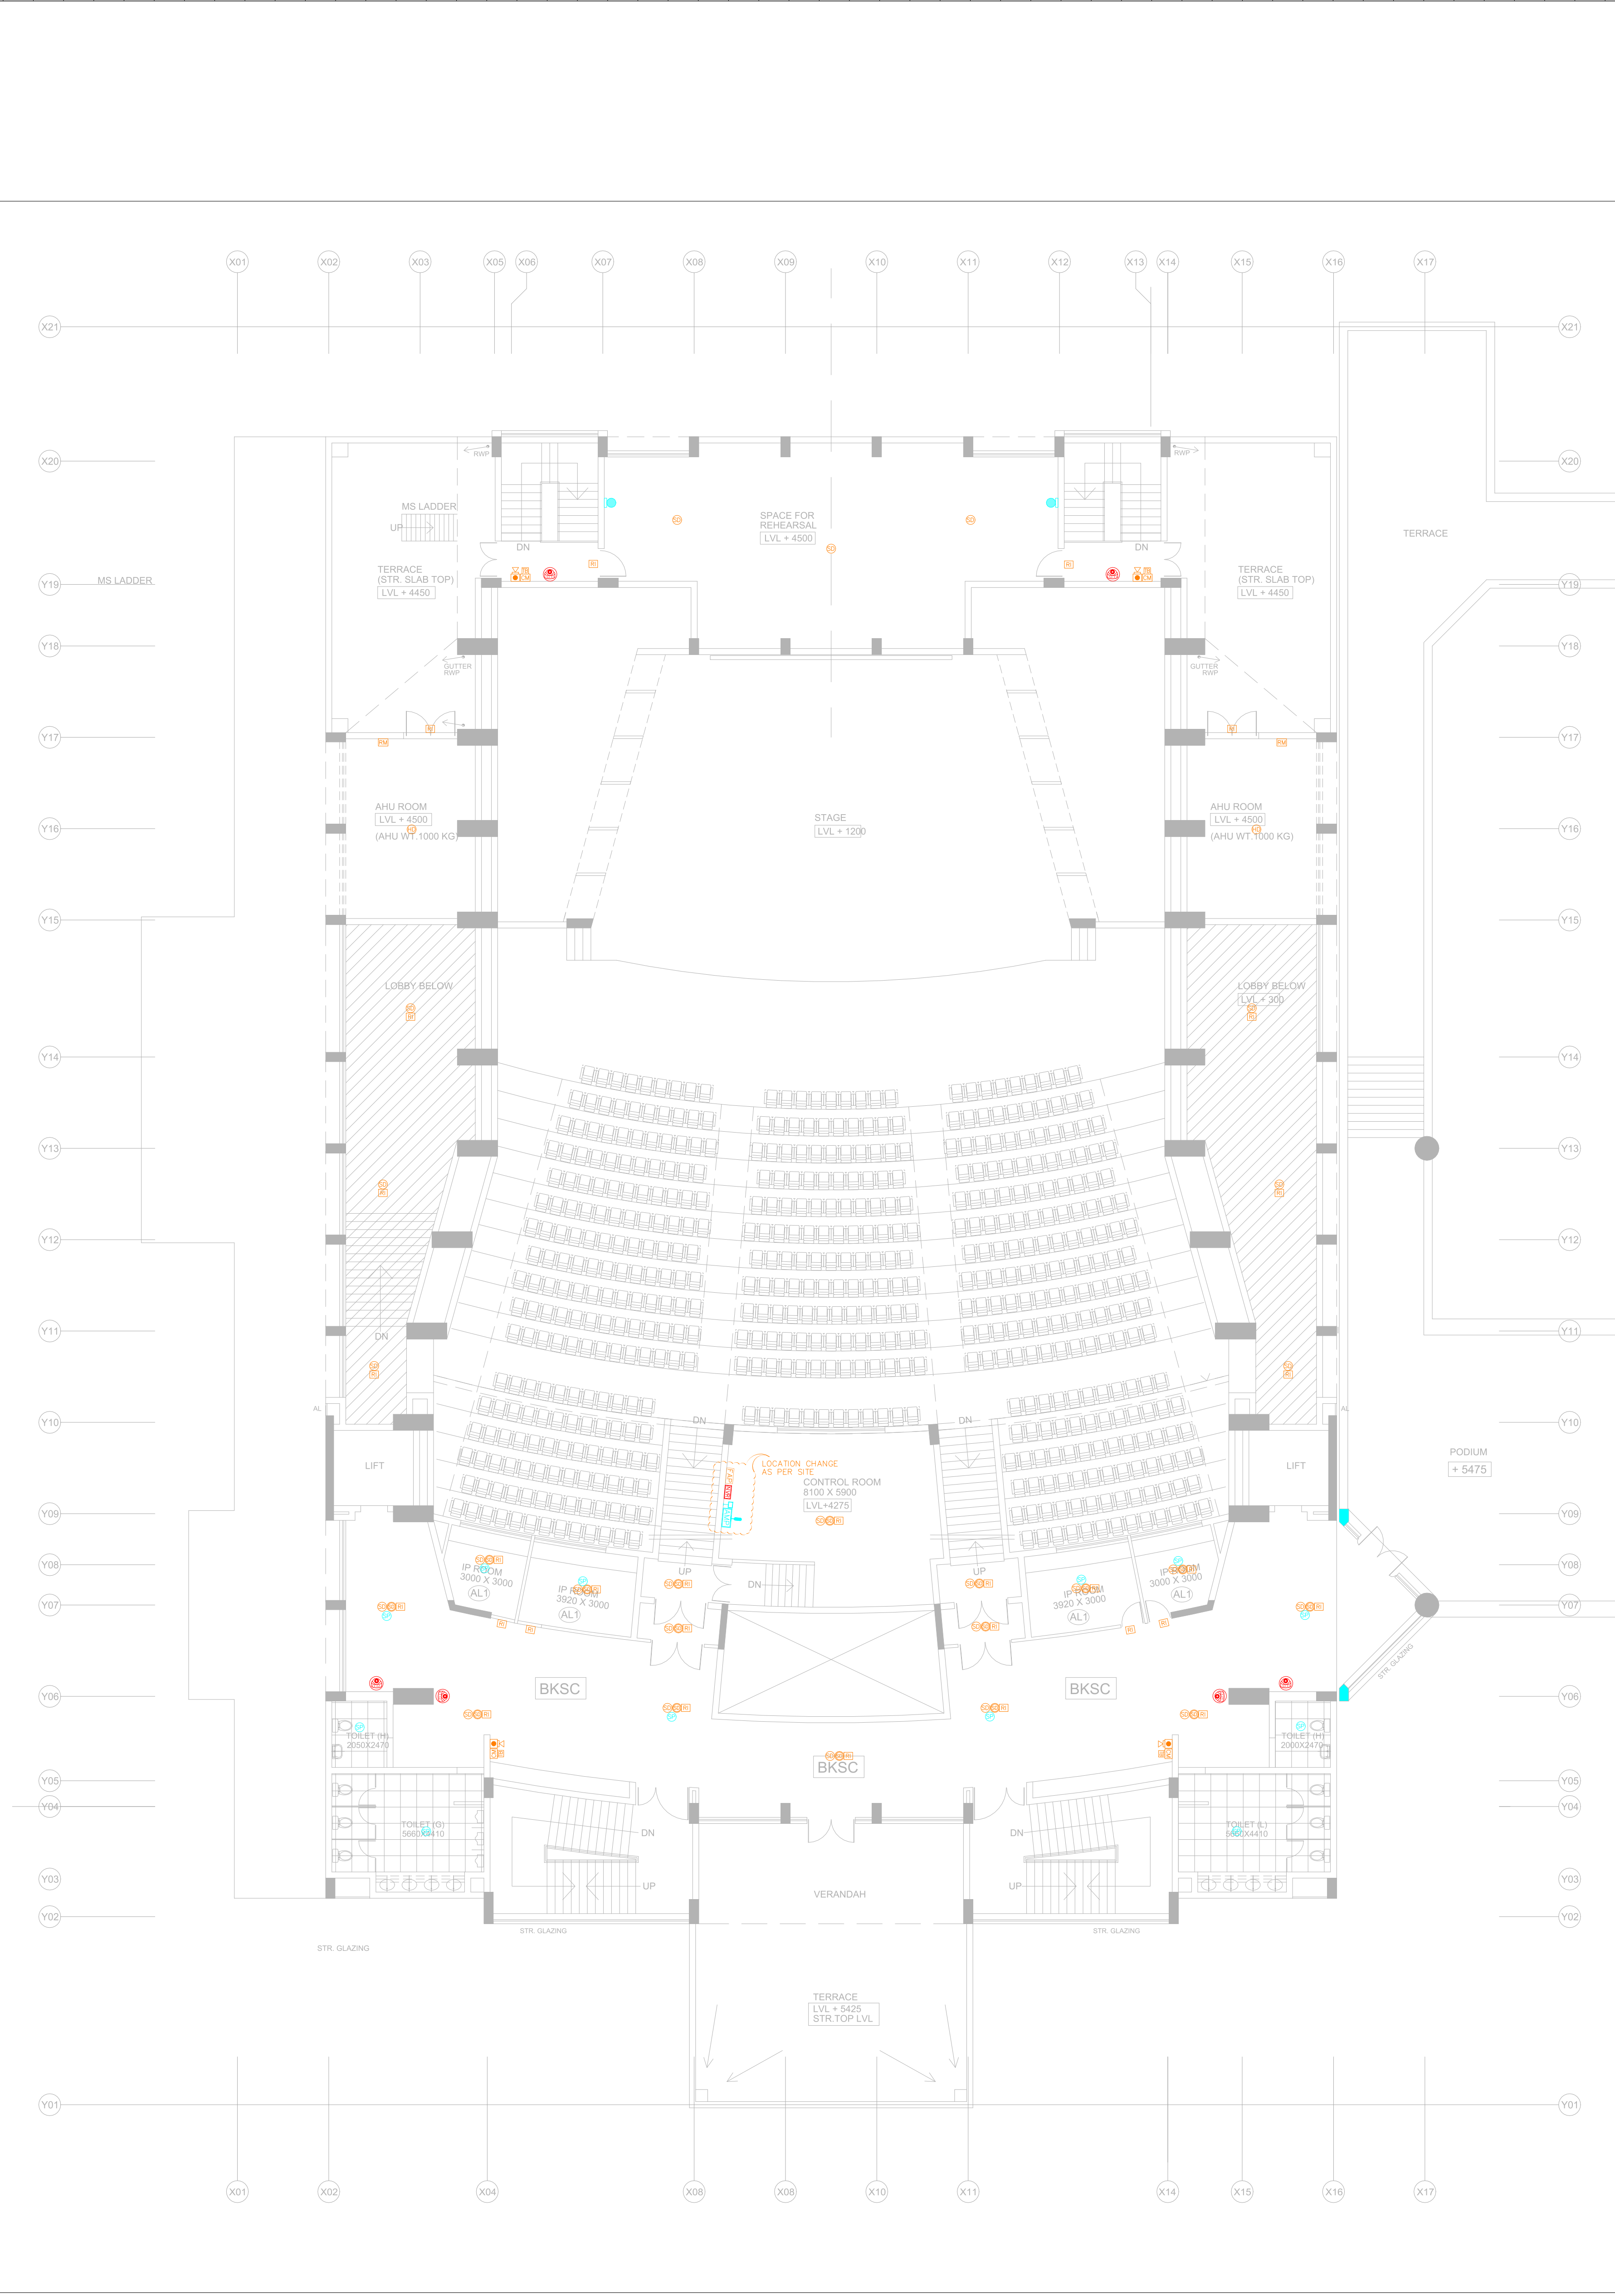

S.NO. LEGENDS TABLE FIRE ALARM SYSTEM	
01.	FIRE ALARM CONTROL PANEL
02.	SMOKE DETECTOR ON FALSE CEILING
03.	SMOKE DETECTOR ON SLAB
04.	HEAT DETECTOR ON SLAB
05.	MANUAL CALL POINT DEVICE
06.	RESPONSE INDICATOR
07.	HOOTER CUM STROBE
08.	CONTROL MODULE DEVICE
09.	MONITOR MODULE DEVICE @FHC's SHAFT
10.	FAULT ISOLATOR DEVICE AS PER LOOP @250m
11.	RELAY MODULE DEVICE
12.	BEAM DETECTOR
13.	BEAM RECEIVER
14.	TALK BACK DEVICE

S.NO. LEGENDS TABLE CCTV SYSTEM	
01.	NETWORK VIDEO RECORDER AS PER SITE
02.	DOME CAMERA
03.	BULLET CAMERA
04.	PTZ CAMERA

S.NO. LEGENDS TABLE PUBLIC ADDRESS SYSTEM	
01.	AMPLIFIER UNIT
02.	CEILING MOUNTED SPEAKER
03.	WALL MOUNTED SPEAKER
04.	MICROPHONE
05.	VOLUME CONTROLLER

PROJECT NAME
IIM SHILLONG, UMSAWLI CAMPUS SHILLONG


ARCHITECT
AKSHAYA JAIN & ASSOCIATES
ARCHITECTURE. PLANNING. INTERIOR DESIGN
C-6 / 6098, VASANT KUNJ, NEW DELHI - 110070
TELEPHONES +91-11-26136098, 26132304, 41601615
FAX +91-11-26132304 E-Mail : mail@okshayajain.com

ELECTRICAL SERVICES CONSULTANT
ECMS INDIA PVT. LTD.
WP-21 C-282, BASEMENT
NOIDA SECTOR-71,
UTTAR PRADESH-201307
E-mail: ecms.tech01@gmail.com
URL: www.ecmsindia.com
Ph.No. 0120-3502815

DRAWING TITLE-
EL- FAS, PAS & CCTV LAYOUT (PLAN LEVEL -2)
CONVENTION CENTRE (SITE - 10)-AUDI

<input type="checkbox"/> FOR APPROVAL	<input type="checkbox"/> ADVANCE COPY
<input checked="" type="checkbox"/> TENDER DRAWING	<input type="checkbox"/> GOOD FOR CONSTRUCTION

DRAWN BY	MIHIR	REV NO.	RO(25.06.2025)
CKD BY	YASHI	SCALE	1:180(A2)
FIN. YEAR	2024-25	JOB NO.	2516
DRAWING NO.	IIM/ECMS/CON./CENTRE/AUDI/LVL -2/FAS/PAS/CCTV-03		

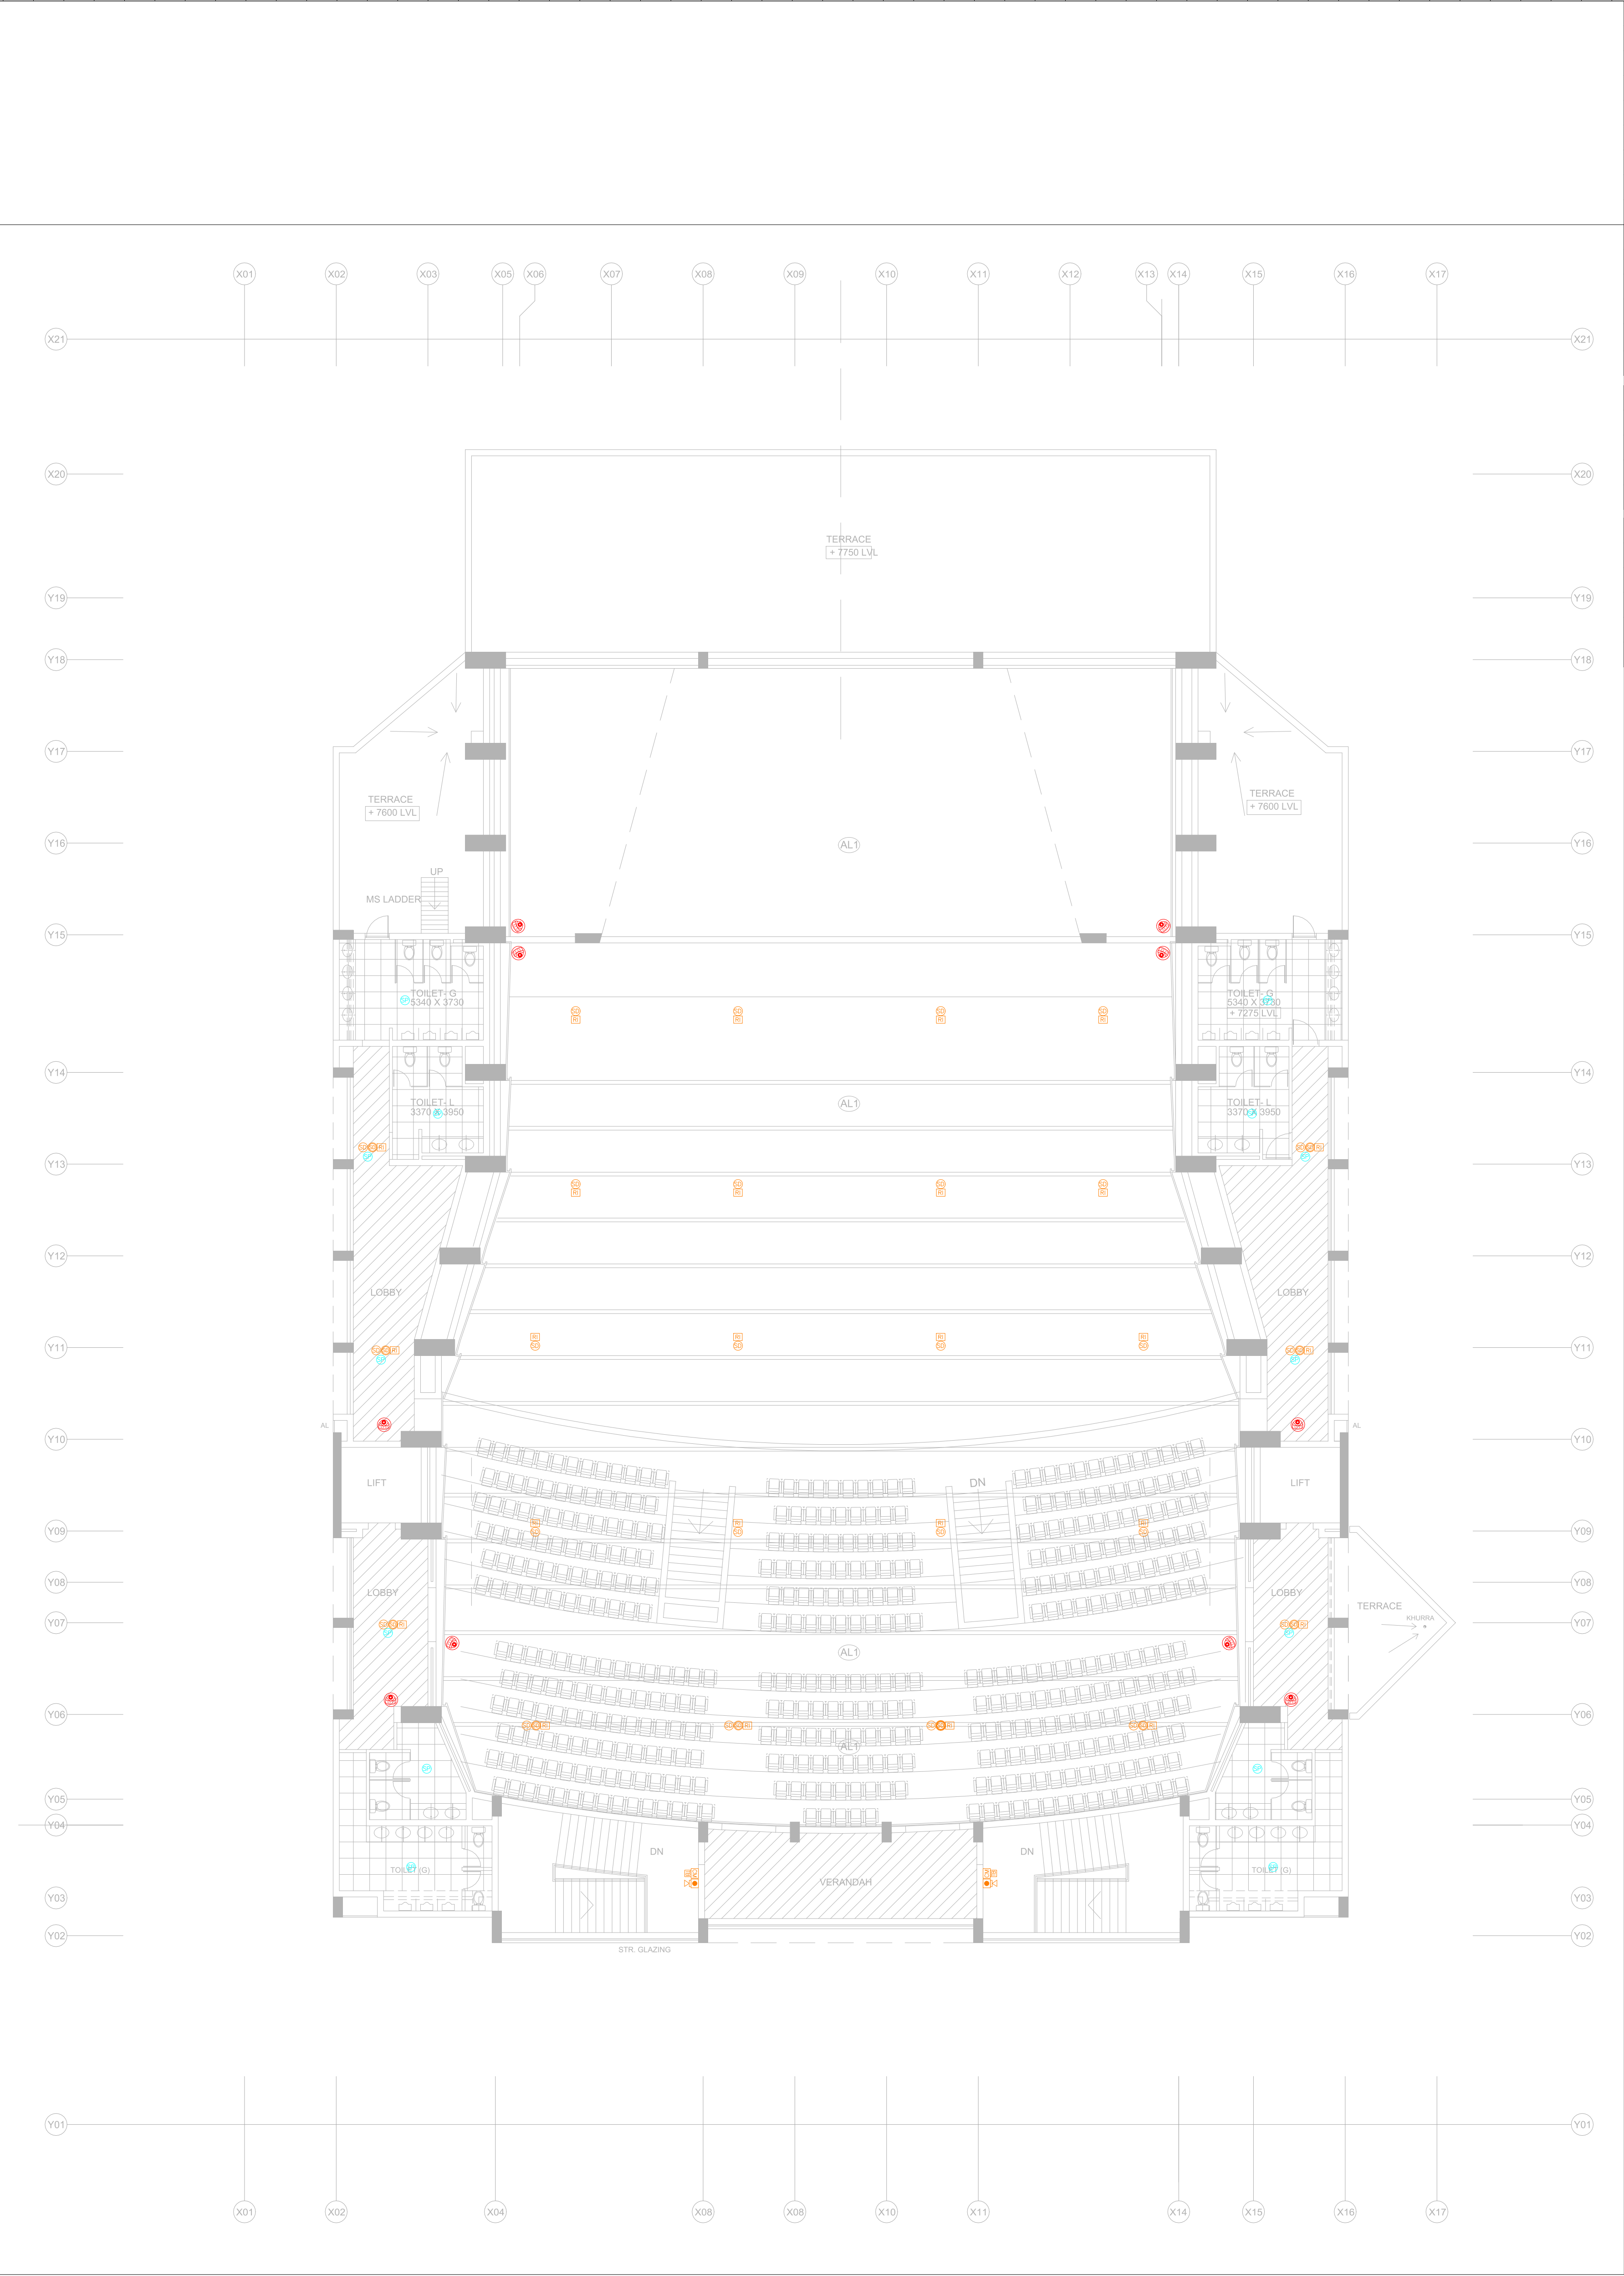

S.NO.	LEGENDS TABLE FIRE ALARM SYSTEM
01.	FAP FIRE ALARM CONTROL PANEL
02.	SD SMOKE DETECTOR ON FALSE CEILING
03.	SD SMOKE DETECTOR ON SLAB
04.	HD HEAT DETECTOR ON SLAB
05.	MANUAL CALL POINT DEVICE
06.	RI RESPONSE INDICATOR
07.	HOOTER CUM STROBE
08.	CM CONTROL MODULE DEVICE
09.	MM MONITOR MODULE DEVICE @FHC's SHAFT
10.	FI FAULT ISOLATOR DEVICE AS PER LOOP @25D
11.	RM RELAY MODULE DEVICE
12.	BD BEAM DETECTOR
13.	BR BEAM RECEIVER
14.	TB TALK BACK DEVICE

S.NO.	LEGENDS TABLE CCTV SYSTEM
01.	NVR NETWORK VIDEO RECORDER AS PER SITE
02.	DC DOME CAMERA
03.	BC BULLET CAMERA
04.	PTZ CAMERA

S.NO.	LEGENDS TABLE PUBLIC ADDRESS SYSTEM
01.	AMP AMPLIFIER UNIT
02.	SP CEILING MOUNTED SPEAKER
03.	WS WALL MOUNTED SPEAKER
04.	MC MICROPHONE
05.	VC VOLUME CONTROLLER

PROJECT NAME
IIM SHILLONG, UMSAWLI CAMPUS SHILLONG


ARCHITECT
AKSHAYA JAIN & ASSOCIATES
ARCHITECTURE. PLANNING. INTERIOR DESIGN
C-6 / 6098, VASANT KUNJ, NEW DELHI - 110070
TELEPHONES +91-11-26136098, 26132304, 41601615
FAX +91-11-26132304 E-Mail : mail@okshayajain.com

ELECTRICAL SERVICES CONSULTANT
ECMS INDIA PVT. LTD.
WP-21 C-282, BASEMENT
NOIDA SECTOR-71,
UTTAR PRADESH-201307
E-mail: ecms.tech01@gmail.com
URL: www.ecmsindia.com
Ph.No. 0120-3502815

DRAWING TITLE-
EL- FAS, PAS & CCTV LAYOUT (PLAN LEVEL -3)
CONVENTION CENTRE (SITE - 10)-AUDI

<input type="checkbox"/> FOR APPROVAL	<input type="checkbox"/> ADVANCE COPY
<input checked="" type="checkbox"/> TENDER DRAWING	<input type="checkbox"/> GOOD FOR CONSTRUCTION

DRAWN BY	MIHIR	REV NO.	RO(25.06.2025)
CKD BY	YASHI	SCALE	1:180(A2)
FIN. YEAR	2024-25	JOB NO.	2516
DRAWING NO.	IIM/ECMS/CON./CENTRE/AUDI/LVL-3/FAS/PAS/CCTV-04		

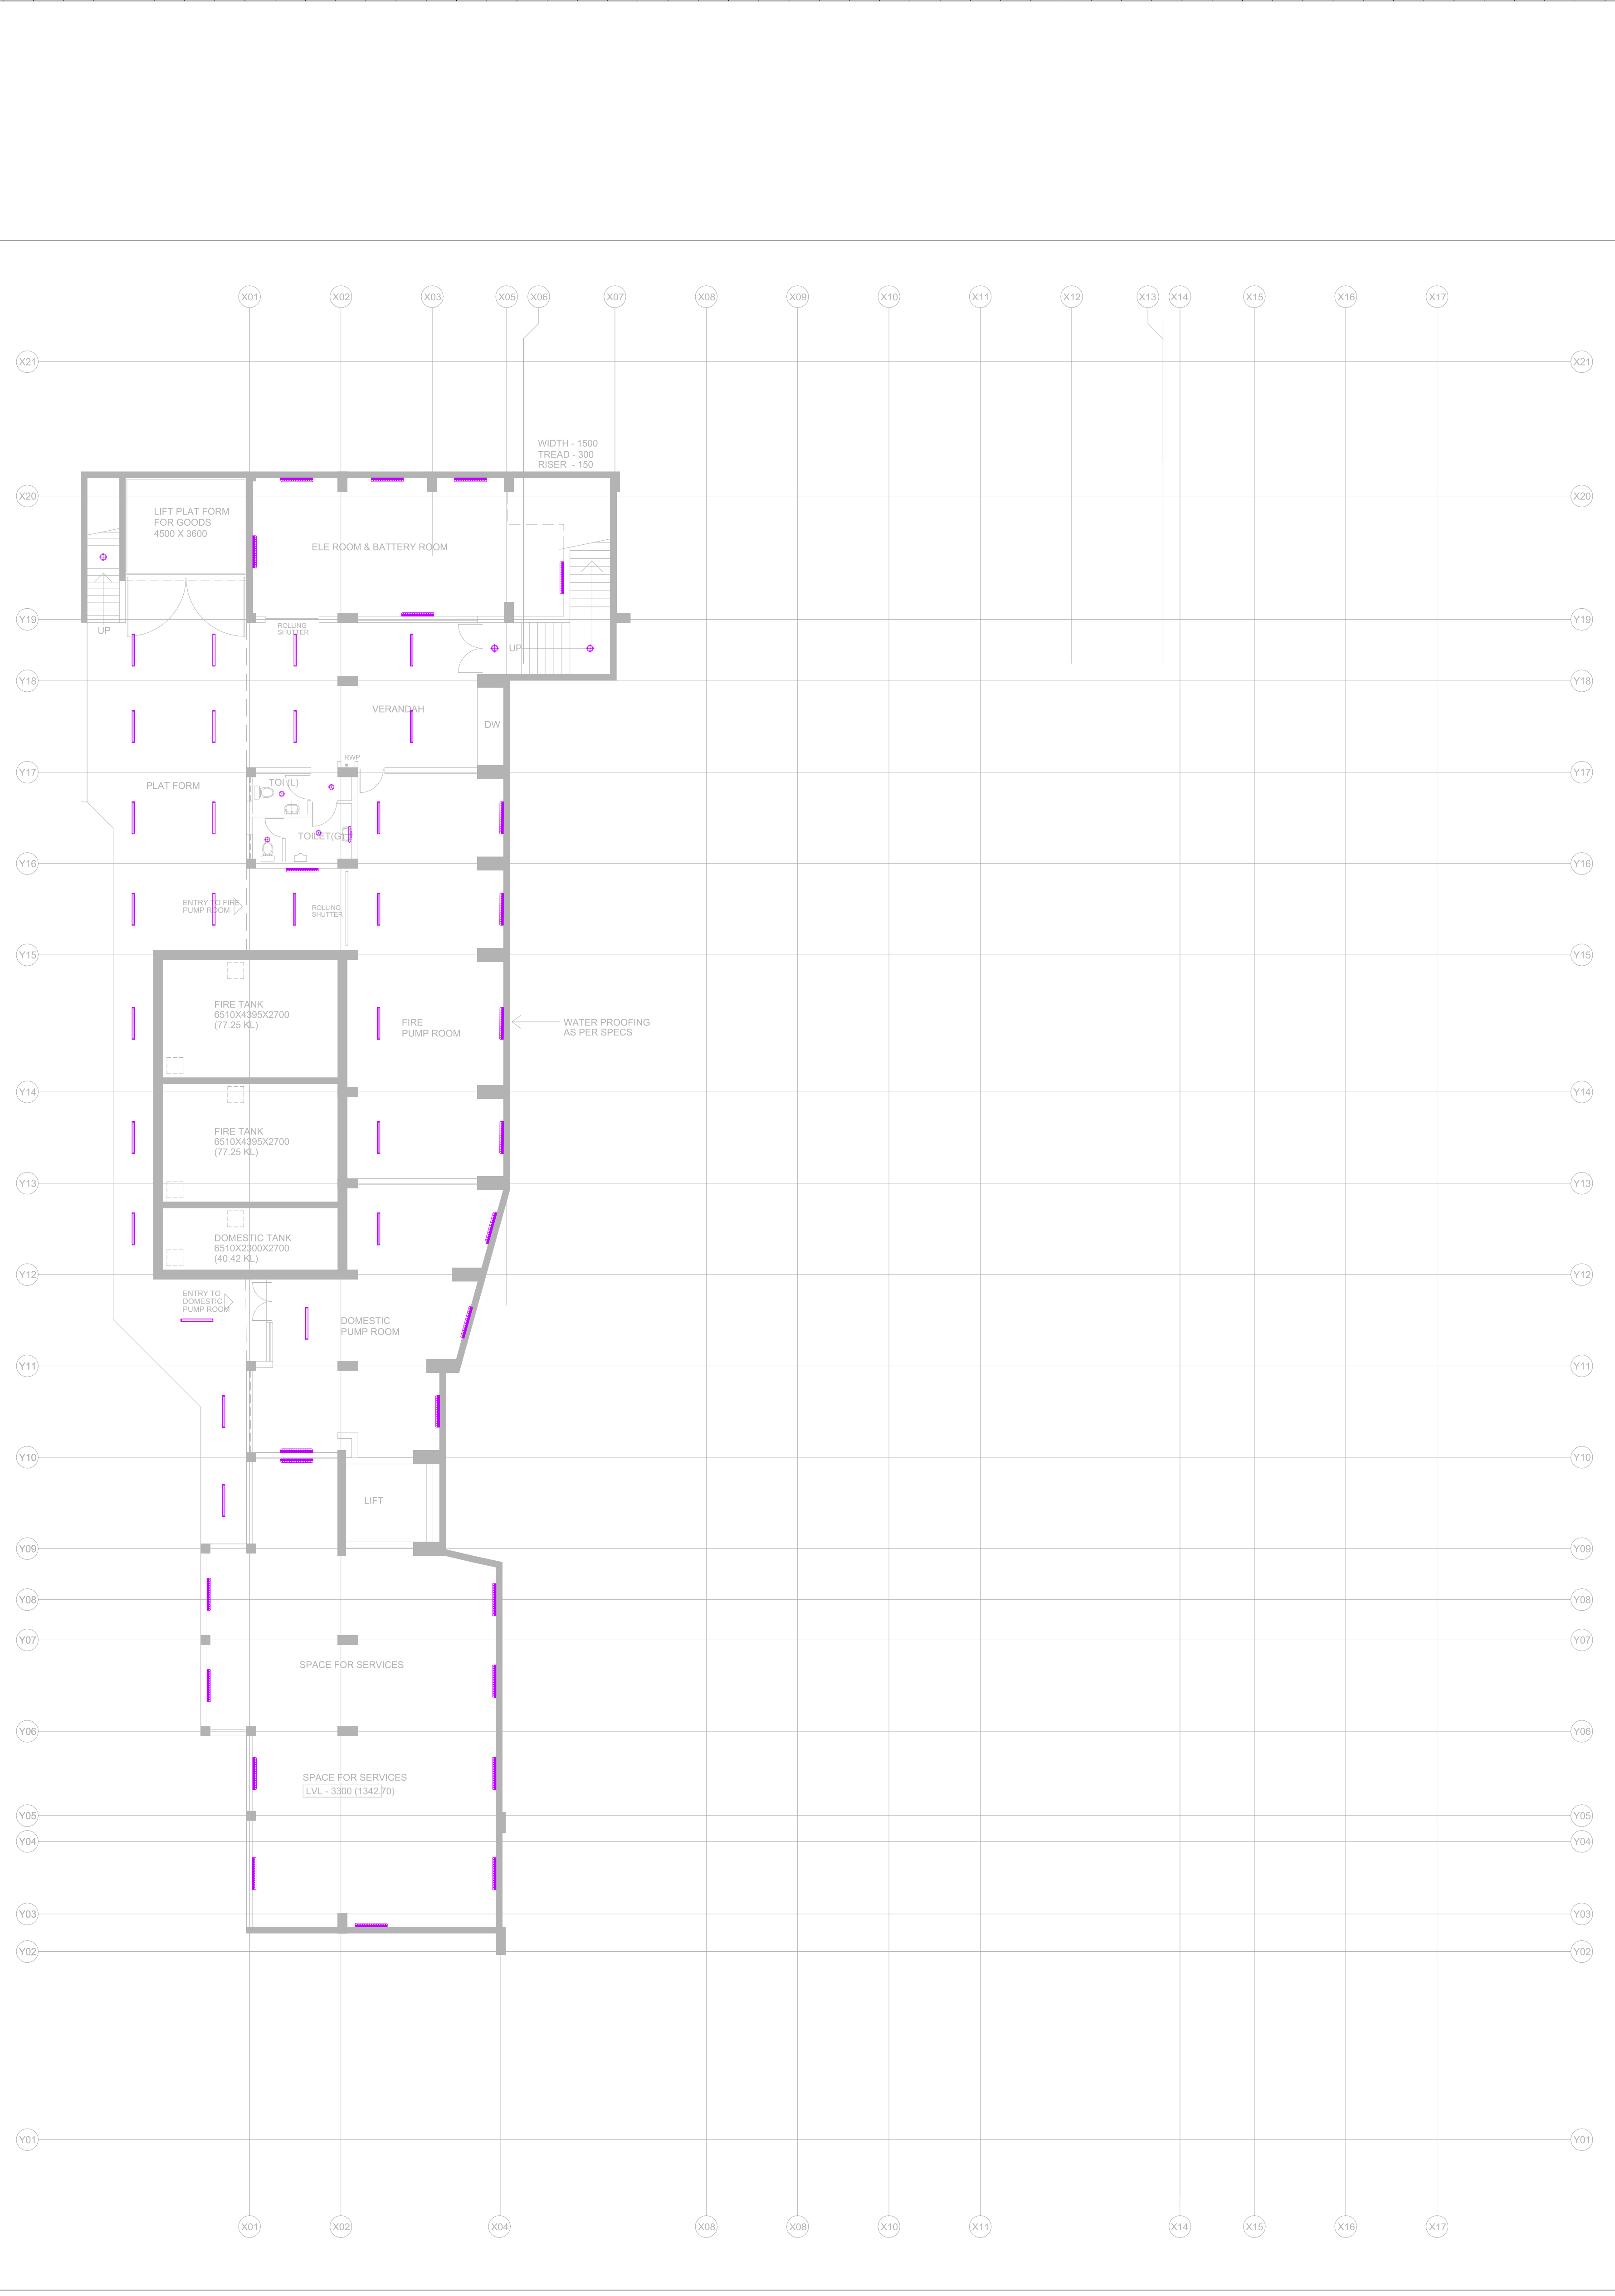

S.NO. LEGENDS TABLE		
01.		LED CEILING DOWNLIGHT-1
02.		LED CEILING DOWNLIGHT-2
03.		LED CEILING DOWNLIGHT-3
04.		LED CEILING COVE LIGHT
05.		LED SURFACE MOUNTED BATTEN LIGHT
06.		LED MIRROR LIGHT
07.		BULK HEAD LIGHT
08.		1200MMØ CEILING FAN


PROJECT NAME

IIM SHILLONG, UMSAWLI CAMPUS SHILLONG

ARCHITECT

AKSHAYA JAIN & ASSOCIATES
ARCHITECTURE. PLANNING. INTERIOR DESIGN
C-6 / 6098, VASANT KUNJ, NEW DELHI - 110070
TELEPHONES +91-11-26136098, 26132304, 41601615
FAX +91-11-26132304 E-Mail : mail@akshayajain.com

ELECTRICAL SERVICES CONSULTANT




ECMS INDIA PVT. LTD.
WP-21 C-282, BASEMENT
NOIDA SECTOR-71,
UTTAR PRADESH-201307
E-mail: ecms.tech01@gmail.com
URL: www.ecmsindia.com
Ph.No. 0120-3502815

DRAWING TITLE-

EL-LIGHTING LAYOUT (BASEMENT PLAN)
CONVENTION CENTRE (SITE - 10)-AUDI

<input type="checkbox"/> FOR APPROVAL	<input type="checkbox"/> ADVANCE COPY
<input checked="" type="checkbox"/> TENDER DRAWING	<input type="checkbox"/> GOOD FOR CONSTRUCTION


DRAWN BY	MIHIR	REV NO.	RO(25.06.2025)
CKD BY	YASHI	SCALE	1:180(A2)
FIN. YEAR	2024-25	JOB NO.	2516
DRAWING NO.	IIM/ECMS/CON./CENTRE/AUDI/BASE./EL/L-01		

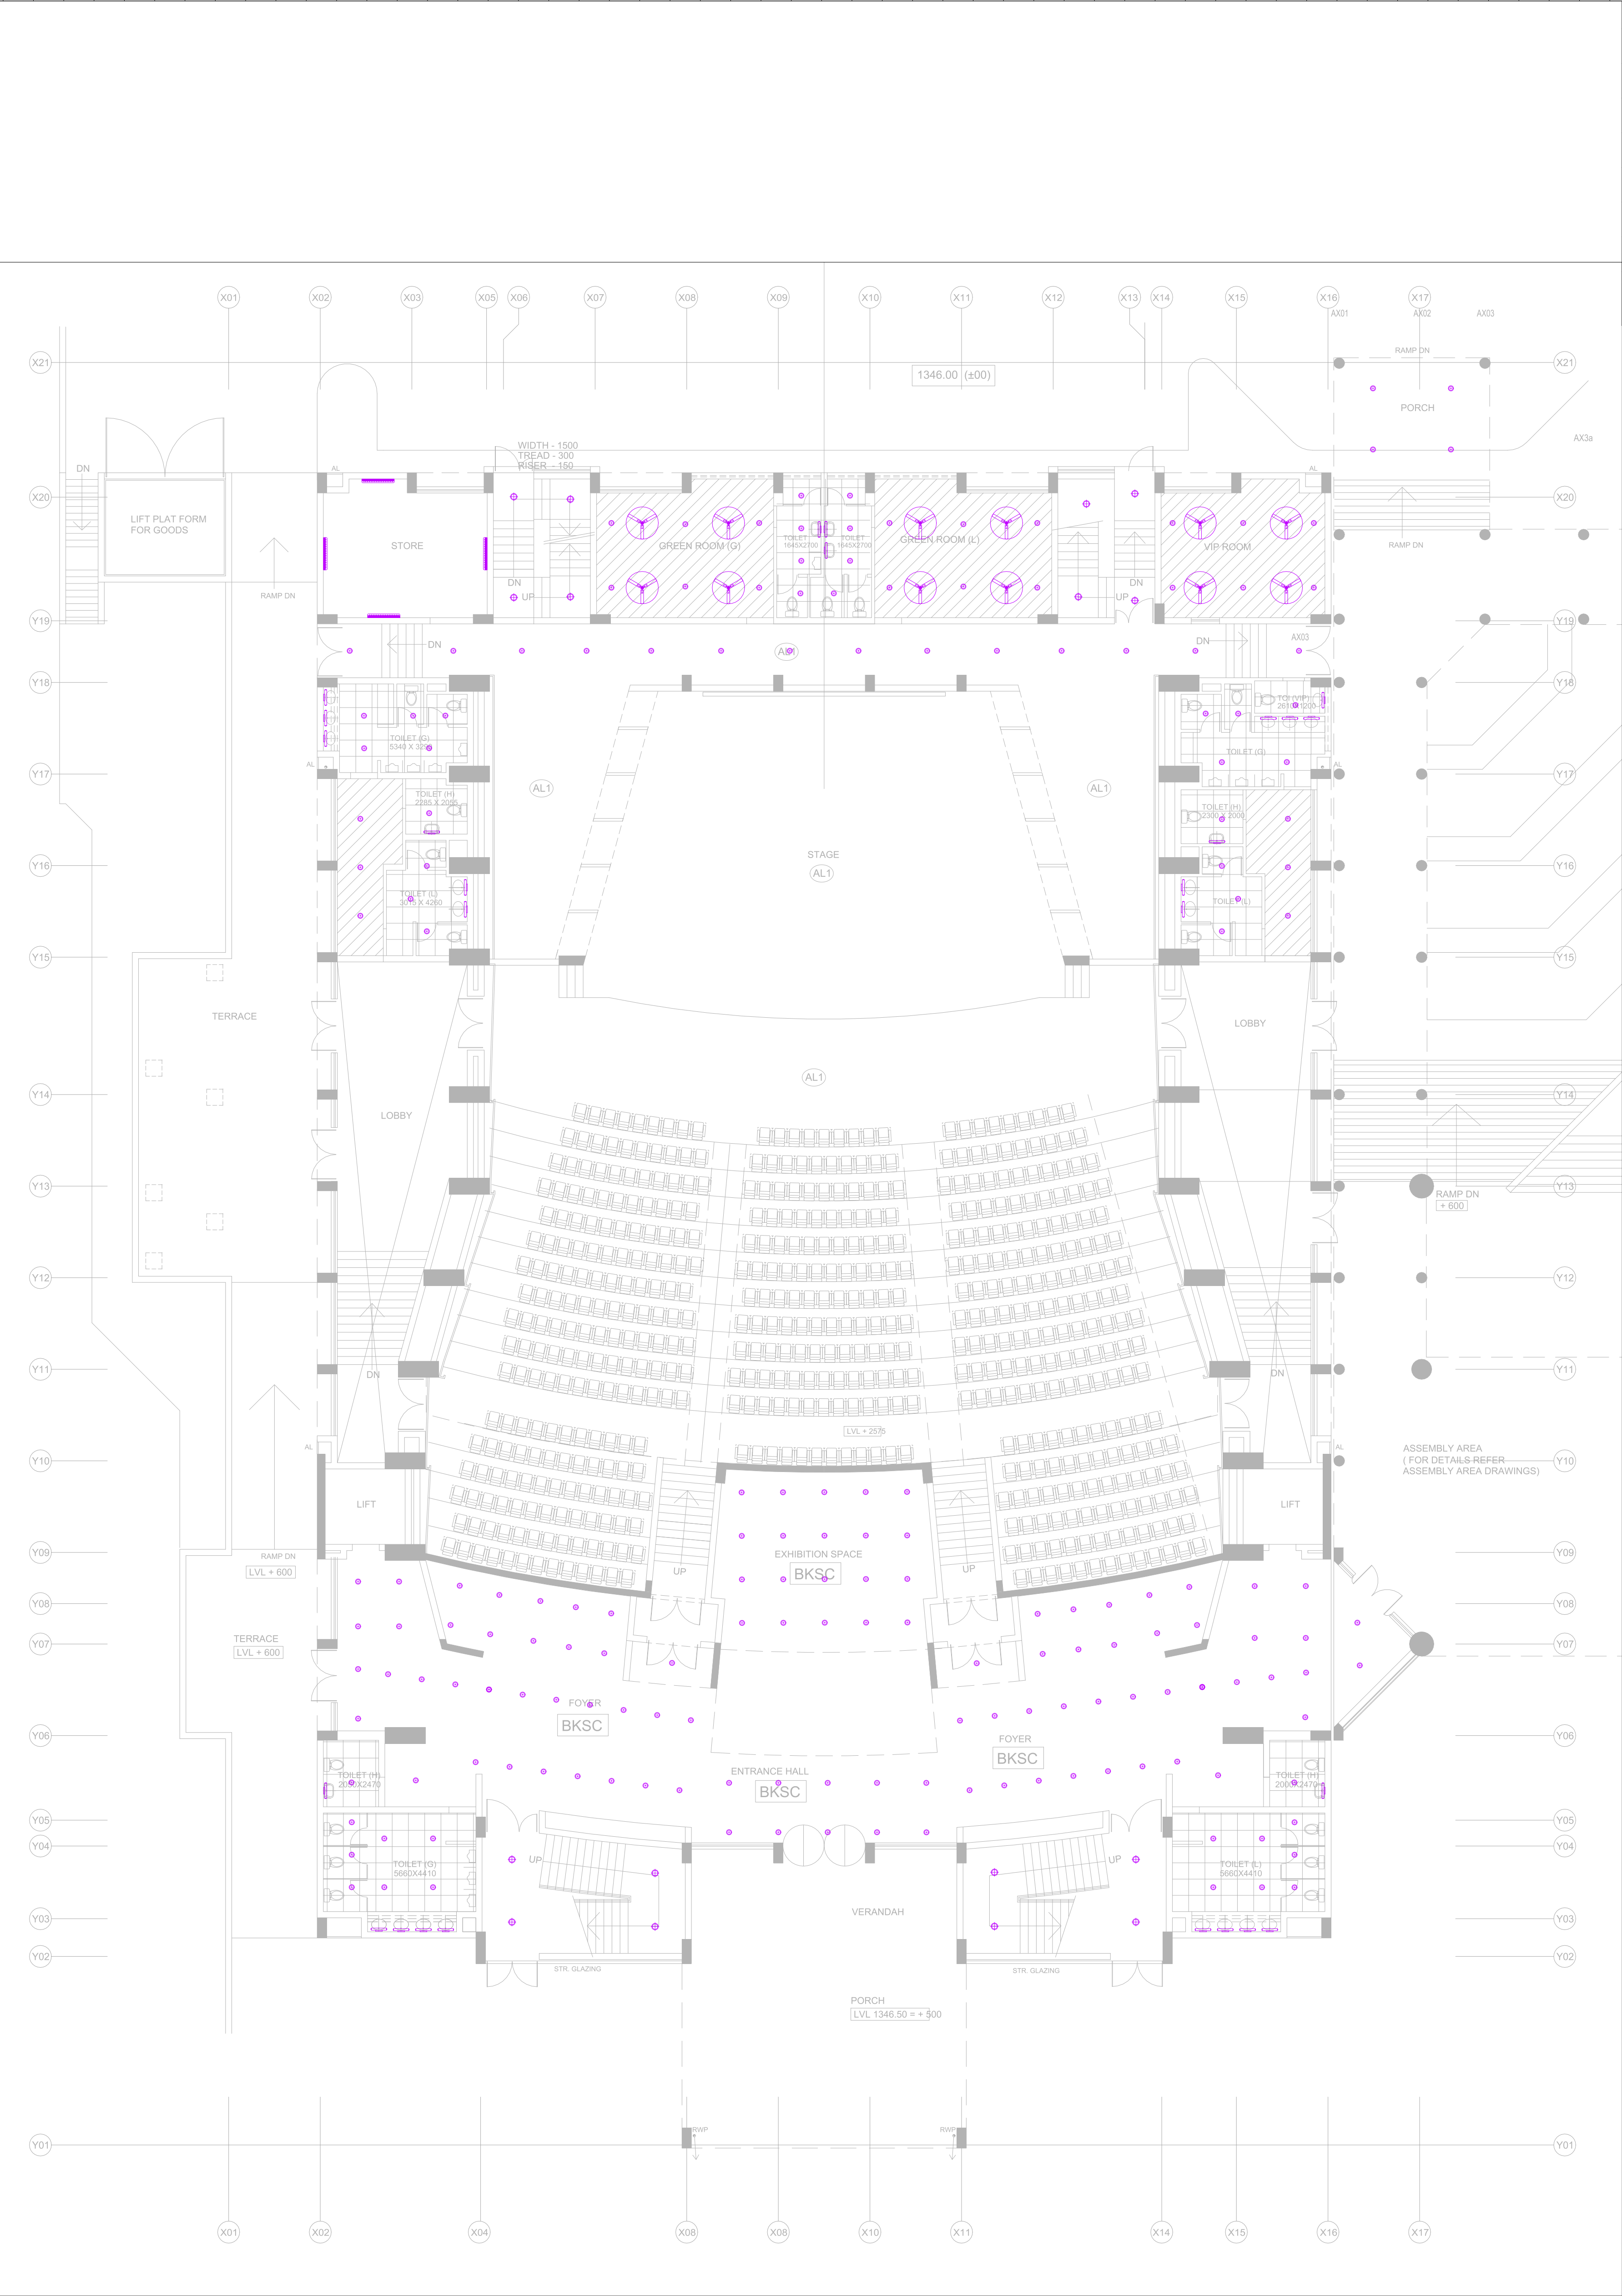

S.NO.	LEGENDS TABLE	
01.		LED CEILING DOWNLIGHT-1
02.		LED CEILING DOWNLIGHT-2
03.		LED CEILING DOWNLIGHT-3
04.		LED CEILING COVE LIGHT
05.		LED SURFACE MOUNTED BATTEN LIGHT
06.		LED MIRROR LIGHT
07.		BULK HEAD LIGHT
08.		1200MMØ CEILING FAN

PROJECT NAME
IIM SHILLONG, UMSAWLI CAMPUS SHILLONG


ARCHITECT
AKSHAYA JAIN & ASSOCIATES
ARCHITECTURE. PLANNING. INTERIOR DESIGN
C-6 / 6098, VASANT KUNJ, NEW DELHI - 110070
TELEPHONES +91-11-26136098, 26132304, 41601615
FAX +91-11-26132304 E-Mail : mail@okshayajain.com

ELECTRICAL SERVICES CONSULTANT
**ECMS INDIA PVT. LTD.**
WP-21 C-282, BASEMENT
NOIDA SECTOR-71,
UTTAR PRADESH-201307
E-mail: ecms.tech01@gmail.com
URL: www.ecmsindia.com
Ph.No. 0120-3502815

DRAWING TITLE-
EL-LIGHTING LAYOUT (PLAN LEVEL -1)
CONVENTION CENTRE (SITE - 10)-AUDI

	FOR APPROVAL		ADVANCE COPY
	TENDER DRAWING		GOOD FOR CONSTRUCTION

DRAWN BY	MIHIR	REV NO.	R0(25.06.2025)
CKD BY	YASHI	SCALE	1:180(A2)
FIN. YEAR	2024-25	JOB NO.	2516
DRAWING NO.	IIM/ECMS/CON./CENTRE/AUDI/LVL-1/EL/L-02		

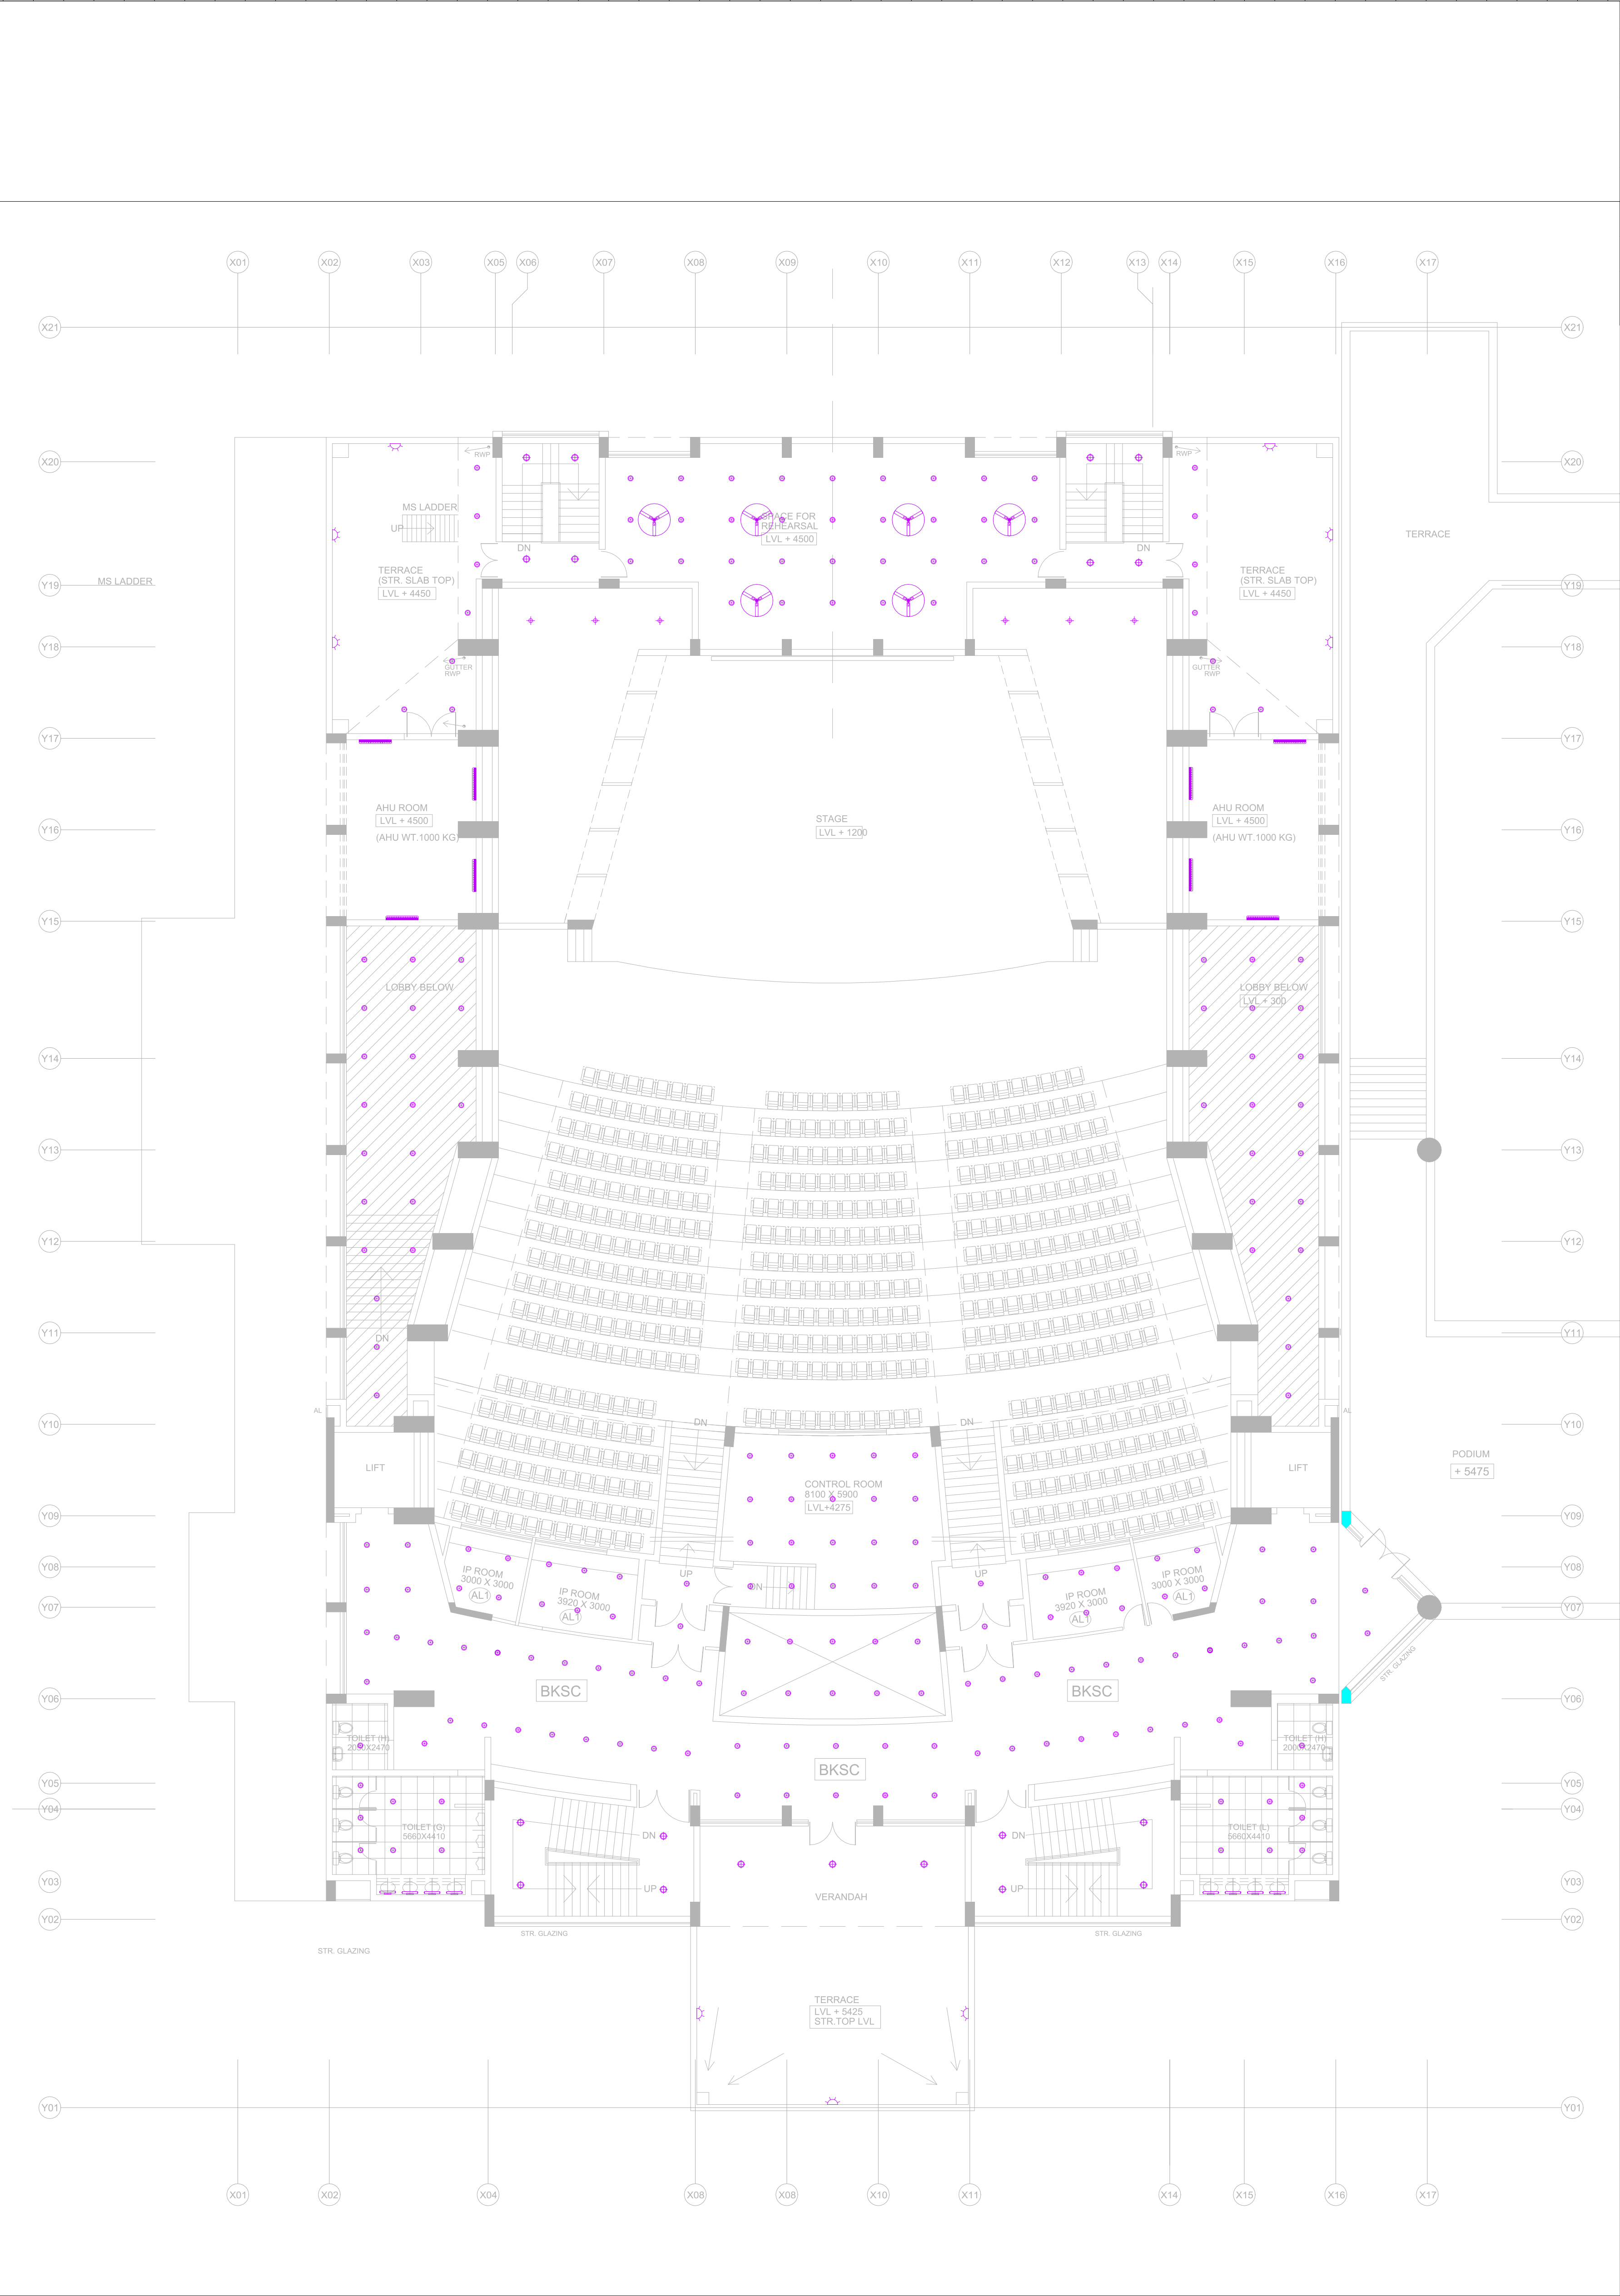

S.NO.	LEGENDS TABLE	
01.		LED CEILING DOWNLIGHT-1
02.		LED CEILING DOWNLIGHT-2
03.		LED CEILING DOWNLIGHT-3
04.		LED CEILING COVE LIGHT
05.		LED SURFACE MOUNTED BATTEN LIGHT
06.		LED MIRROR LIGHT
07.		BULK HEAD LIGHT
08.		1200MMØ CEILING FAN

PROJECT NAME
IIM SHILLONG, UMSAWLI CAMPUS SHILLONG


ARCHITECT
AKSHAYA JAIN & ASSOCIATES
ARCHITECTURE. PLANNING. INTERIOR DESIGN
C-6 / 6098, VASANT KUNJ, NEW DELHI - 110070
TELEPHONES +91-11-26136098, 26132304, 41601615
FAX +91-11-26132304 E-Mail : mail@akshayajain.com

ELECTRICAL SERVICES CONSULTANT
**ECMS INDIA PVT. LTD.**
WP-21 C-282, BASEMENT
NOIDA SECTOR-71,
UTTAR PRADESH-201307
E-mail: ecms.tech01@gmail.com
URL: www.ecmsindia.com
Ph.No. 0120-3502815

DRAWING TITLE-
EL-LIGHTING LAYOUT (PLAN LEVEL -2)
CONVENTION CENTRE (SITE - 10)-AUDI

<input type="checkbox"/> FOR APPROVAL	<input type="checkbox"/> ADVANCE COPY
<input checked="" type="checkbox"/> TENDER DRAWING	<input type="checkbox"/> GOOD FOR CONSTRUCTION

DRAWN BY	MIHIR	REV NO.	R0(25.06.2025)
CKD BY	YASHI	SCALE	1:180(A2)
FIN. YEAR	2024-25	JOB NO.	2516
DRAWING NO.	IIM/ECMS/CON./CENTRE/AUDI/LVL.-2/EL/L-03		

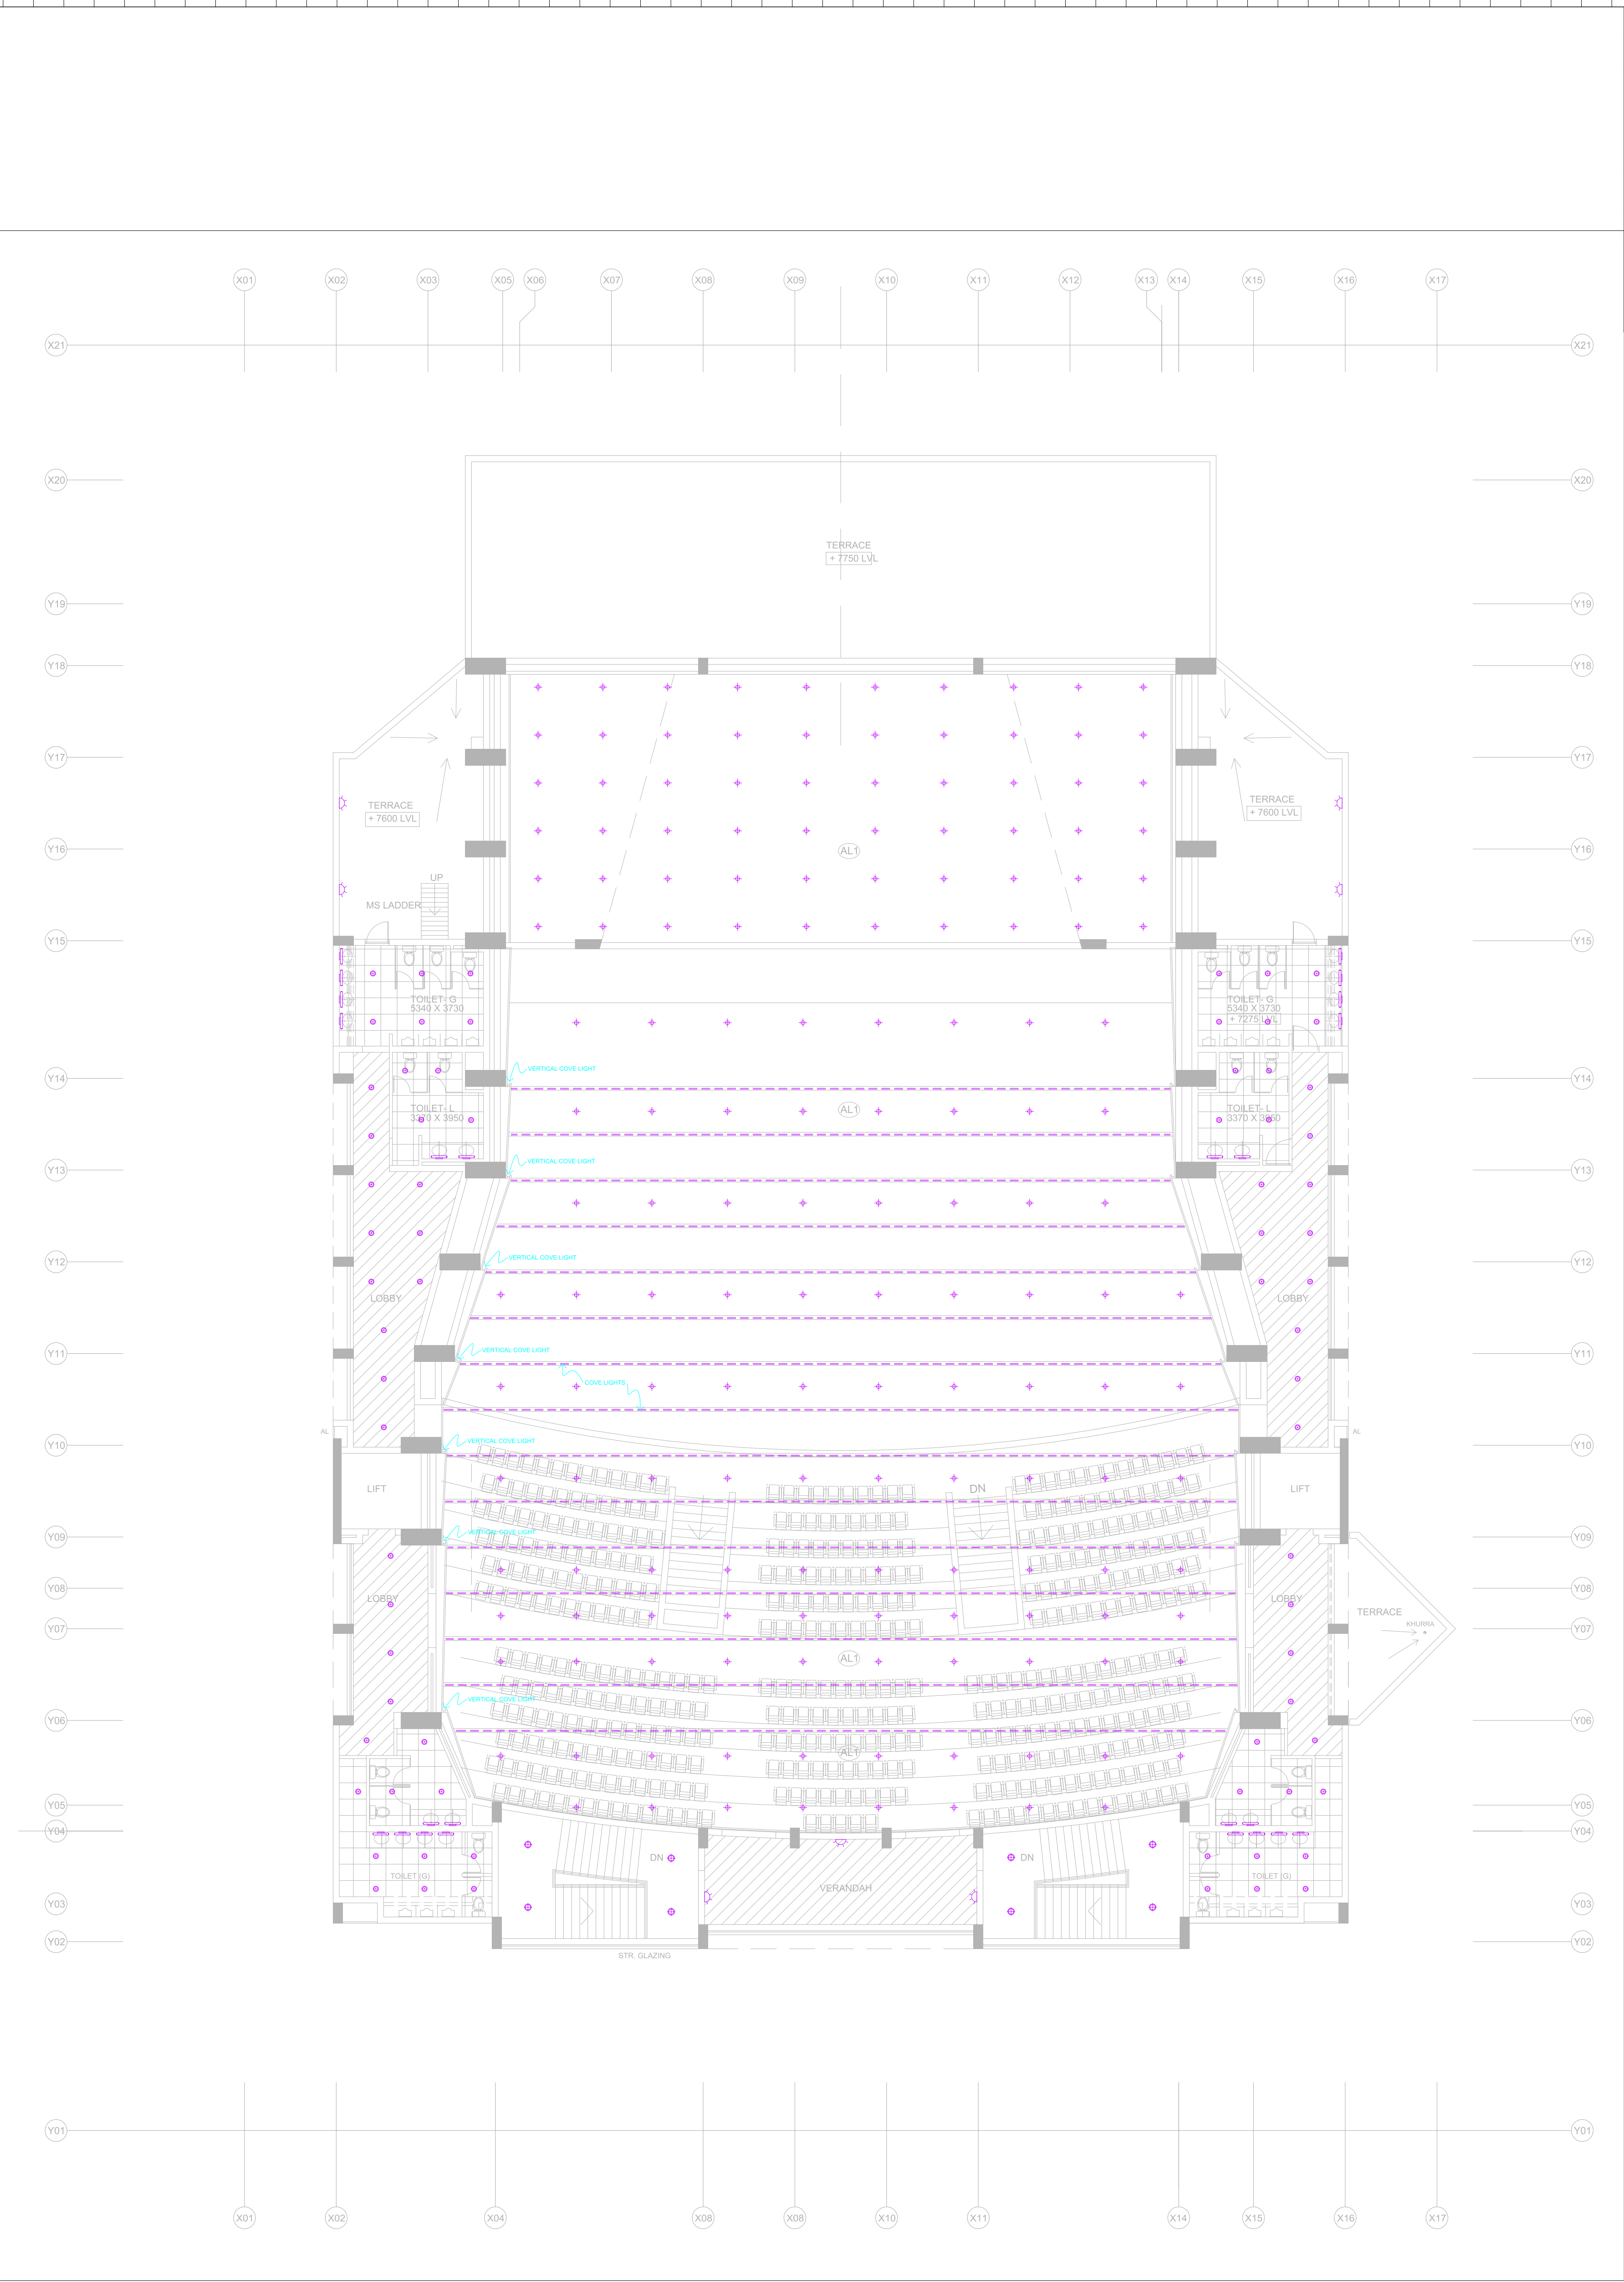

S.NO.	LEGENDS TABLE	
01.		LED CEILING DOWNLIGHT-1
02.		LED CEILING DOWNLIGHT-2
03.		LED CEILING DOWNLIGHT-3
04.		LED CEILING COVE LIGHT
05.		LED SURFACE MOUNTED BATTEN LIGHT
06.		LED MIRROR LIGHT
07.		BULK HEAD LIGHT
08.		1200MMØ CEILING FAN


PROJECT NAME

IIM SHILLONG, UMSAWLI CAMPUS SHILLONG

ARCHITECT

AKSHAYA JAIN & ASSOCIATES
ARCHITECTURE. PLANNING. INTERIOR DESIGN
C-6 / 6098, VASANT KUNJ, NEW DELHI - 110070
TELEPHONES +91-11-26136098, 26132304, 41601615
FAX +91-11-26132304 E-Mail : mail@okshayajain.com

ELECTRICAL SERVICES CONSULTANT

**ECMS INDIA PVT. LTD.**
WP-21 C-282, BASEMENT
NOIDA SECTOR-71,
UTTAR PRADESH-201307
E-mail: ecms.tech01@gmail.com
URL: www.ecmsindia.com
Ph.No. 0120-3502815


DRAWING TITLE-


EL-LIGHTING LAYOUT (PLAN LEVEL -3)
CONVENTION CENTRE (SITE - 10)-AUDI


<input type="checkbox"/> FOR APPROVAL	<input type="checkbox"/> ADVANCE COPY
<input checked="" type="checkbox"/> TENDER DRAWING	<input type="checkbox"/> GOOD FOR CONSTRUCTION


 
 




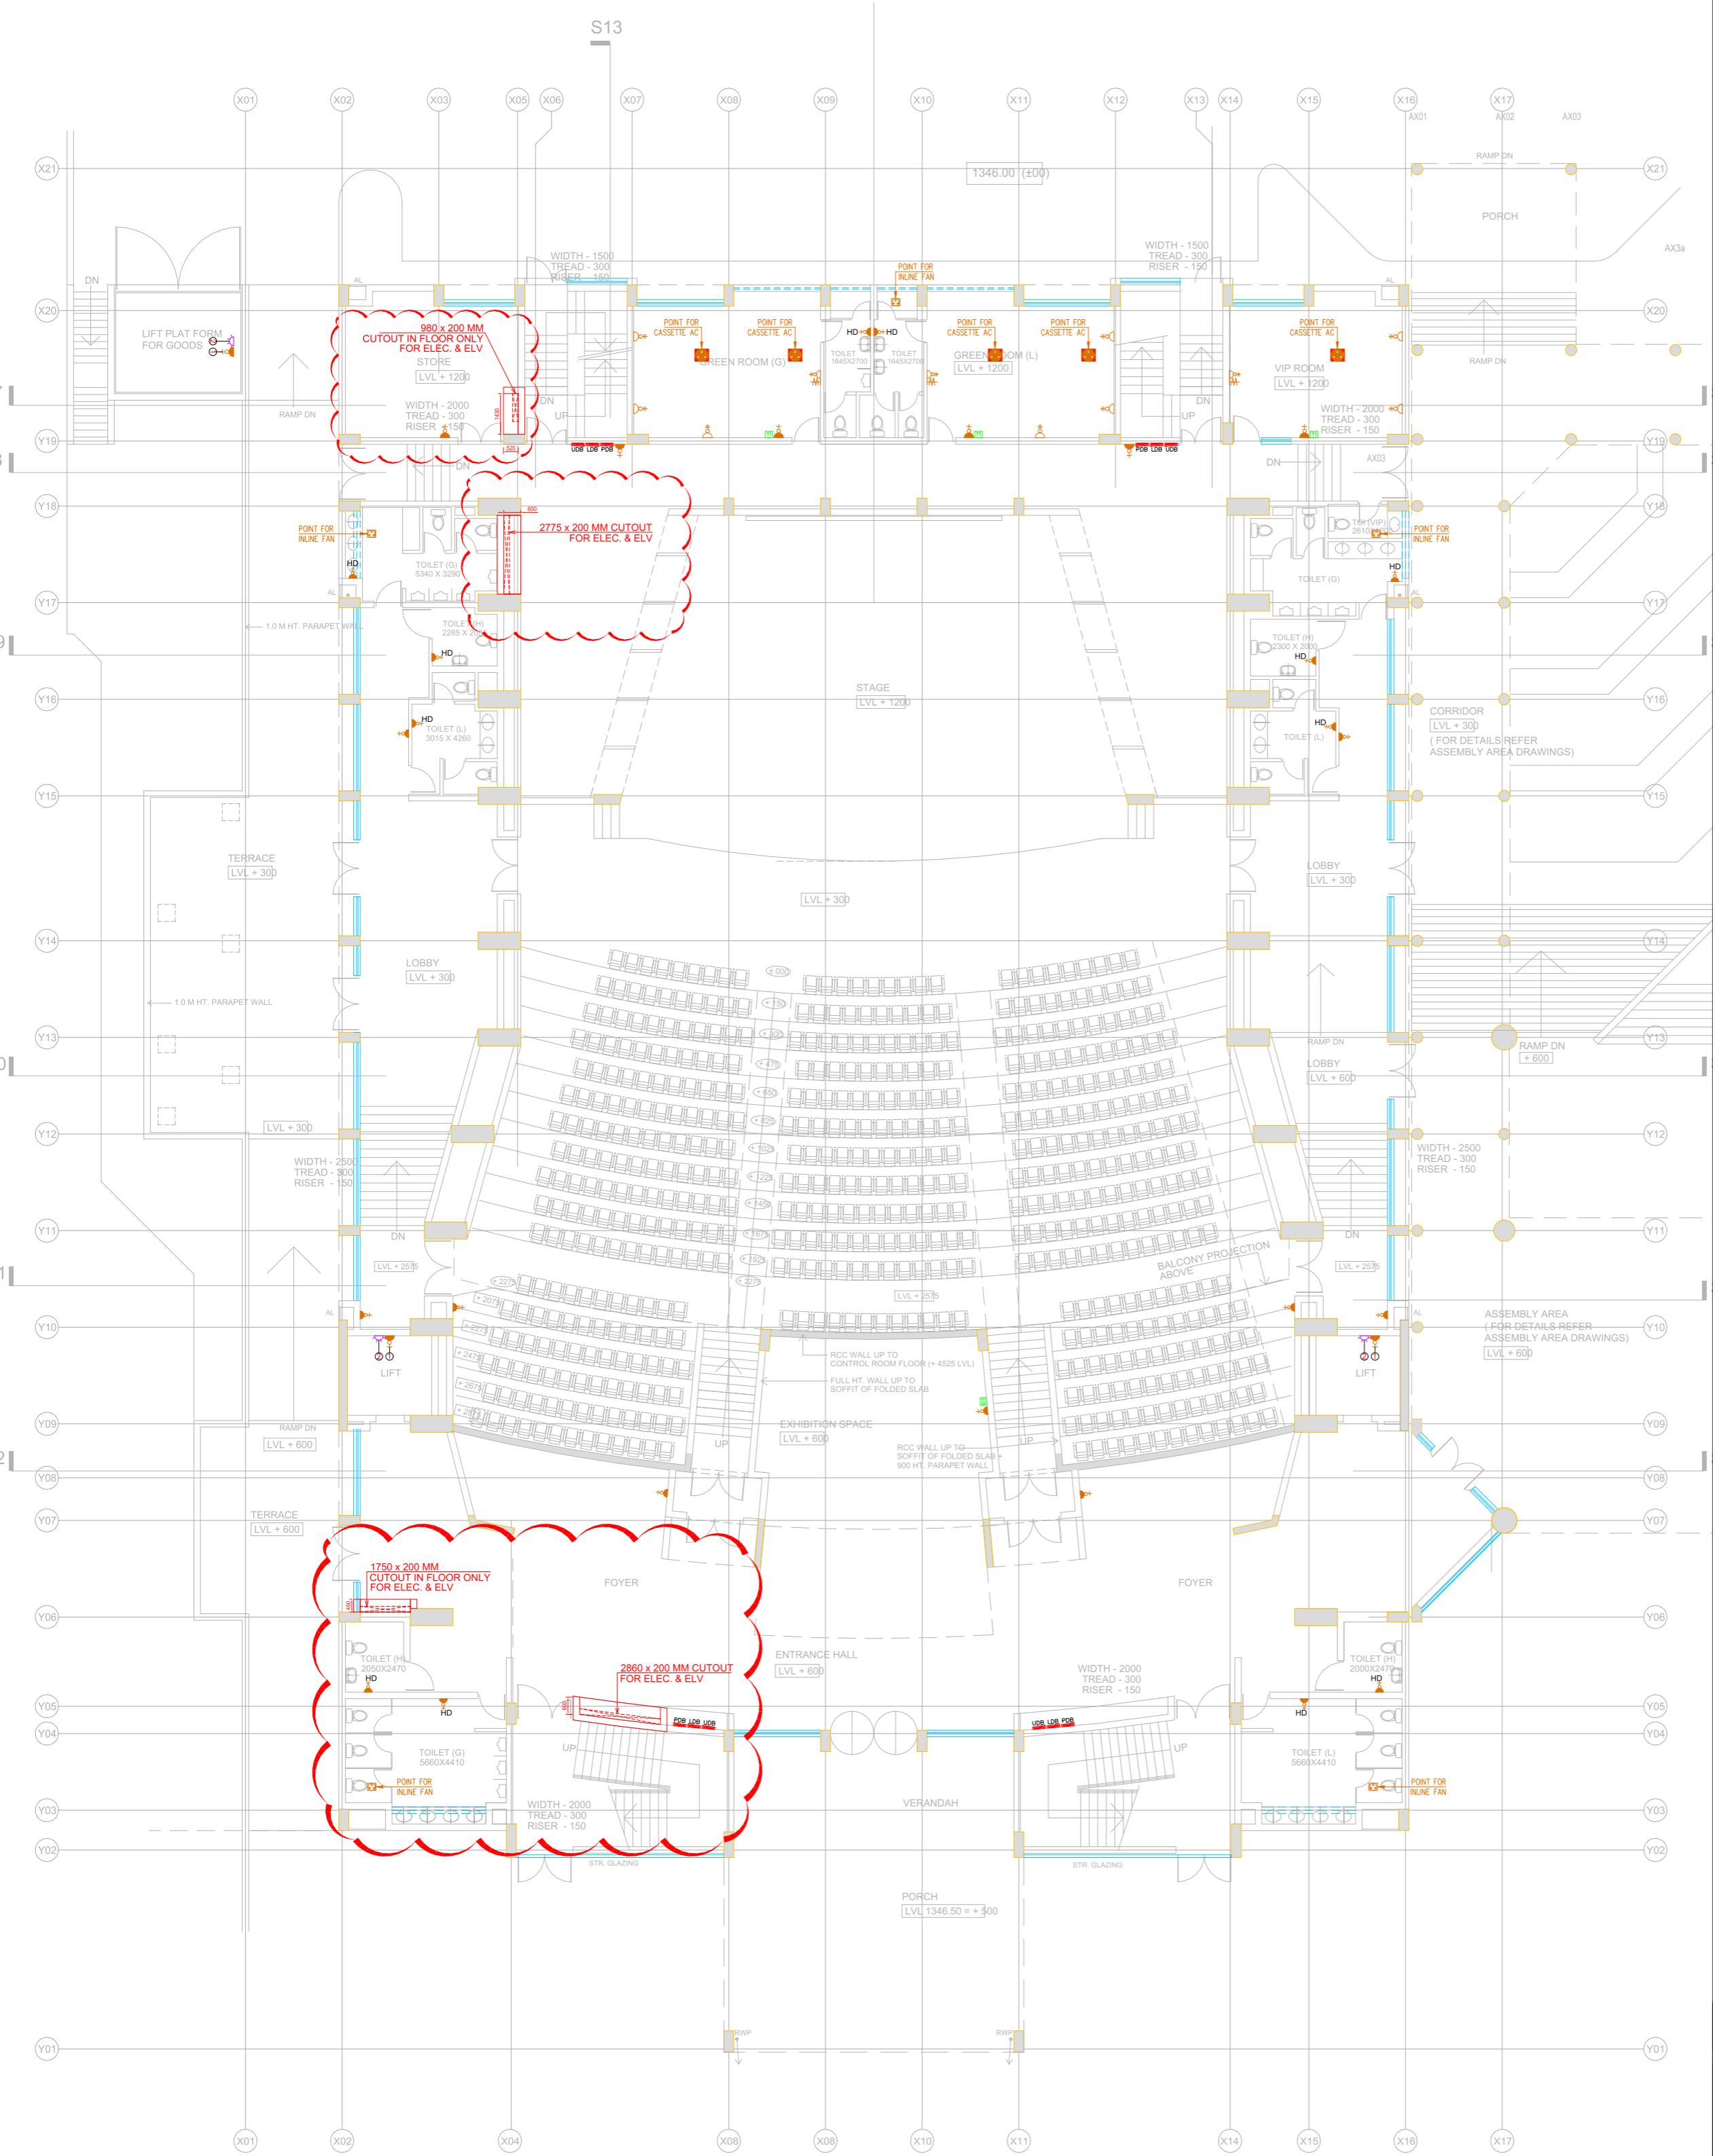


 
 
DRAWN BY	MIHIR	REV NO.	R0(25.06.2025)
CKD BY	YASHI	SCALE	1:180(A2)
FIN. YEAR	2024-25	JOB NO.	2516
DRAWING NO.	IIM/ECMS/CON./CENTRE/AUDI/LVL.-3/EL/L-04		

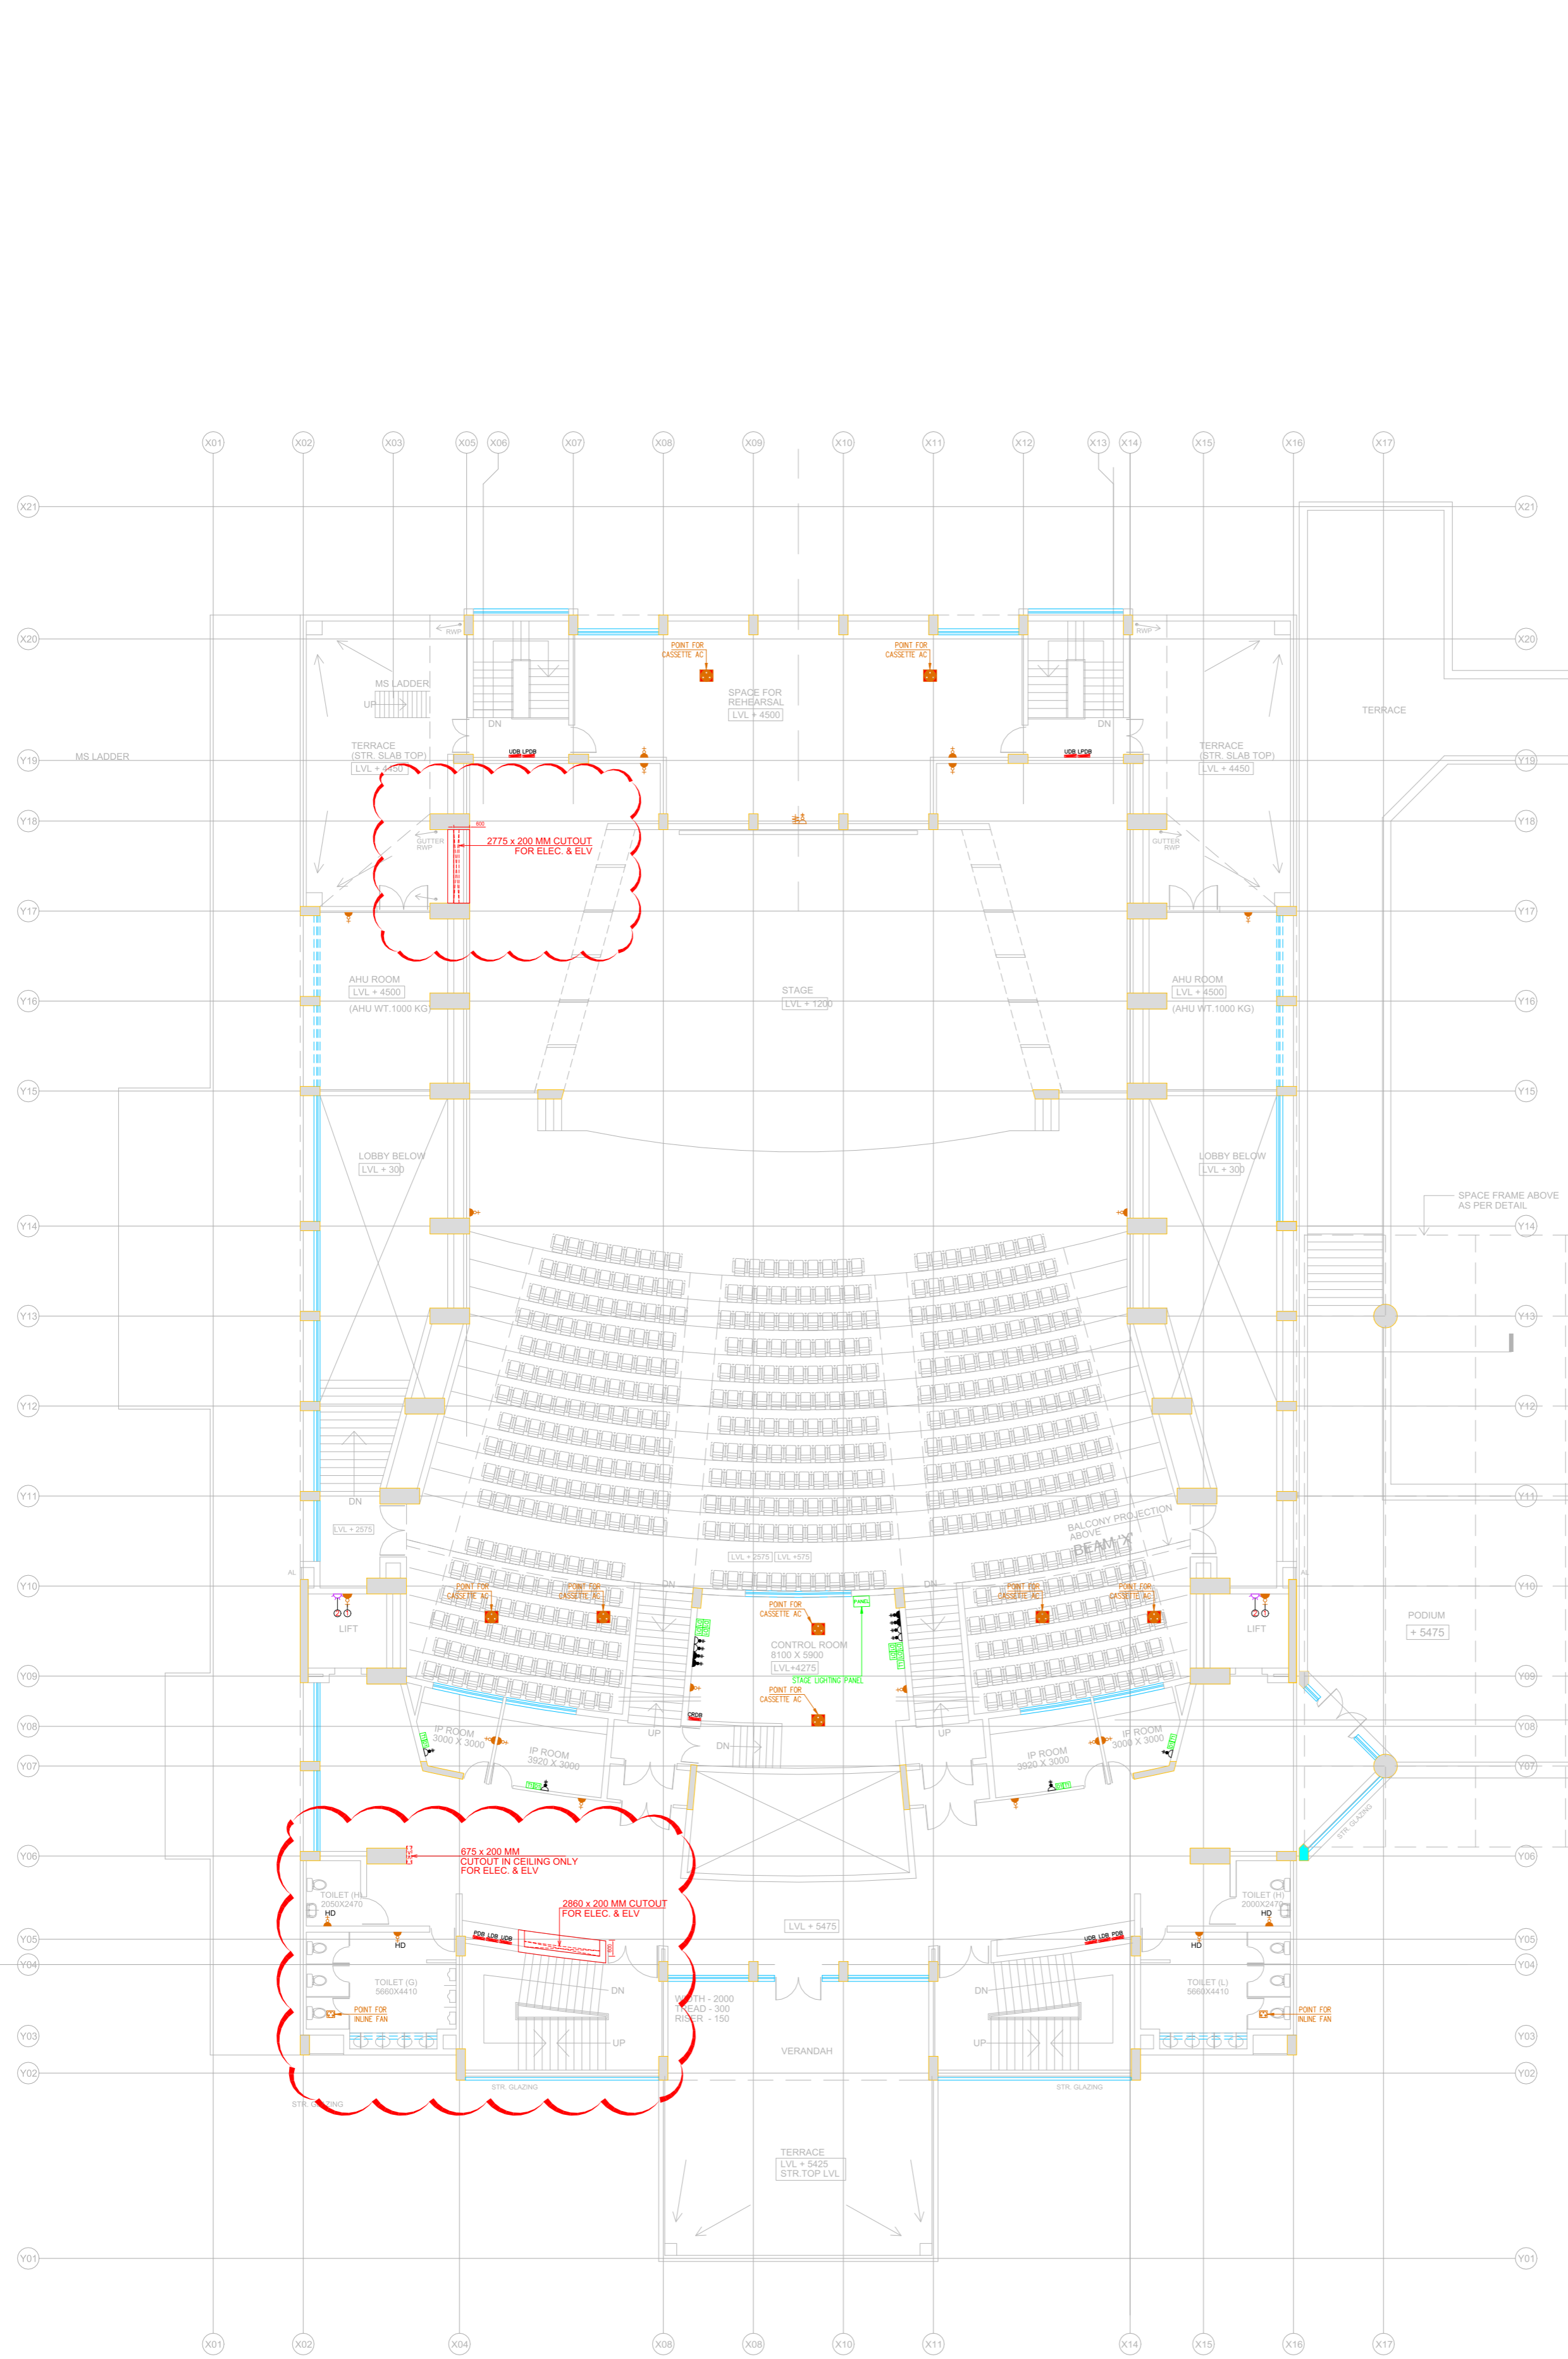S.NO.	LEGENDS	TABLE
01.		2 NOS. 6A (RAW) SOCKET & 2 NOS. 6A SWITCH
02.		1 NO. 16A SOCKET & 1 NO. 16A SWITCH
03.		1 NO. 16A SOCKET & 1 NO. 16A SWITCH FOR HAND DRYER
04.		1 NO. TELEVISION OUTLET
05.		1 NO. DATA OUTLET
06.		1 NO. TELEPHONE OUTLET
07.		2 NOS. 6A (UPS) SOCKET & 2 NOS. 6A SWITCH
08.		2 NOS. 6/16A (UPS) SOCKET & 2 NOS. 16A SWITCH
09.		1 NO. 16A SWITCH SOCKET IN CEILING FOR INLINE FAN
10.		1 NO. 16A SWITCH SOCKET IN CEILING FOR CASSETTE UNIT
LIFT LEGENDS		
	2 Nos. 25mm Ø PVC Conduit From Basement up to Terrace for 16A S.S.Outlet, Circuit From DB Location in Lift Machine Room.	
	1 No. 25mm Ø PVC Conduit From Basement up to Terrace for Bulk Head Light, Circuit From DB Location in Lift Machine Room.	
Note:-	In Every Lift Well, Give a 16A Switched Socket Outlet at Alternative Floor Starting From Basement till Terrace Floor and Bulkhead Light to be provided at each floor level.	



PROJECT NAME IIM SHILLONG, UMSAWLI CAMPUS SHILLONG	
ARCHITECT AKSHAYA JAIN & ASSOCIATES ARCHITECTURE. PLANNING. INTERIOR DESIGN C-6 / 6098, VASANT KUNJ, NEW DELHI - 110070 TELEPHONES +91-11-26136098, 26132304, 41601615 FAX +91-11-26132304 E-Mail : mail@akshayajain.com	
ELECTRICAL SERVICES CONSULTANT  ECMS INDIA PVT. LTD. WP-21 C-282, BASEMENT NODA SECTOR-71, UTTAR PRADESH-201307 E-mail: ecms.tech01@gmail.com URL: www.ecmsindia.com Ph.No. 0120-3502815	
DRAWING TITLE- EL-POWER LAYOUT (PLAN LEVEL -1) CONVENTION CENTRE (SITE - 10)-AUDI	
<input type="checkbox"/> FOR APPROVAL	<input type="checkbox"/> ADVANCE COPY
<input checked="" type="checkbox"/> TENDER DRAWING	<input type="checkbox"/> GOOD FOR CONSTRUCTION
DRAWN BY DEEPAK	REV NO. R0(25.06.2025)
CKD BY YASHI	SCALE 1:180(A2)
FIN. YEAR 2024-25	JOB NO. 2516
DRAWING NO.	IIM/ECMS/CON./CENTRE/AUDI/LVL.-1/PWR-02



S.NO.	LEGENDS	TABLE
01.		2 NOS. 6A (RAW) SOCKET & 2 NOS. 6A SWITCH
02.		1 NO. 16A SOCKET & 1 NO. 16A SWITCH
03.		1 NO. 16A SOCKET & 1 NO. 16A SWITCH FOR HAND DRYER
04.		1 NO. TELEVISION OUTLET
05.		1 NO. DATA OUTLET
06.		1 NO. TELEPHONE OUTLET
07.		2 NOS. 6A (UPS) SOCKET & 2 NOS. 6A SWITCH
08.		2 NOS. 6/16A (UPS) SOCKET & 2 NOS. 16A SWITCH
09.		1 NO. 16A SWITCH SOCKET IN CEILING FOR INLINE FAN
10.		1 NO. 16A SWITCH SOCKET IN CEILING FOR CASSETTE UNIT
LIFT LEGENDS		
	2 Nos. 25mm Ø PVC Conduit From Basement up to Terrace for 16A S.S.Outlet, Circuit From DB Location in Lift Machine Room.	
	1 No. 25mm Ø PVC Conduit From Basement up to Terrace for Bulk Head Light, Circuit From DB Location in Lift Machine Room.	
Note:-	In Every Lift Well, Give a 16A Switched Socket Outlet at Alternative Floor Starting From Basement till Terrace Floor and Bulkhead Light to be provided at each floor level.	

PROJECT NAME

IIM SHILLONG, UMSAWLI CAMPUS SHILLONG

ARCHITECT

AKSHAYA JAIN & ASSOCIATES

ARCHITECTURE. PLANNING. INTERIOR DESIGN

C-6 / 6098, VASANT KUNJ, NEW DELHI - 110070

TELEPHONES +91-11-26136098, 26132304, 41601615

FAX +91-11-26132304 E-Mail : mail@akshayajain.com

ELECTRICAL SERVICES CONSULTANT



ECMS INDIA PVT. LTD.

WP-21 C-282, BASEMENT

NOKIA SECTOR-71,

UTTAR PRADESH-201307

E-mail: ecms.tech01@gmail.com

URL: www.ecmsindia.com

Ph.No. 0120-3502815


DRAWING TITLE-









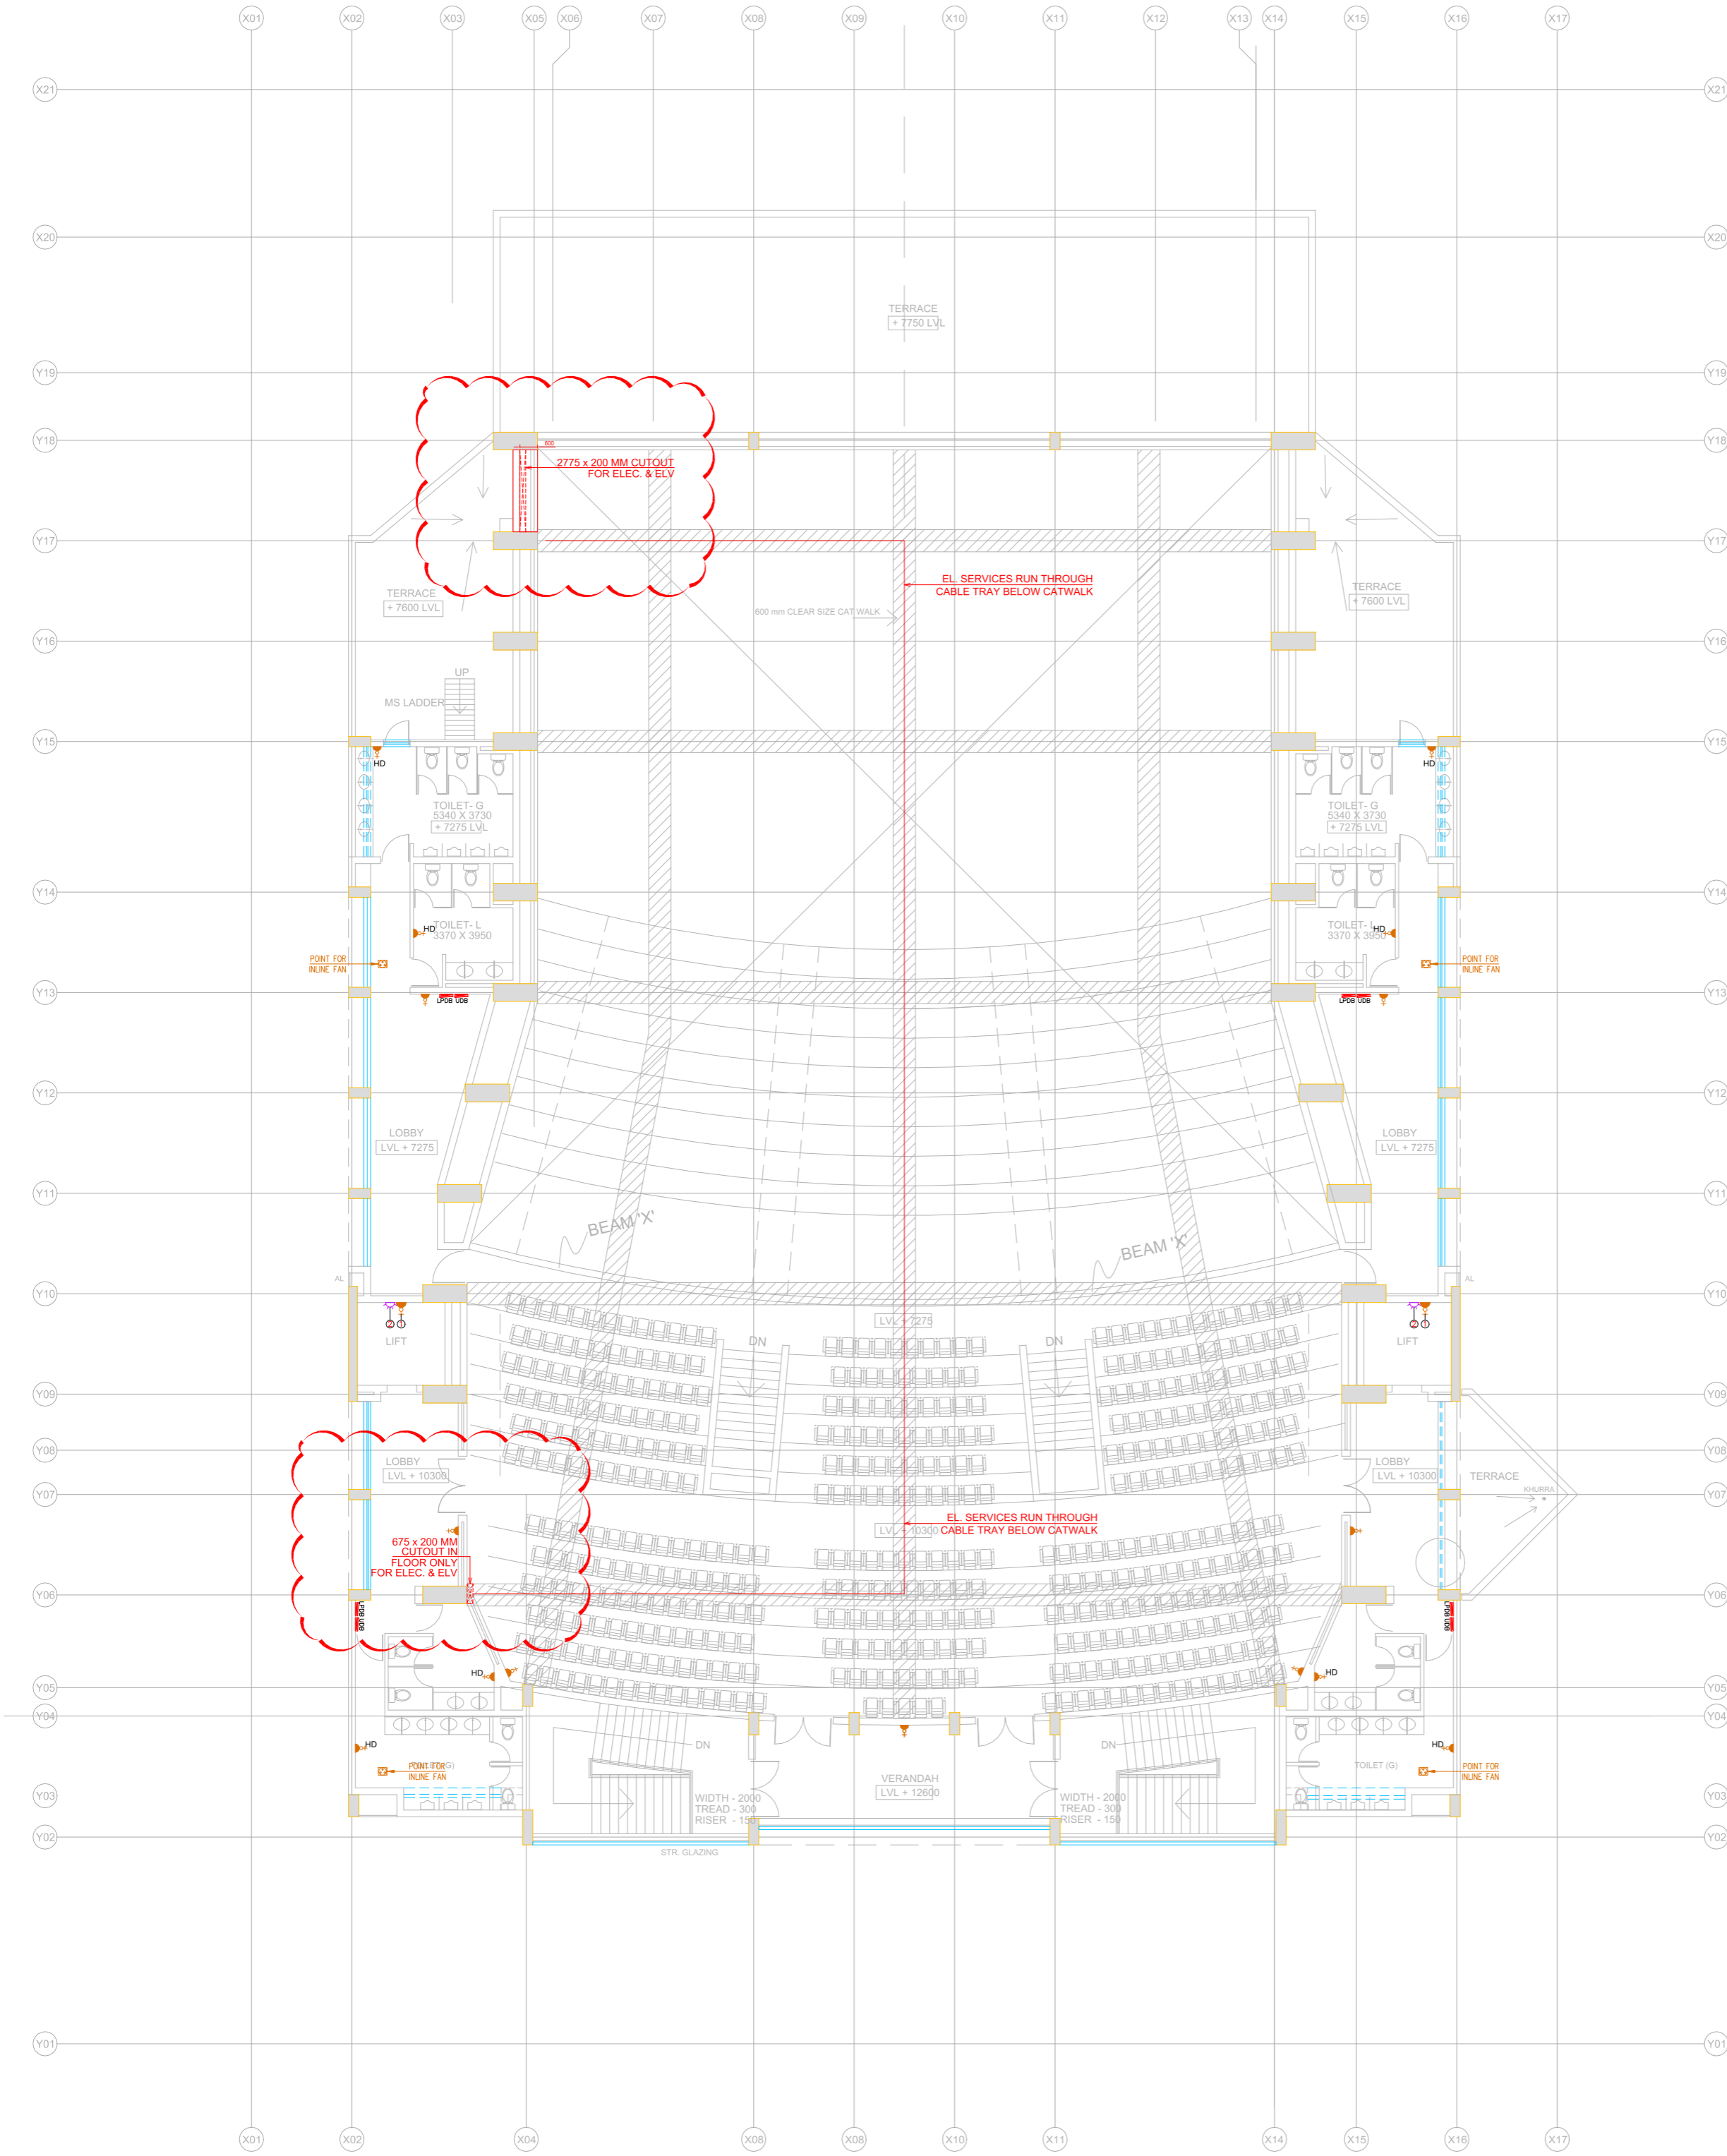



EL-POWER LAYOUT (PLAN LEVEL -2)


CONVENTION CENTRE (SITE - 10)-AUDI


<input type="checkbox"/> FOR APPROVAL	<input type="checkbox"/> ADVANCE COPY
<input checked="" type="checkbox"/> TENDER DRAWING	<input type="checkbox"/> GOOD FOR CONSTRUCTION

DRAWN BY	DEEPAK	REV NO.	RO(25.06.2025)
CKD BY	YASHI	SCALE	1:180(A2)
FIN. YEAR	2024-25	JOB NO.	2516
DRAWING NO.	IIM/ECMS/CON./CENTRE/AUDI/LVL.-2/PWR-03		



S.NO.	LEGENDS	TABLE
01.		2 NOS. 6A (RAW) SOCKET & 2 NOS. 6A SWITCH
02.		1 NO. 16A SOCKET & 1 NO. 16A SWITCH
03.		1 NO. 16A SOCKET & 1 NO. 16A SWITCH FOR HAND DRYER
04.		1 NO. TELEVISION OUTLET
05.		1 NO. DATA OUTLET
06.		1 NO. TELEPHONE OUTLET
07.		2 NOS. 6A (UPS) SOCKET & 2 NOS. 6A SWITCH
08.		2 NOS. 6/16A (UPS) SOCKET & 2 NOS. 16A SWITCH
09.		1 NO. 16A SWITCH SOCKET IN CEILING FOR INLINE FAN
10.		1 NO. 16A SWITCH SOCKET IN CEILING FOR CASSETTE UNIT
LIFT LEGENDS		
	2 Nos. 25mm Ø PVC Conduit From Basement up to Terrace for 16A S.S.Outlet, Circuit From DB Location in Lift Machine Room.	
	1 No. 25mm Ø PVC Conduit From Basement up to Terrace for Bulk Head Light, Circuit From DB Location in Lift Machine Room.	
Note:--	In Every Lift Well, Give a 16A Switched Socket Outlet at Alternative Floor Starting From Basement till Terrace Floor and Bulkhead Light to be provided at each floor level.	

PROJECT NAME IIM SHILLONG, UMSAWLI CAMPUS SHILLONG	
ARCHITECT AKSHAYA JAIN & ASSOCIATES ARCHITECTURE. PLANNING. INTERIOR DESIGN C-6 / 6098, VASANT KUNJ, NEW DELHI - 110070 TELEPHONES +91-11-26136098, 26132304, 41601615 FAX +91-11-26132304 E-Mail : mail@akshayajain.com	
ELECTRICAL SERVICES CONSULTANT  ECMS INDIA PVT. LTD. WP-21 C-282, BASEMENT NOIDA SECTOR-71, UTTAR PRADESH-201307 E-mail: ecms.tech01@gmail.com URL: www.ecmsindia.com Ph.No. 0120-3502815	
DRAWING TITLE- EL-POWER LAYOUT (PLAN LEVEL -3) CONVENTION CENTRE (SITE - 10)-AUDI	
<input type="checkbox"/> FOR APPROVAL	<input type="checkbox"/> ADVANCE COPY
<input checked="" type="checkbox"/> TENDER DRAWING	<input type="checkbox"/> GOOD FOR CONSTRUCTION
DRAWN BY DEEPAK	REV NO. R0(25.06.2025)
CKD BY YASHI	SCALE 1:180(A2)
FIN. YEAR 2024-25	JOB NO. 2516
DRAWING NO. IIM/ECMS/CON./CENTRE/AUDI/LVL.-3/PWR-04	

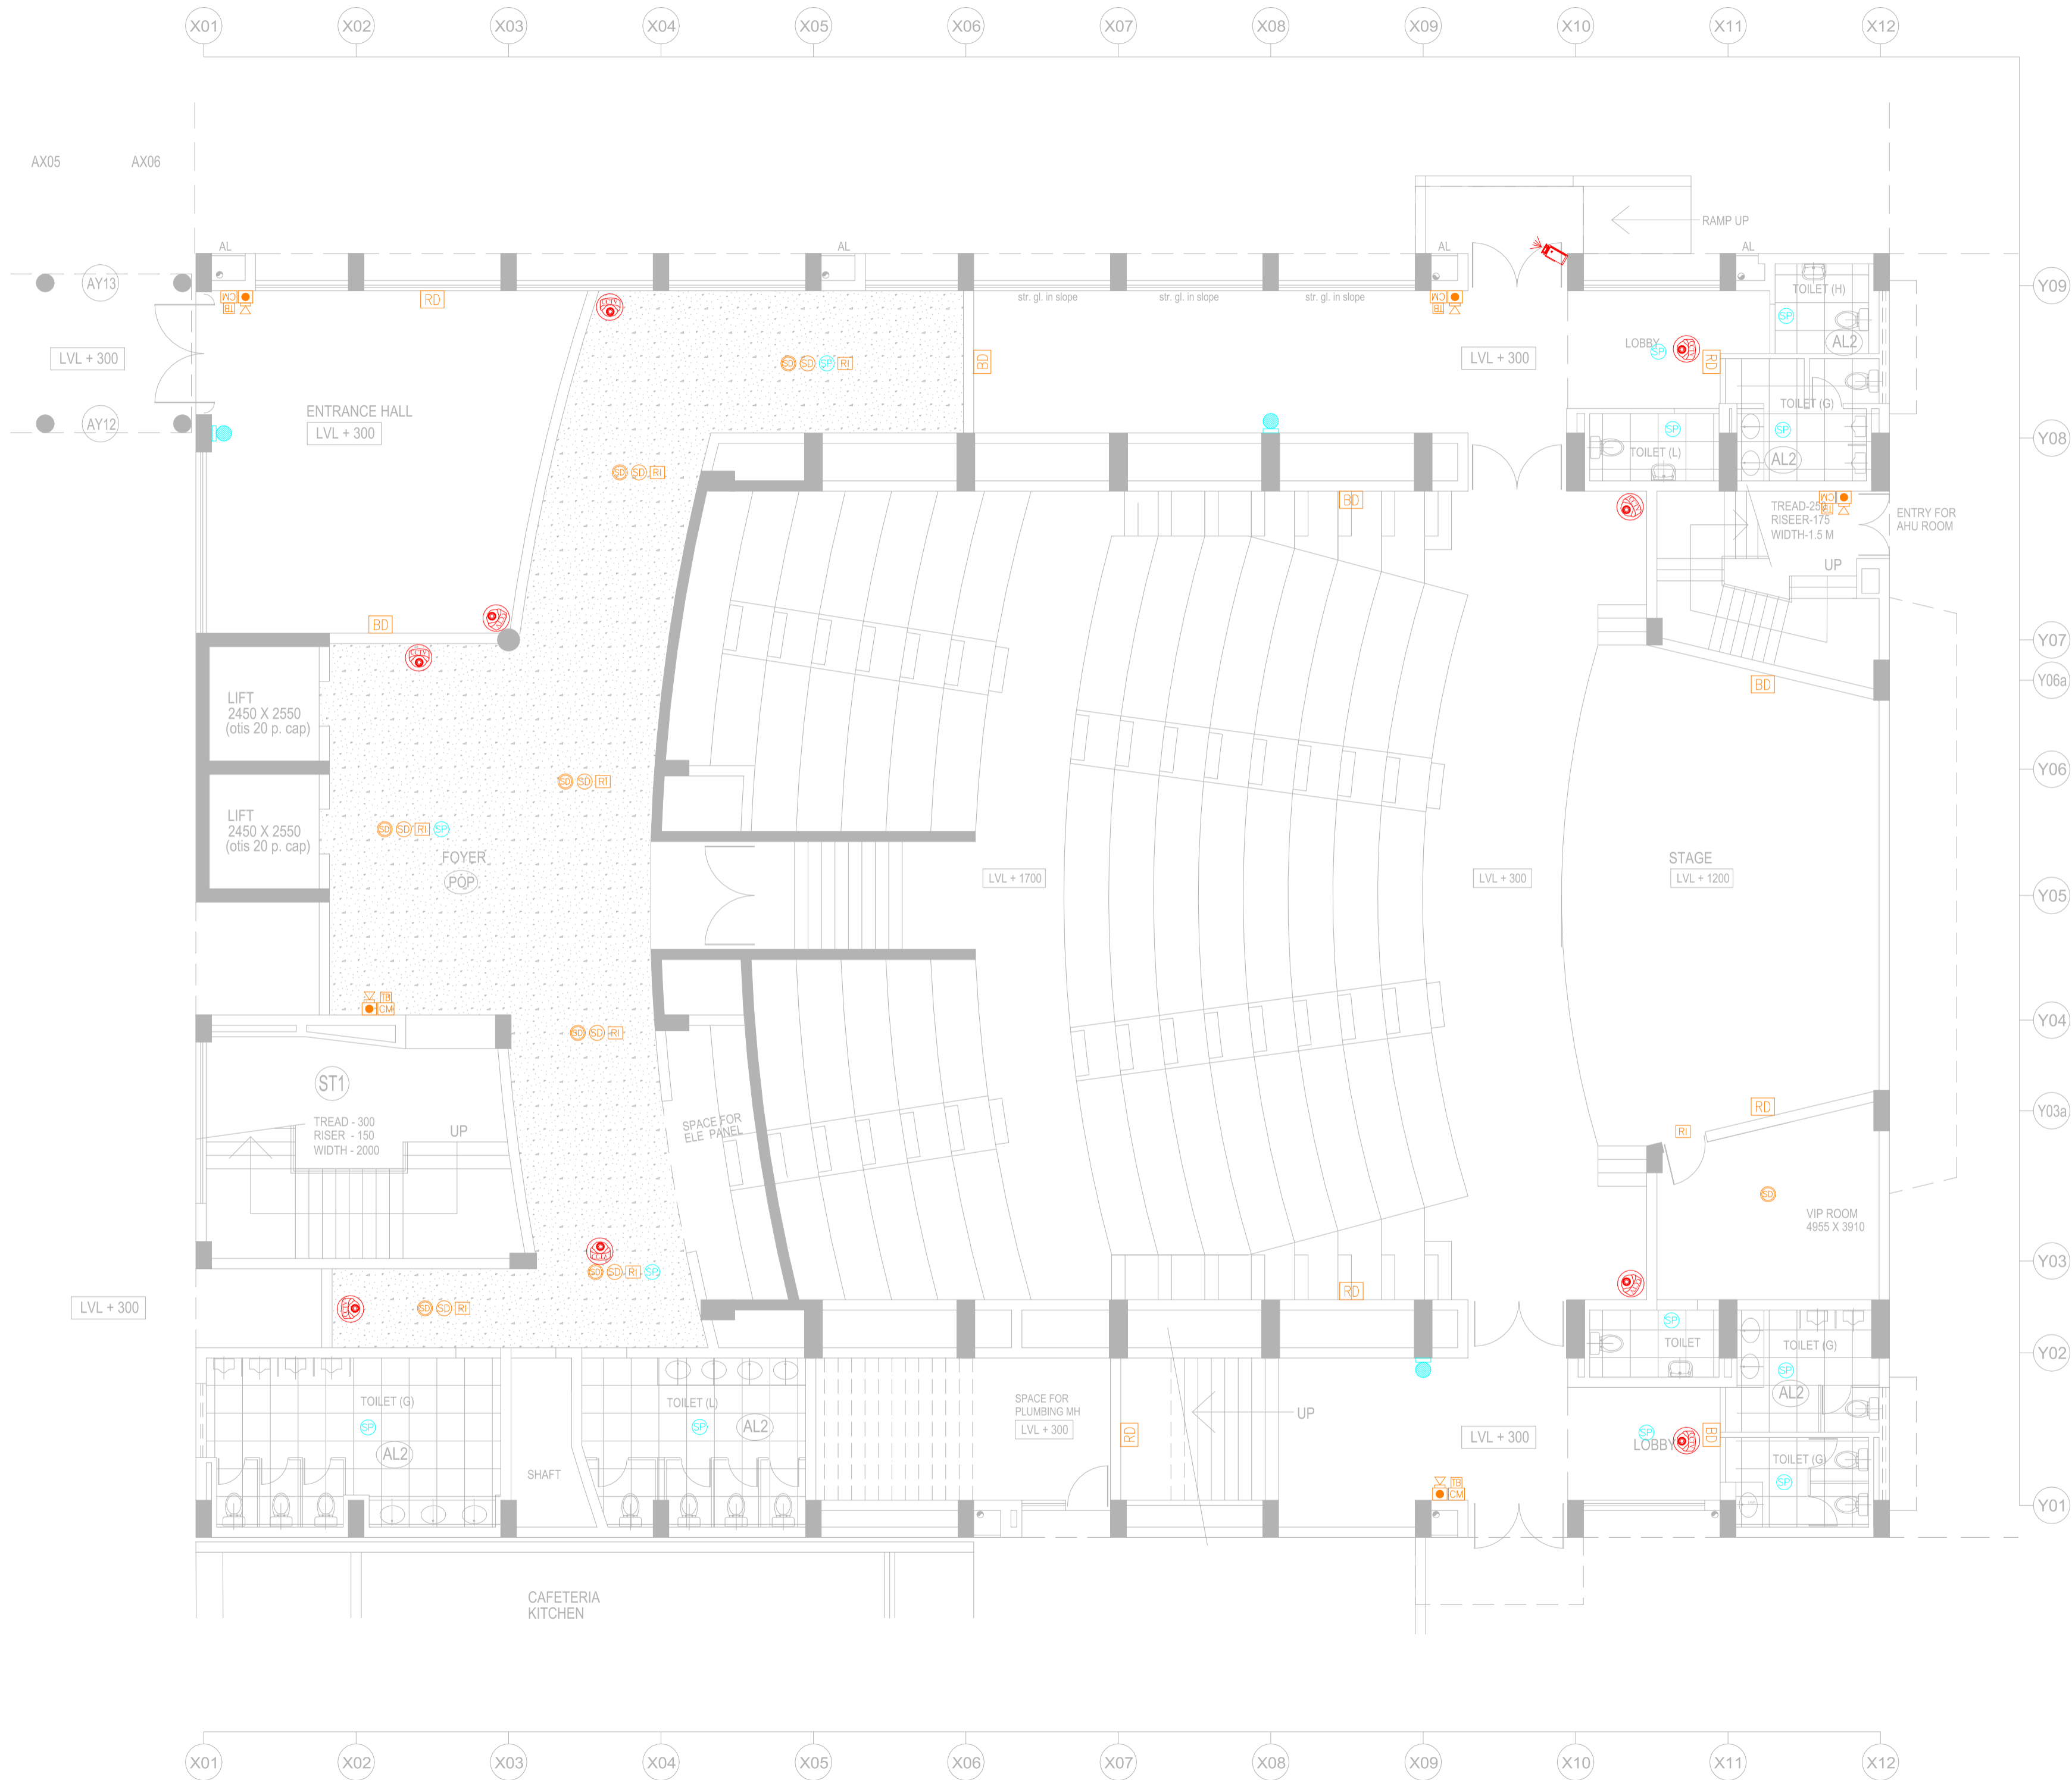

S.NO.	LEGENDS TABLE FIRE ALARM SYSTEM
01.	FIRE ALARM CONTROL PANEL
02.	SMOKE DETECTOR ON FALSE CEILING
03.	SMOKE DETECTOR ON SLAB
04.	HEAT DETECTOR ON SLAB
05.	MANUAL CALL POINT DEVICE
06.	RESPONSE INDICATOR
07.	HOOTER CUM STROBE
08.	CONTROL MODULE DEVICE
09.	MONITOR MODULE DEVICE @FHC's SHAFT
10.	FAULT ISOLATOR DEVICE AS PER LOOP @25D
11.	RELAY MODULE DEVICE
12.	BEAM DETECTOR
13.	BEAM RECEIVER
14.	TALK BACK DEVICE

S.NO.	LEGENDS TABLE PUBLIC ADDRESS SYSTEM
01.	AMPLIFIER UNIT
02.	CEILING MOUNTED SPEAKER
03.	WALL MOUNTED SPEAKER
04.	MICROPHONE
05.	VOLUME CONTROLLER

S.NO.	LEGENDS TABLE CCTV SYSTEM
01.	NETWORK VIDEO RECORDER AS PER SITE
02.	DOME CAMERA
03.	BULLET CAMERA
04.	PTZ CAMERA

PROJECT NAME
IIM SHILLONG, UMSAWLI CAMPUS SHILLONG

ARCHITECT
AKSHAYA JAIN & ASSOCIATES
ARCHITECTURE. PLANNING. INTERIOR DESIGN
C-6 / 6098, VASANT KUNJ, NEW DELHI - 110070
TELEPHONES +91-11-26136098, 26132304, 41601615
FAX +91-11-26132304 E-Mail : mail@akshayajain.com


ELECTRICAL SERVICES CONSULTANT

ECMS INDIA PVT. LTD.
WP-21 C-282, BASEMENT
NOIDA SECTOR-71,
UTTAR PRADESH-201307
E-mail: ecms.tech01@gmail.com
URL: www.ecmsindia.com
Ph.No. 0120-3502815

DRAWING TITLE-
EL-FAS, PAS & CCTV LAYOUT (PLAN LEVEL -1)
CONVENTION CENTRE (SITE - 10)-SEMINAR HALL

FOR APPROVAL	ADVANCE COPY
TENDER DRAWING	GOOD FOR CONSTRUCTION

DRAWN BY	DEEPAK	REV NO.	RD(26.06.2025)
CKD BY	YASHI	SCALE	1:100(A2)
FIN. YEAR	2024-25	JOB NO.	2516
DRAWING NO.	IIM/ECMS/CON./CENTRE/SEM./LVL.-1/FAS/PAS/CCTV-01		

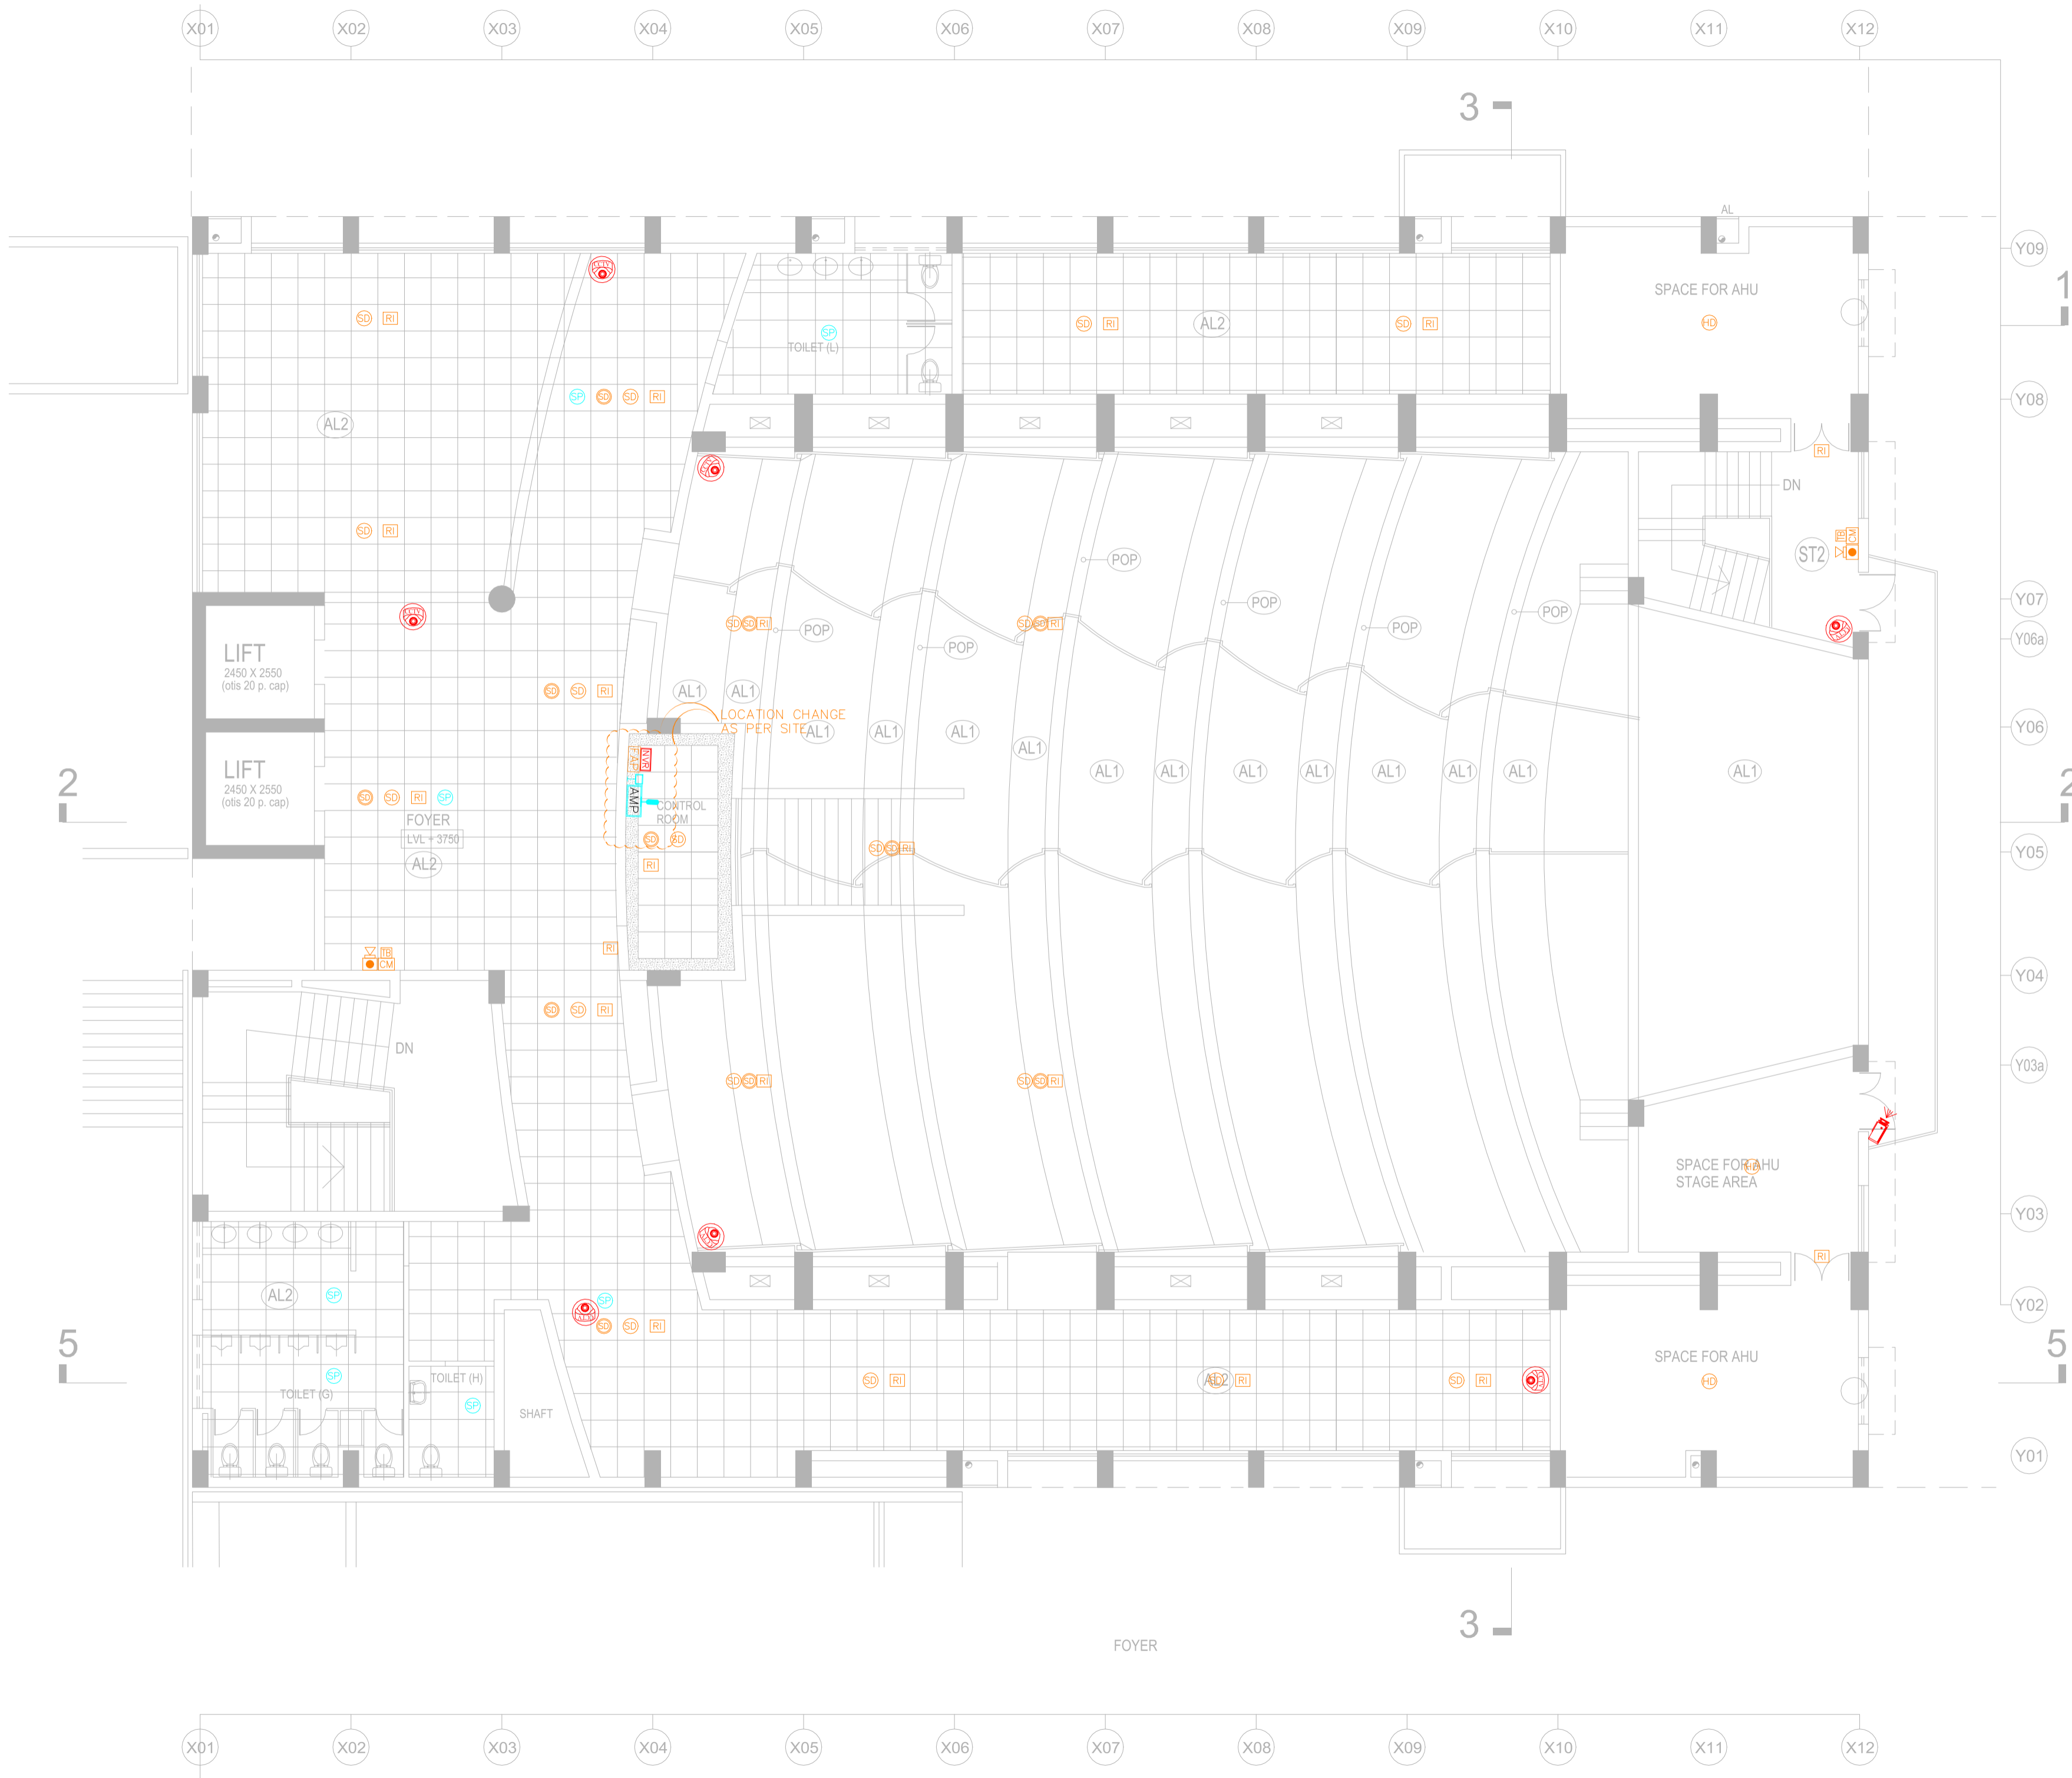

S.NO.	LEGENDS TABLE FIRE ALARM SYSTEM
01.	FIRE ALARM CONTROL PANEL
02.	SMOKE DETECTOR ON FALSE CEILING
03.	SMOKE DETECTOR ON SLAB
04.	HEAT DETECTOR ON SLAB
05.	MANUAL CALL POINT DEVICE
06.	RESPONSE INDICATOR
07.	HOOTER CUM STROBE
08.	CONTROL MODULE DEVICE
09.	MONITOR MODULE DEVICE @FHC's SHAFT
10.	FAULT ISOLATOR DEVICE AS PER LOOP @25D
11.	RELAY MODULE DEVICE
12.	BEAM DETECTOR
13.	BEAM RECEIVER
14.	TALK BACK DEVICE

S.NO.	LEGENDS TABLE PUBLIC ADDRESS SYSTEM
01.	AMPLIFIER UNIT
02.	CEILING MOUNTED SPEAKER
03.	WALL MOUNTED SPEAKER
04.	MICROPHONE
05.	VOLUME CONTROLLER

S.NO.	LEGENDS TABLE CCTV SYSTEM
01.	NETWORK VIDEO RECORDER AS PER SITE
02.	DOME CAMERA
03.	BULLET CAMERA
04.	PTZ CAMERA

PROJECT NAME
IIM SHILLONG, UMSAWLI CAMPUS SHILLONG

ARCHITECT
AKSHAYA JAIN & ASSOCIATES
ARCHITECTURE. PLANNING. INTERIOR DESIGN
C-6 / 6098, VASANT KUNJ, NEW DELHI - 110070
TELEPHONES +91-11-26136098, 26132304, 41601615
FAX +91-11-26132304 E-Mail : mail@akshayajain.com


ELECTRICAL SERVICES CONSULTANT

ECMS INDIA PVT. LTD.
WP-21 C-282, BASEMENT
NOIDA SECTOR-71,
UTTAR PRADESH-201307
E-mail: ecms.tech01@gmail.com
URL: www.ecmsindia.com
Ph.No. 0120-3502815

DRAWING TITLE-
EL-FAS, PAS & CCTV LAYOUT (PLAN LEVEL -2)
CONVENTION CENTRE (SITE - 10)-SEMINAR HALL

FOR APPROVAL	ADVANCE COPY
TENDER DRAWING	GOOD FOR CONSTRUCTION

DRAWN BY	DEEPAK	REV NO.	RD(26.06.2025)
CKD BY	YASHI	SCALE	1:100(A2)
FIN. YEAR	2024-25	JOB NO.	2516
DRAWING NO.	IIM/ECMS/CON./CENTRE/SEM./LVL.-2/FAS/PAS/CCTV-02		

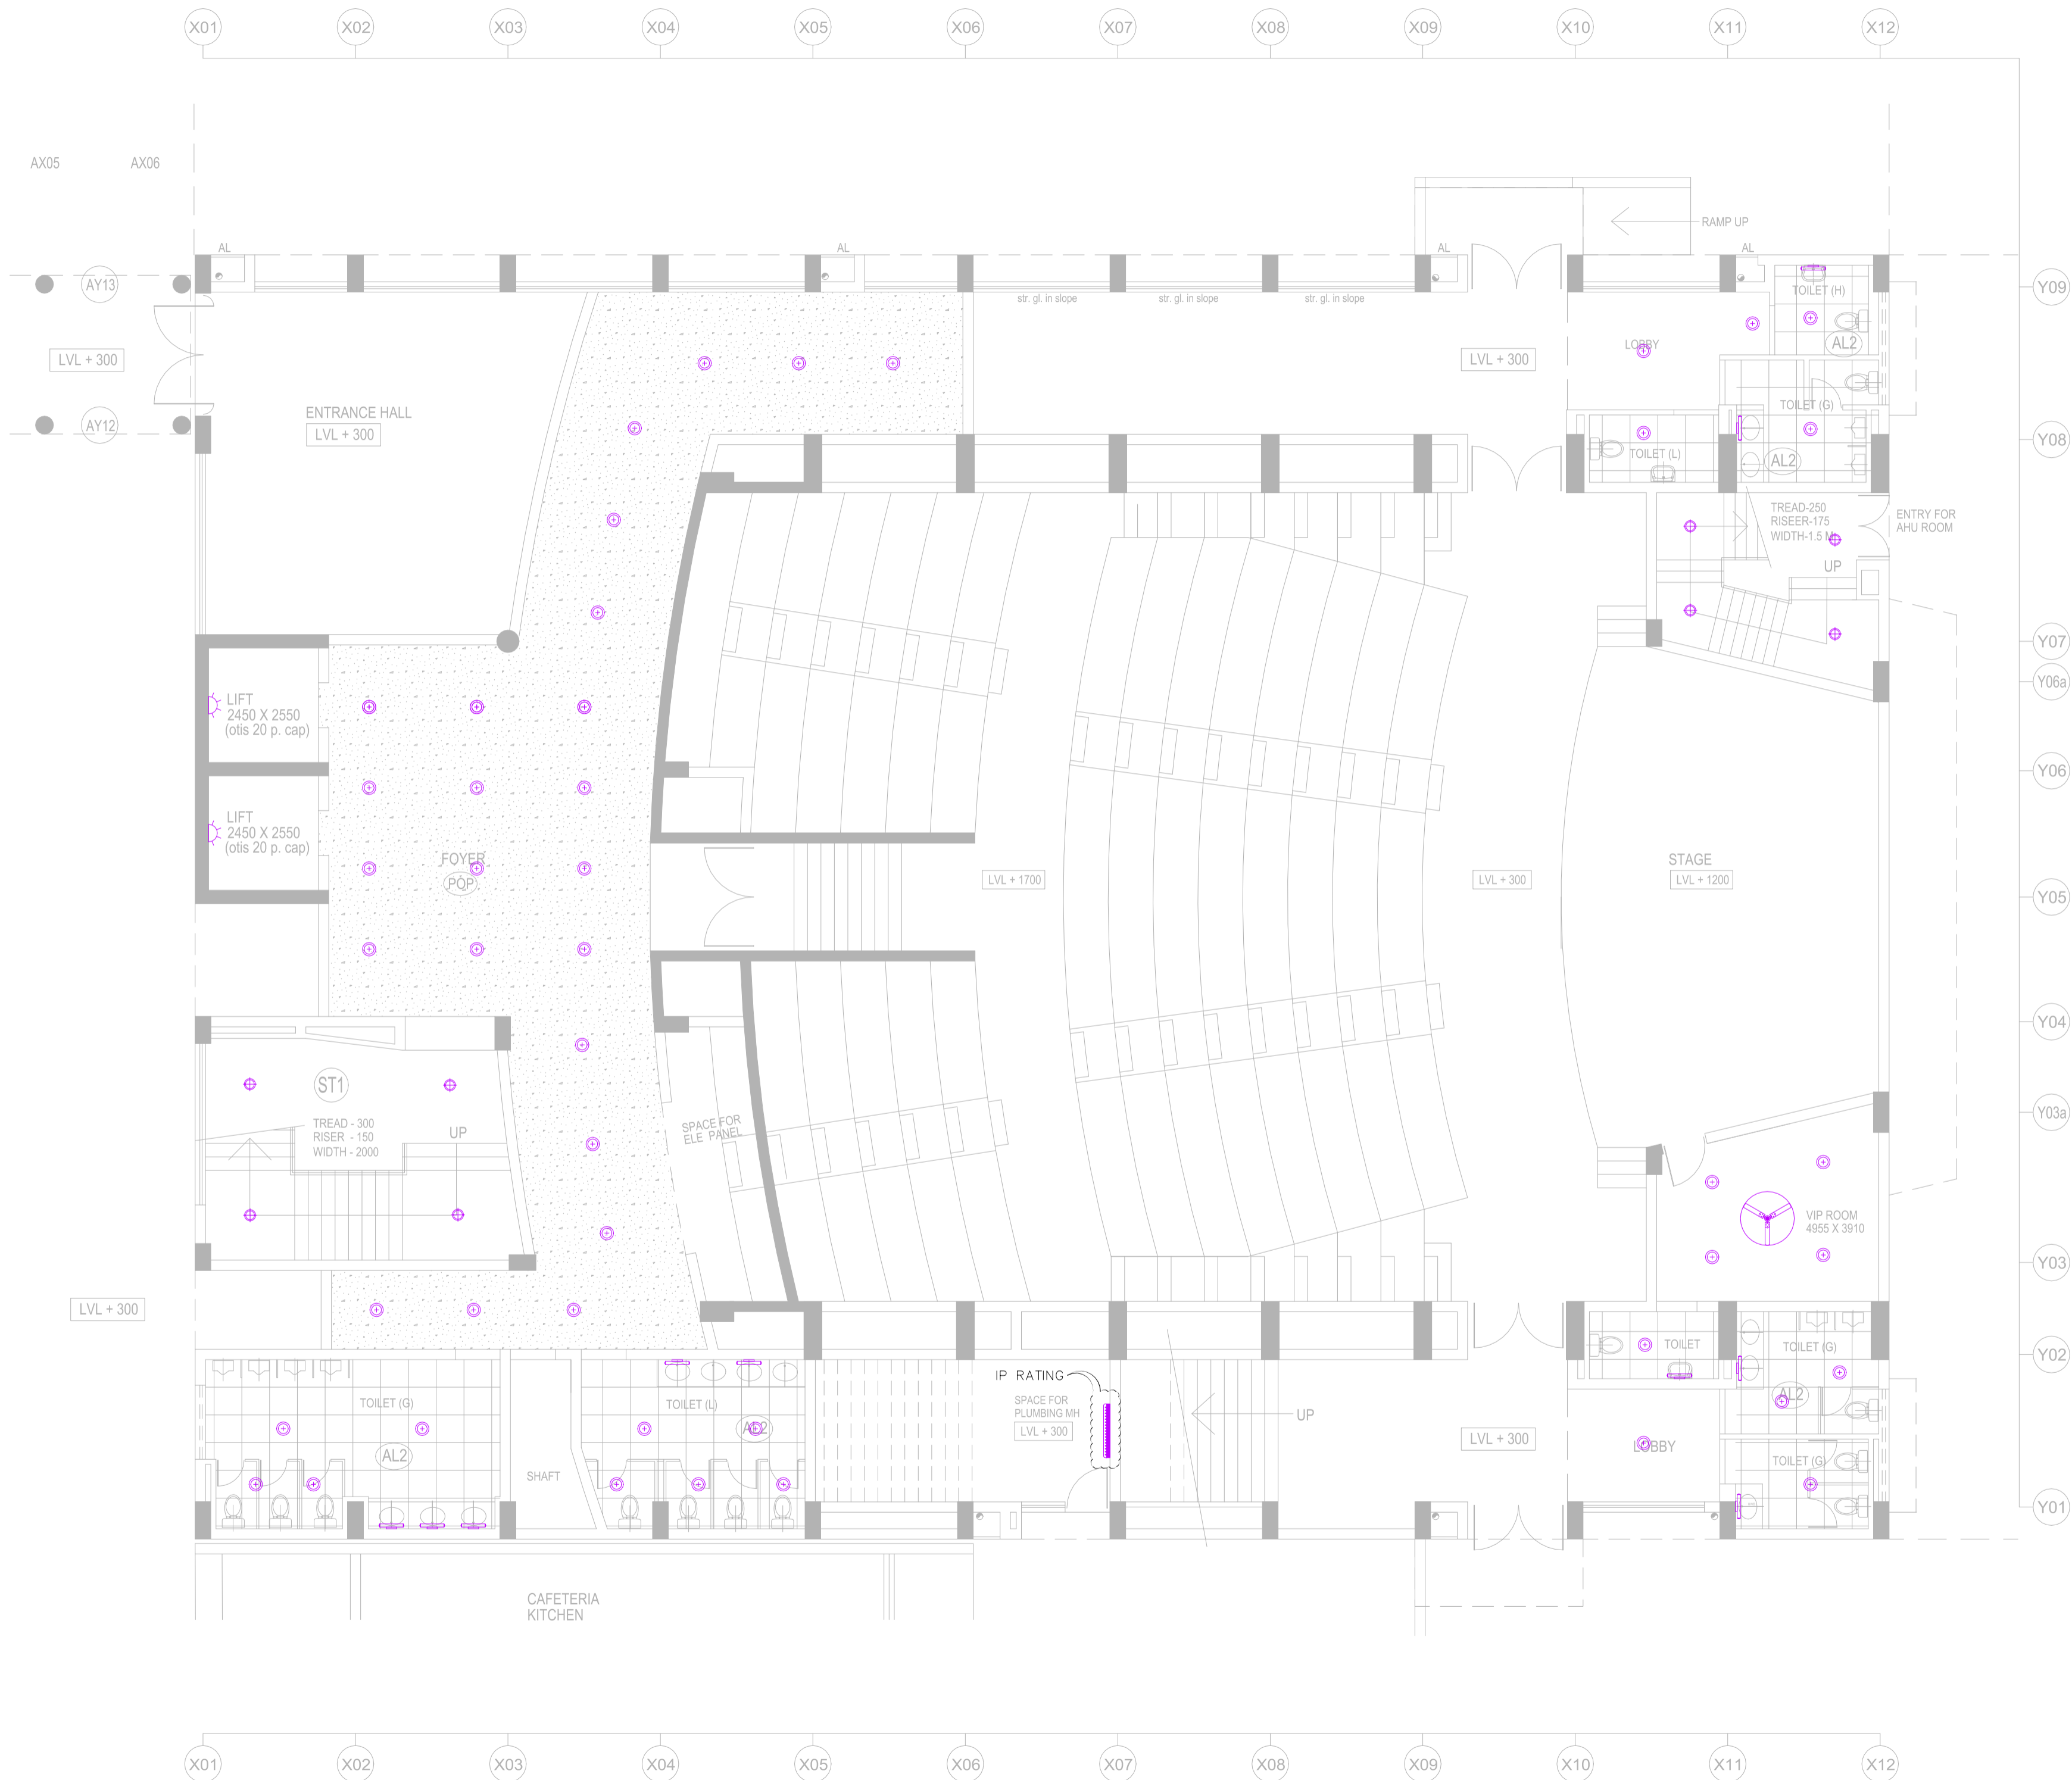

S.NO.	LEGENDS	TABLE
01.		LED CEILING DOWNLIGHT-1
02.		LED CEILING DOWNLIGHT-2
03.		LED CEILING DOWNLIGHT-3
04.		LED CEILING COVE LIGHT
05.		LED WALL MOUNTED BATTEN LIGHT
06.		LED MIRROR LIGHT
07.		BULK HEAD LIGHT
08.		1200MMØ CEILING FAN

PROJECT NAME
IIM SHILLONG, UMSAWLI CAMPUS SHILLONG


ARCHITECT
AKSHAYA JAIN & ASSOCIATES
ARCHITECTURE. PLANNING. INTERIOR DESIGN
C-6 / 6098, VASANT KUNJ, NEW DELHI - 110070
TELEPHONES +91-11-26136098, 26132304, 41601615
FAX +91-11-26132304 E-Mail : mail@akshayajain.com

ELECTRICAL SERVICES CONSULTANT
**ECMS INDIA PVT. LTD.**
WP-21 C-282, BASEMENT
NOIDA SECTOR-71,
UTTAR PRADESH-201307
E-mail: ecms.tech01@gmail.com
URL: www.ecmsindia.com
Ph.No. 0120-3502815

DRAWING TITLE-
EL-LIGHT LAYOUT (PLAN LEVEL-01)
CONVENTION CENTRE (SITE - 10)-SEMINAR HALL

<input type="checkbox"/> FOR APPROVAL	<input type="checkbox"/> ADVANCE COPY
<input checked="" type="checkbox"/> TENDER DRAWING	<input type="checkbox"/> GOOD FOR CONSTRUCTION

DRAWN BY	DEEPAK	REV NO.	RD(26.06.2025)
CKD BY	YASHI	SCALE	1:100(A2)
FIN. YEAR	2024-25	JOB NO.	2516
DRAWING NO.	IIM/ECMS/CON./CENTRE/SEM./LVL.-1/LGT-01		

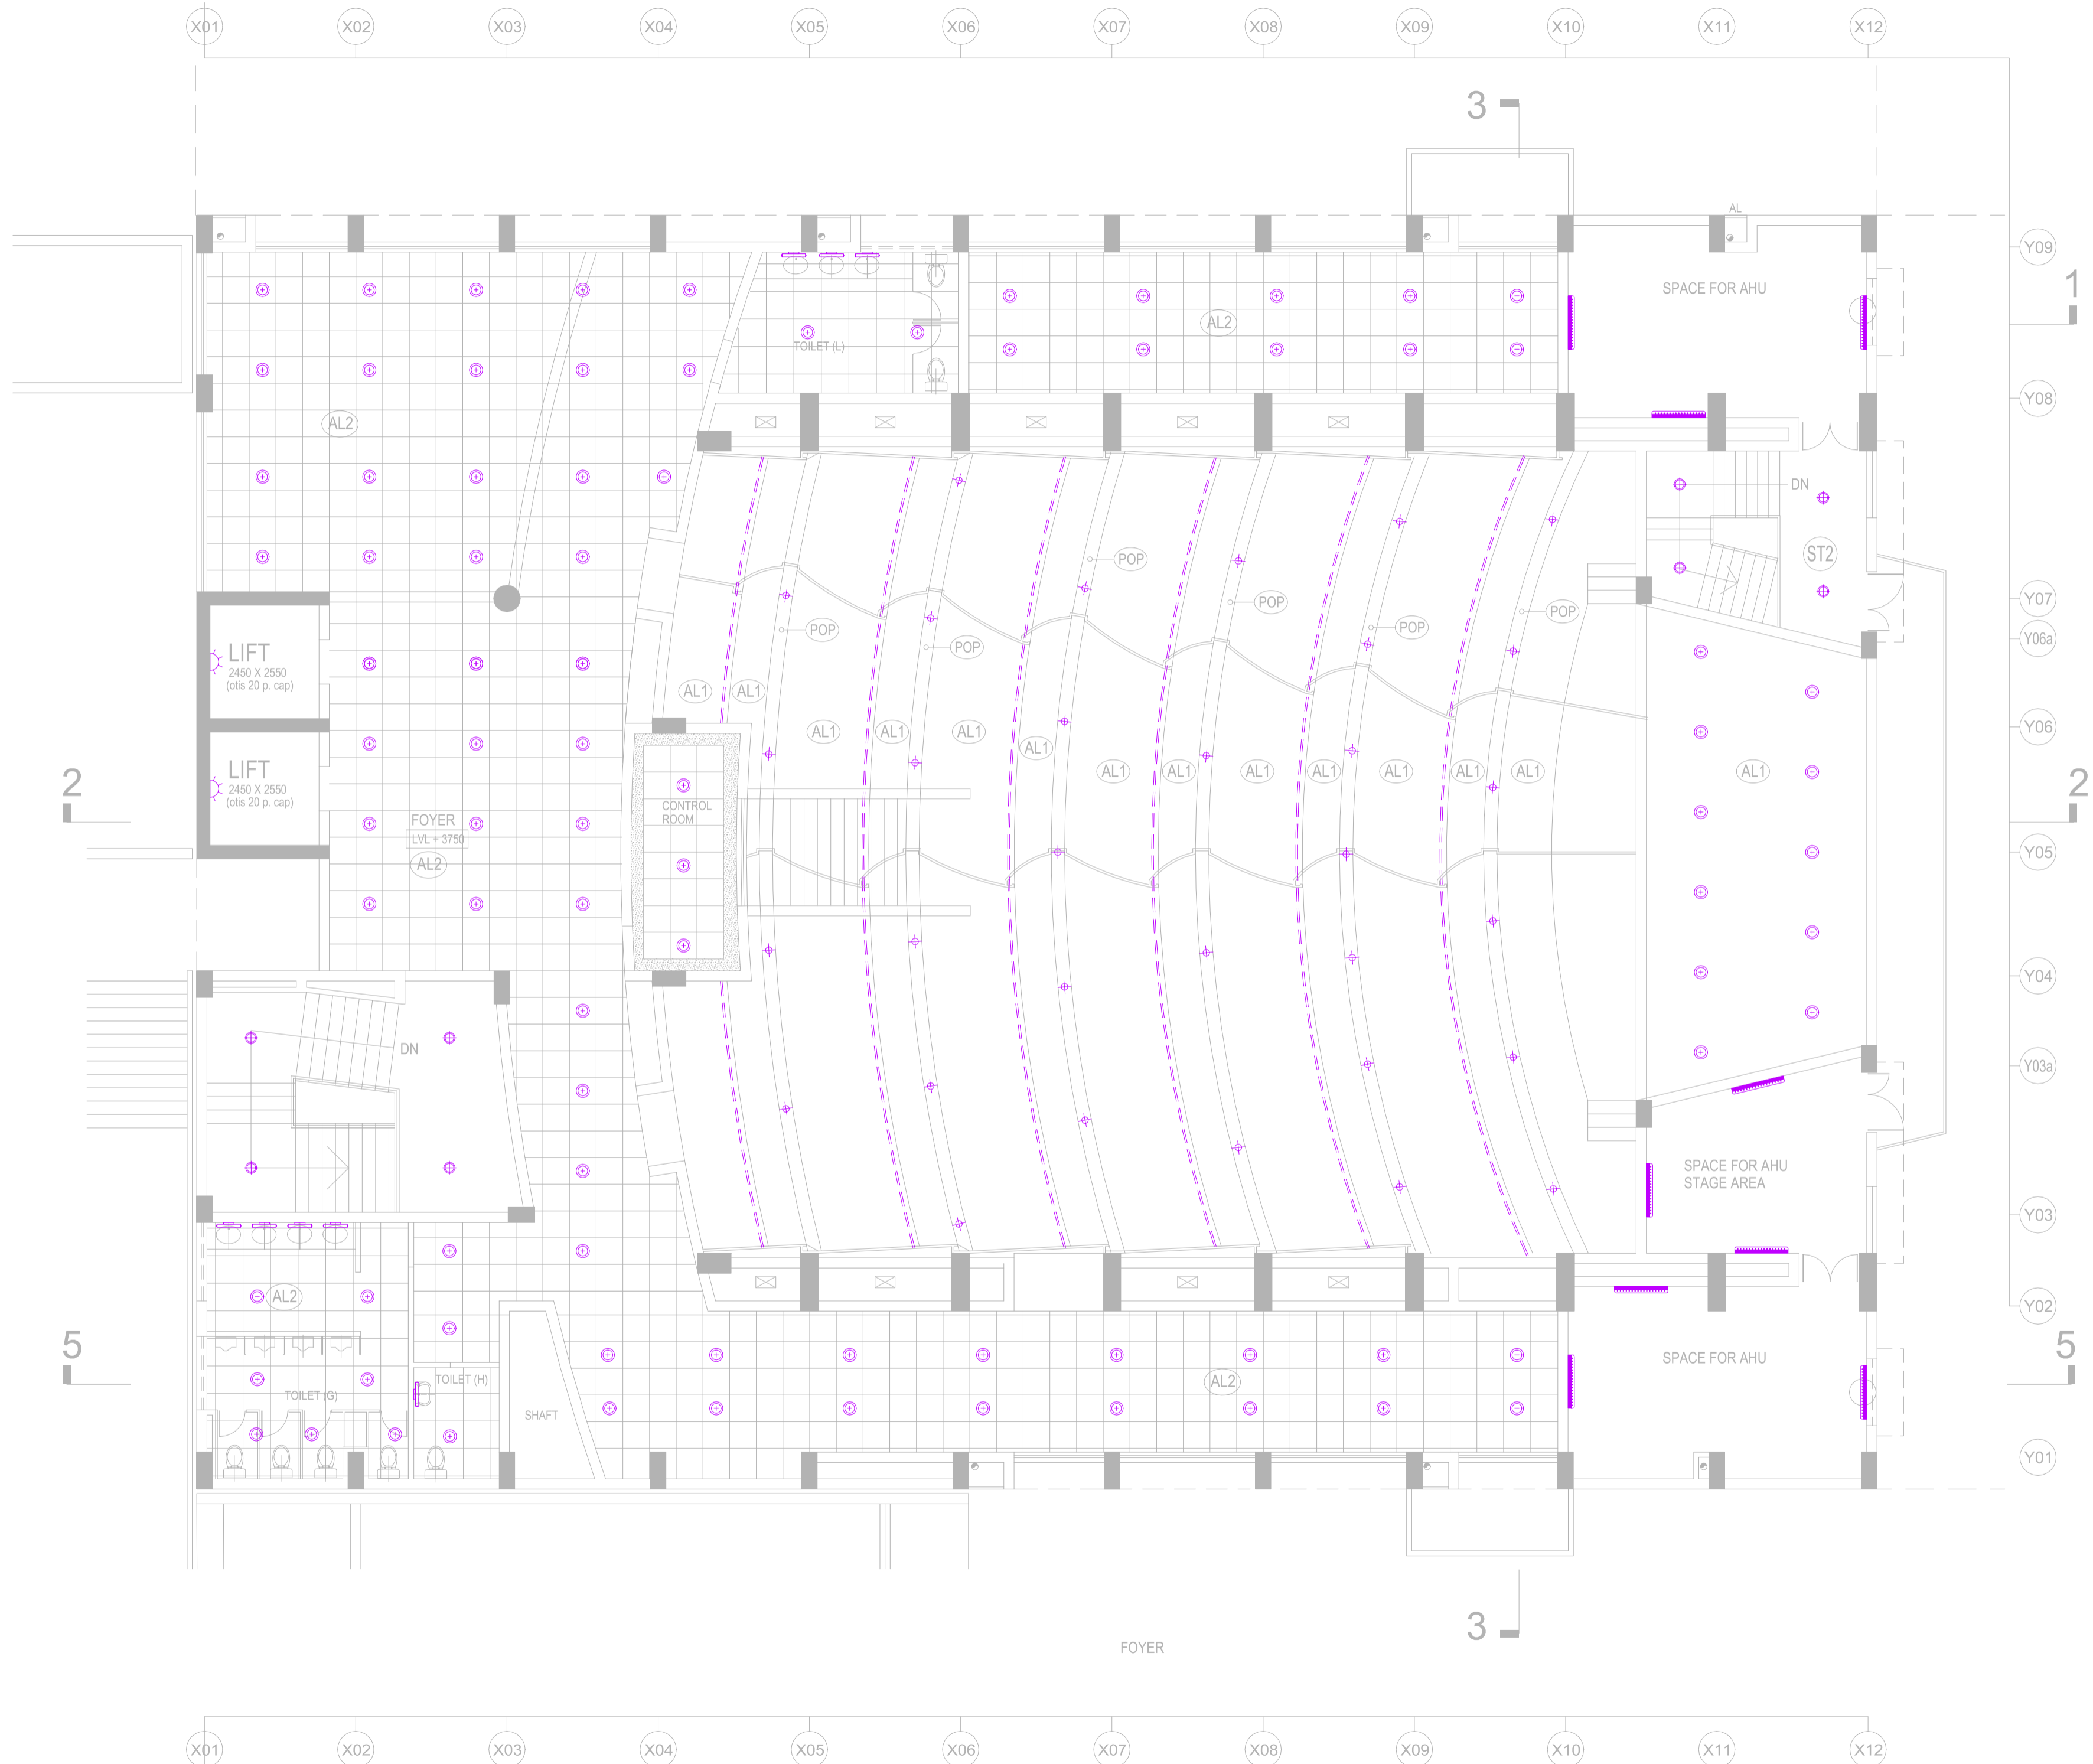

S.NO.	LEGENDS	TABLE
01.		LED CEILING DOWNLIGHT-1
02.		LED CEILING DOWNLIGHT-2
03.		LED CEILING DOWNLIGHT-3
04.		LED CEILING COVE LIGHT
05.		LED WALL MOUNTED BATTEN LIGHT
06.		LED MIRROR LIGHT
07.		BULK HEAD LIGHT
08.		1200MMØ CEILING FAN

PROJECT NAME
IIM SHILLONG, UMSAWLI CAMPUS SHILLONG


ARCHITECT
AKSHAYA JAIN & ASSOCIATES
ARCHITECTURE. PLANNING. INTERIOR DESIGN
C-6 / 6098, VASANT KUNJ, NEW DELHI - 110070
TELEPHONES +91-11-26136098, 26132304, 41601615
FAX +91-11-26132304 E-Mail : mail@akshayajain.com

ELECTRICAL SERVICES CONSULTANT
ECMS INDIA PVT. LTD.
WP-21 C-282, BASEMENT
NOIDA SECTOR-71,
UTTAR PRADESH-201307
E-mail: ecms.tech01@gmail.com
URL: www.ecmsindia.com
Ph.No. 0120-3502815

DRAWING TITLE-
EL-LIGHTING LAYOUT (PLAN LEVEL -2)
CONVENTION CENTRE (SITE - 10)-SEMINAR HALL

FOR APPROVAL	ADVANCE COPY
TENDER DRAWING	GOOD FOR CONSTRUCTION

DRAWN BY	DEEPAK	REV NO.	RD(26.06.2025)
CKD BY	YASHI	SCALE	1:100(A2)
FIN. YEAR	2024-25	JOB NO.	2516
DRAWING NO.	IIM/ECMS/CON./CENTRE/SEM./LVL-2/LTG-02		

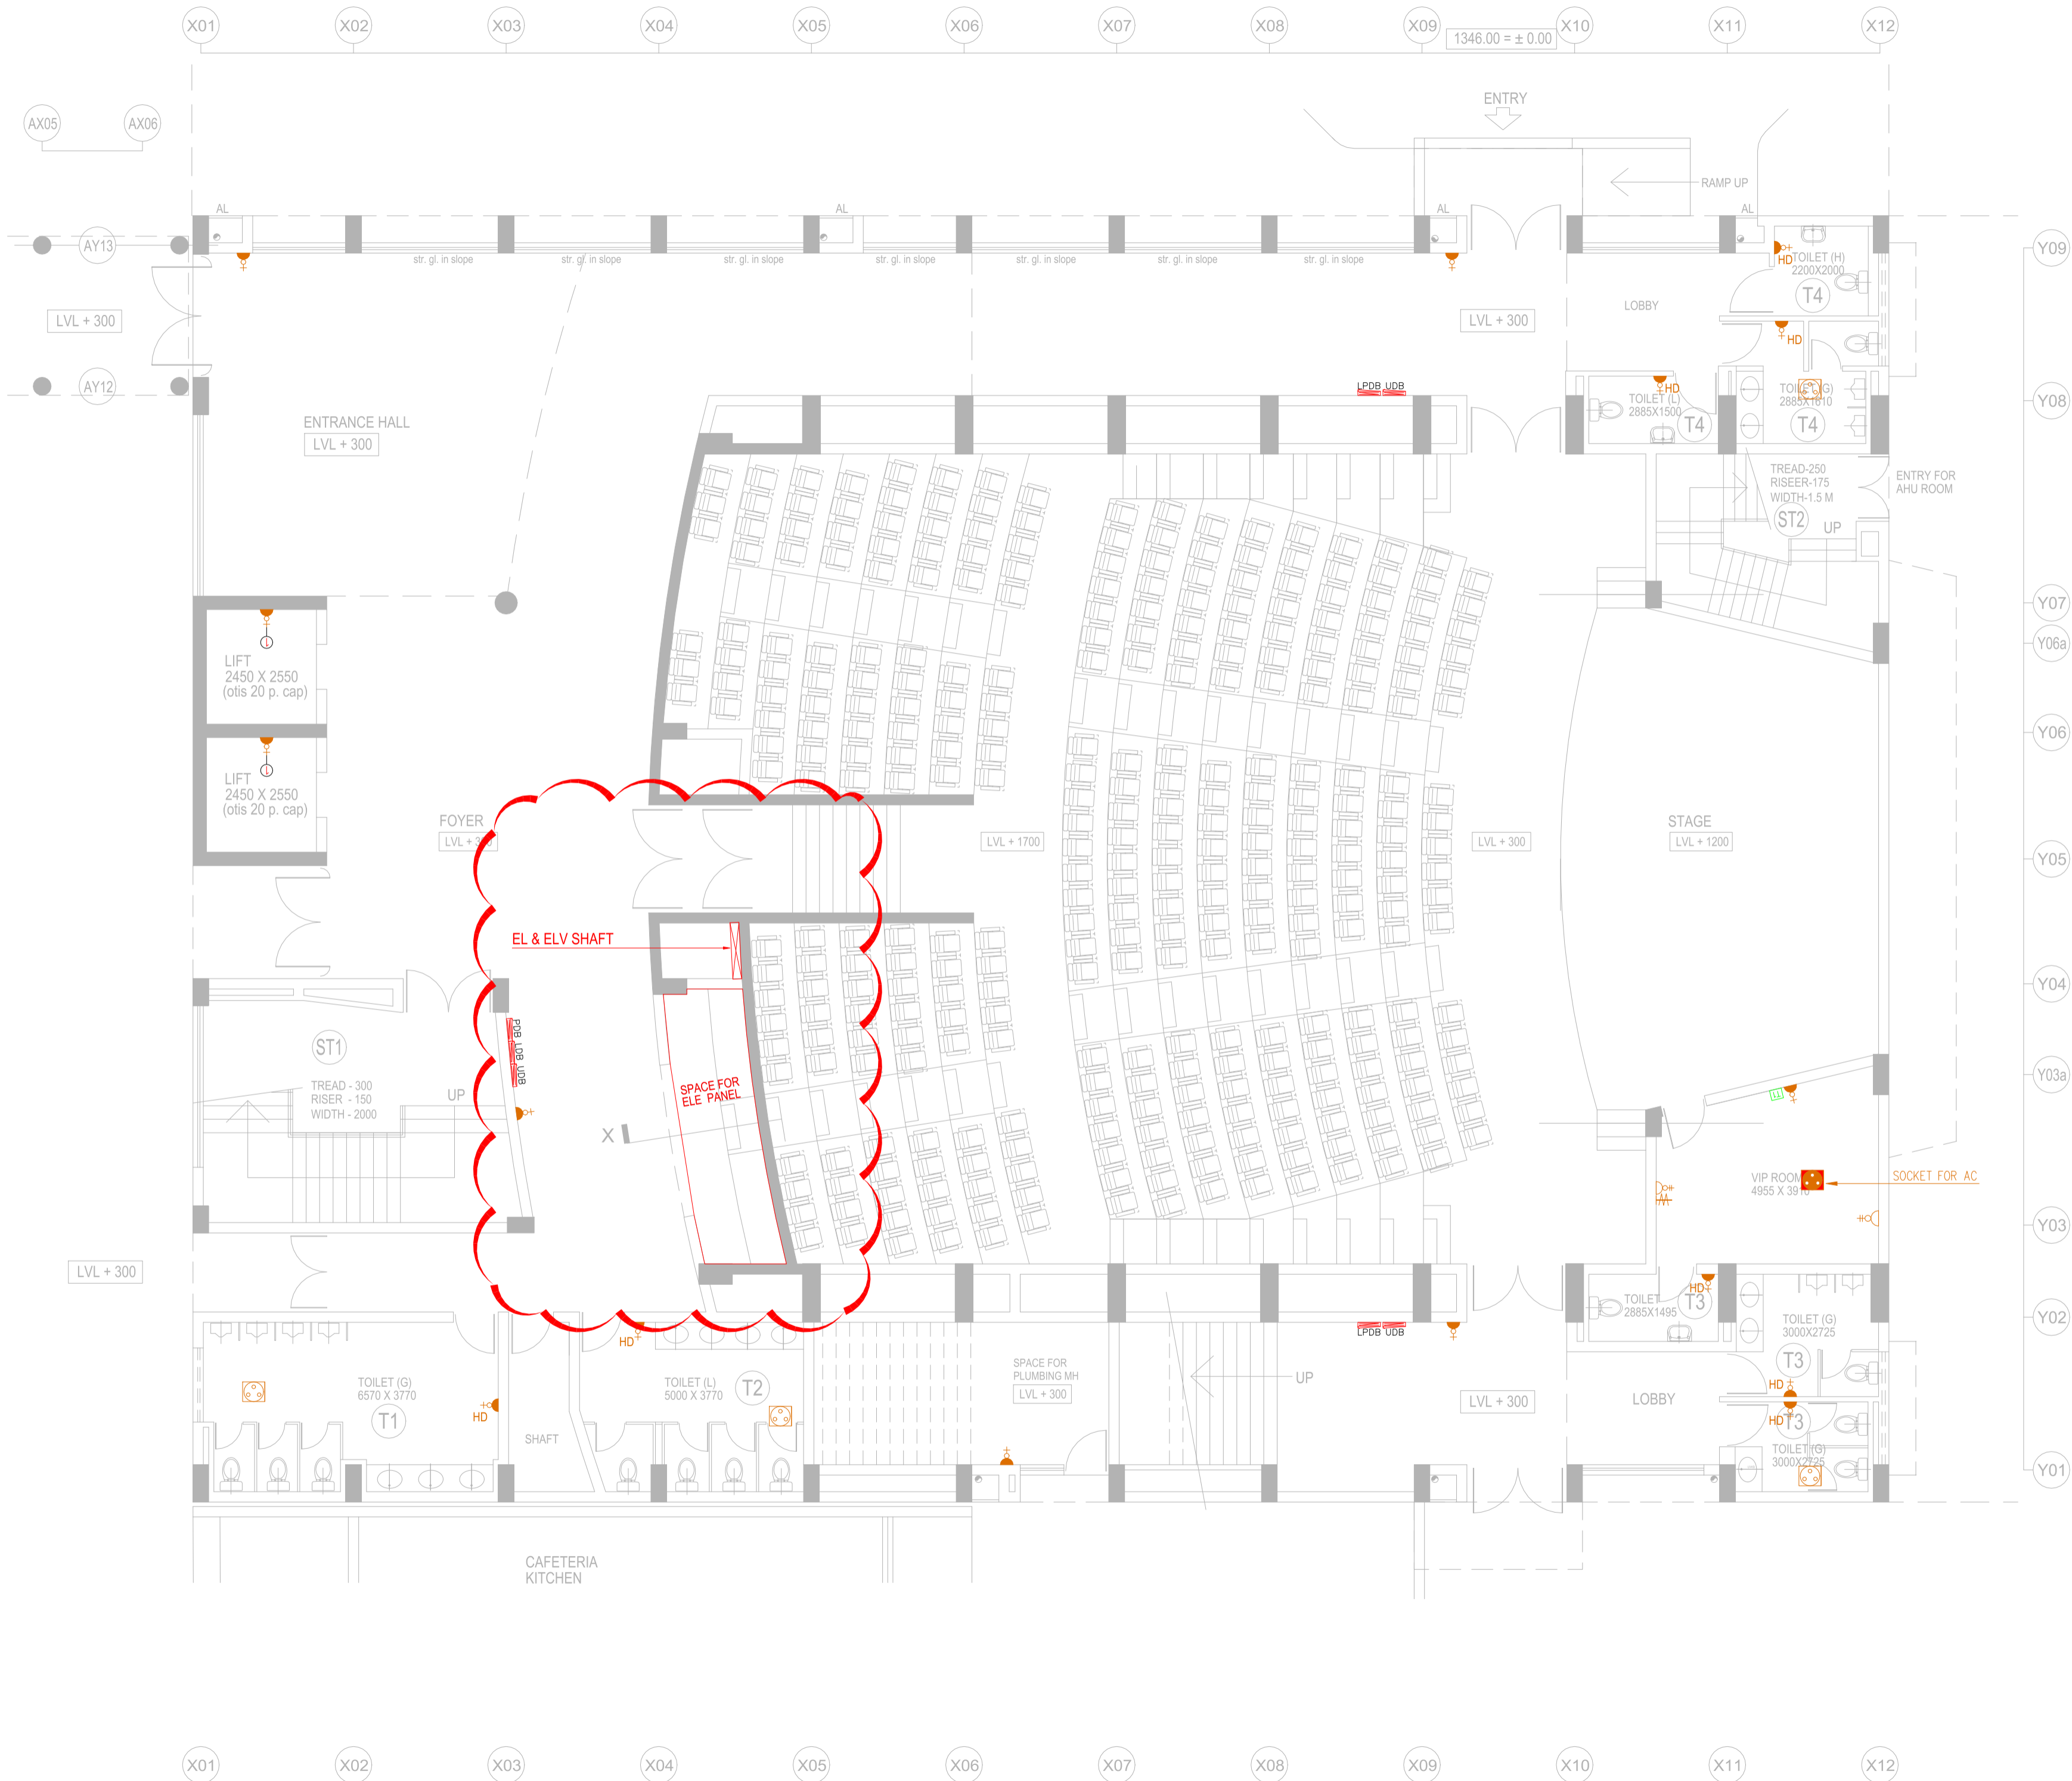

S.NO.	LEGENDS	TABLE
01.		1 NO. 6A SOCKET & 1 NO. 6A SWITCH
02.		2 NOS. 6A (RAW) SOCKET & 2 NOS. 6A SWITCH
03.		1 NO. 16A SOCKET & 1 NO. 16A SWITCH
04.		1 NO. 16A SOCKET & 1 NO. 16A SWITCH FOR HAND DRYER
05.		1 NO. 16A (UPS) SOCKET & 1 NO. 16A SWITCH
06.		3 NOS. DATA OUTLET
07.		1 NO. TELEVISION OUTLET
08.		1 NO. TELEPHONE OUTLET
09.		2 NOS. 6A (UPS) SOCKET & 2 NOS. 6A SWITCH
10.		2 NOS. 6/16A (UPS) SOCKET & 2 NOS. 16A SWITCH
11.		1 NO. HDMI
12.		1 NO. 16A SOCKET FOR IN-LINE FAN

LEGENDS

2 Nos. 25mm Ø PVC Conduit From Basement up to Terrace for 16A S.S.Outlet, Circuit From DB Location in Lift Machine Room.

1 No. 25mm Ø PVC Conduit From Basement up to Terrace for Bulk Head Light, Circuit From DB Location in Lift Machine Room.

Note:- In Every Lift Well, Give a 16A Switched Socket Outlet at Alternative Floor Starting From Basement till Terrace Floor and Bulkhead Light to be provided at each floor level.

PROJECT NAME
IIM SHILLONG, UMSAWLI CAMPUS SHILLONG


ARCHITECT
AKSHAYA JAIN & ASSOCIATES
ARCHITECTURE. PLANNING. INTERIOR DESIGN
C-6 / 6098, VASANT KUNJ, NEW DELHI - 110070
TELEPHONES +91-11-26136098, 26132304, 41601615
FAX +91-11-26132304 E-Mail : mail@akshayajain.com

ELECTRICAL SERVICES CONSULTANT
ECMS INDIA PVT. LTD.
WP-21 C-282, BASEMENT
NOIDA SECTOR-71,
UTTAR PRADESH-201307
E-mail: ecms.tech01@gmail.com
URL: www.ecmsindia.com
Ph.No. 0120-3502815

DRAWING TITLE-
EL-POWER LAYOUT (PLAN LEVEL -1)
CONVENTION CENTRE (SITE - 10)-SEMINAR HALL

	FOR APPROVAL		ADVANCE COPY
	TENDER DRAWING		GOOD FOR CONSTRUCTION

DRAWN BY	DEEPAK	REV NO.	RD(25.06.2025)
CKD BY	YASHI	SCALE	1:100(A2)
FIN. YEAR	2024-25	JOB NO.	2516
DRAWING NO.	IIM/ECMS/CON./CENTRE/SEM./LVL.-1/PWR-01		

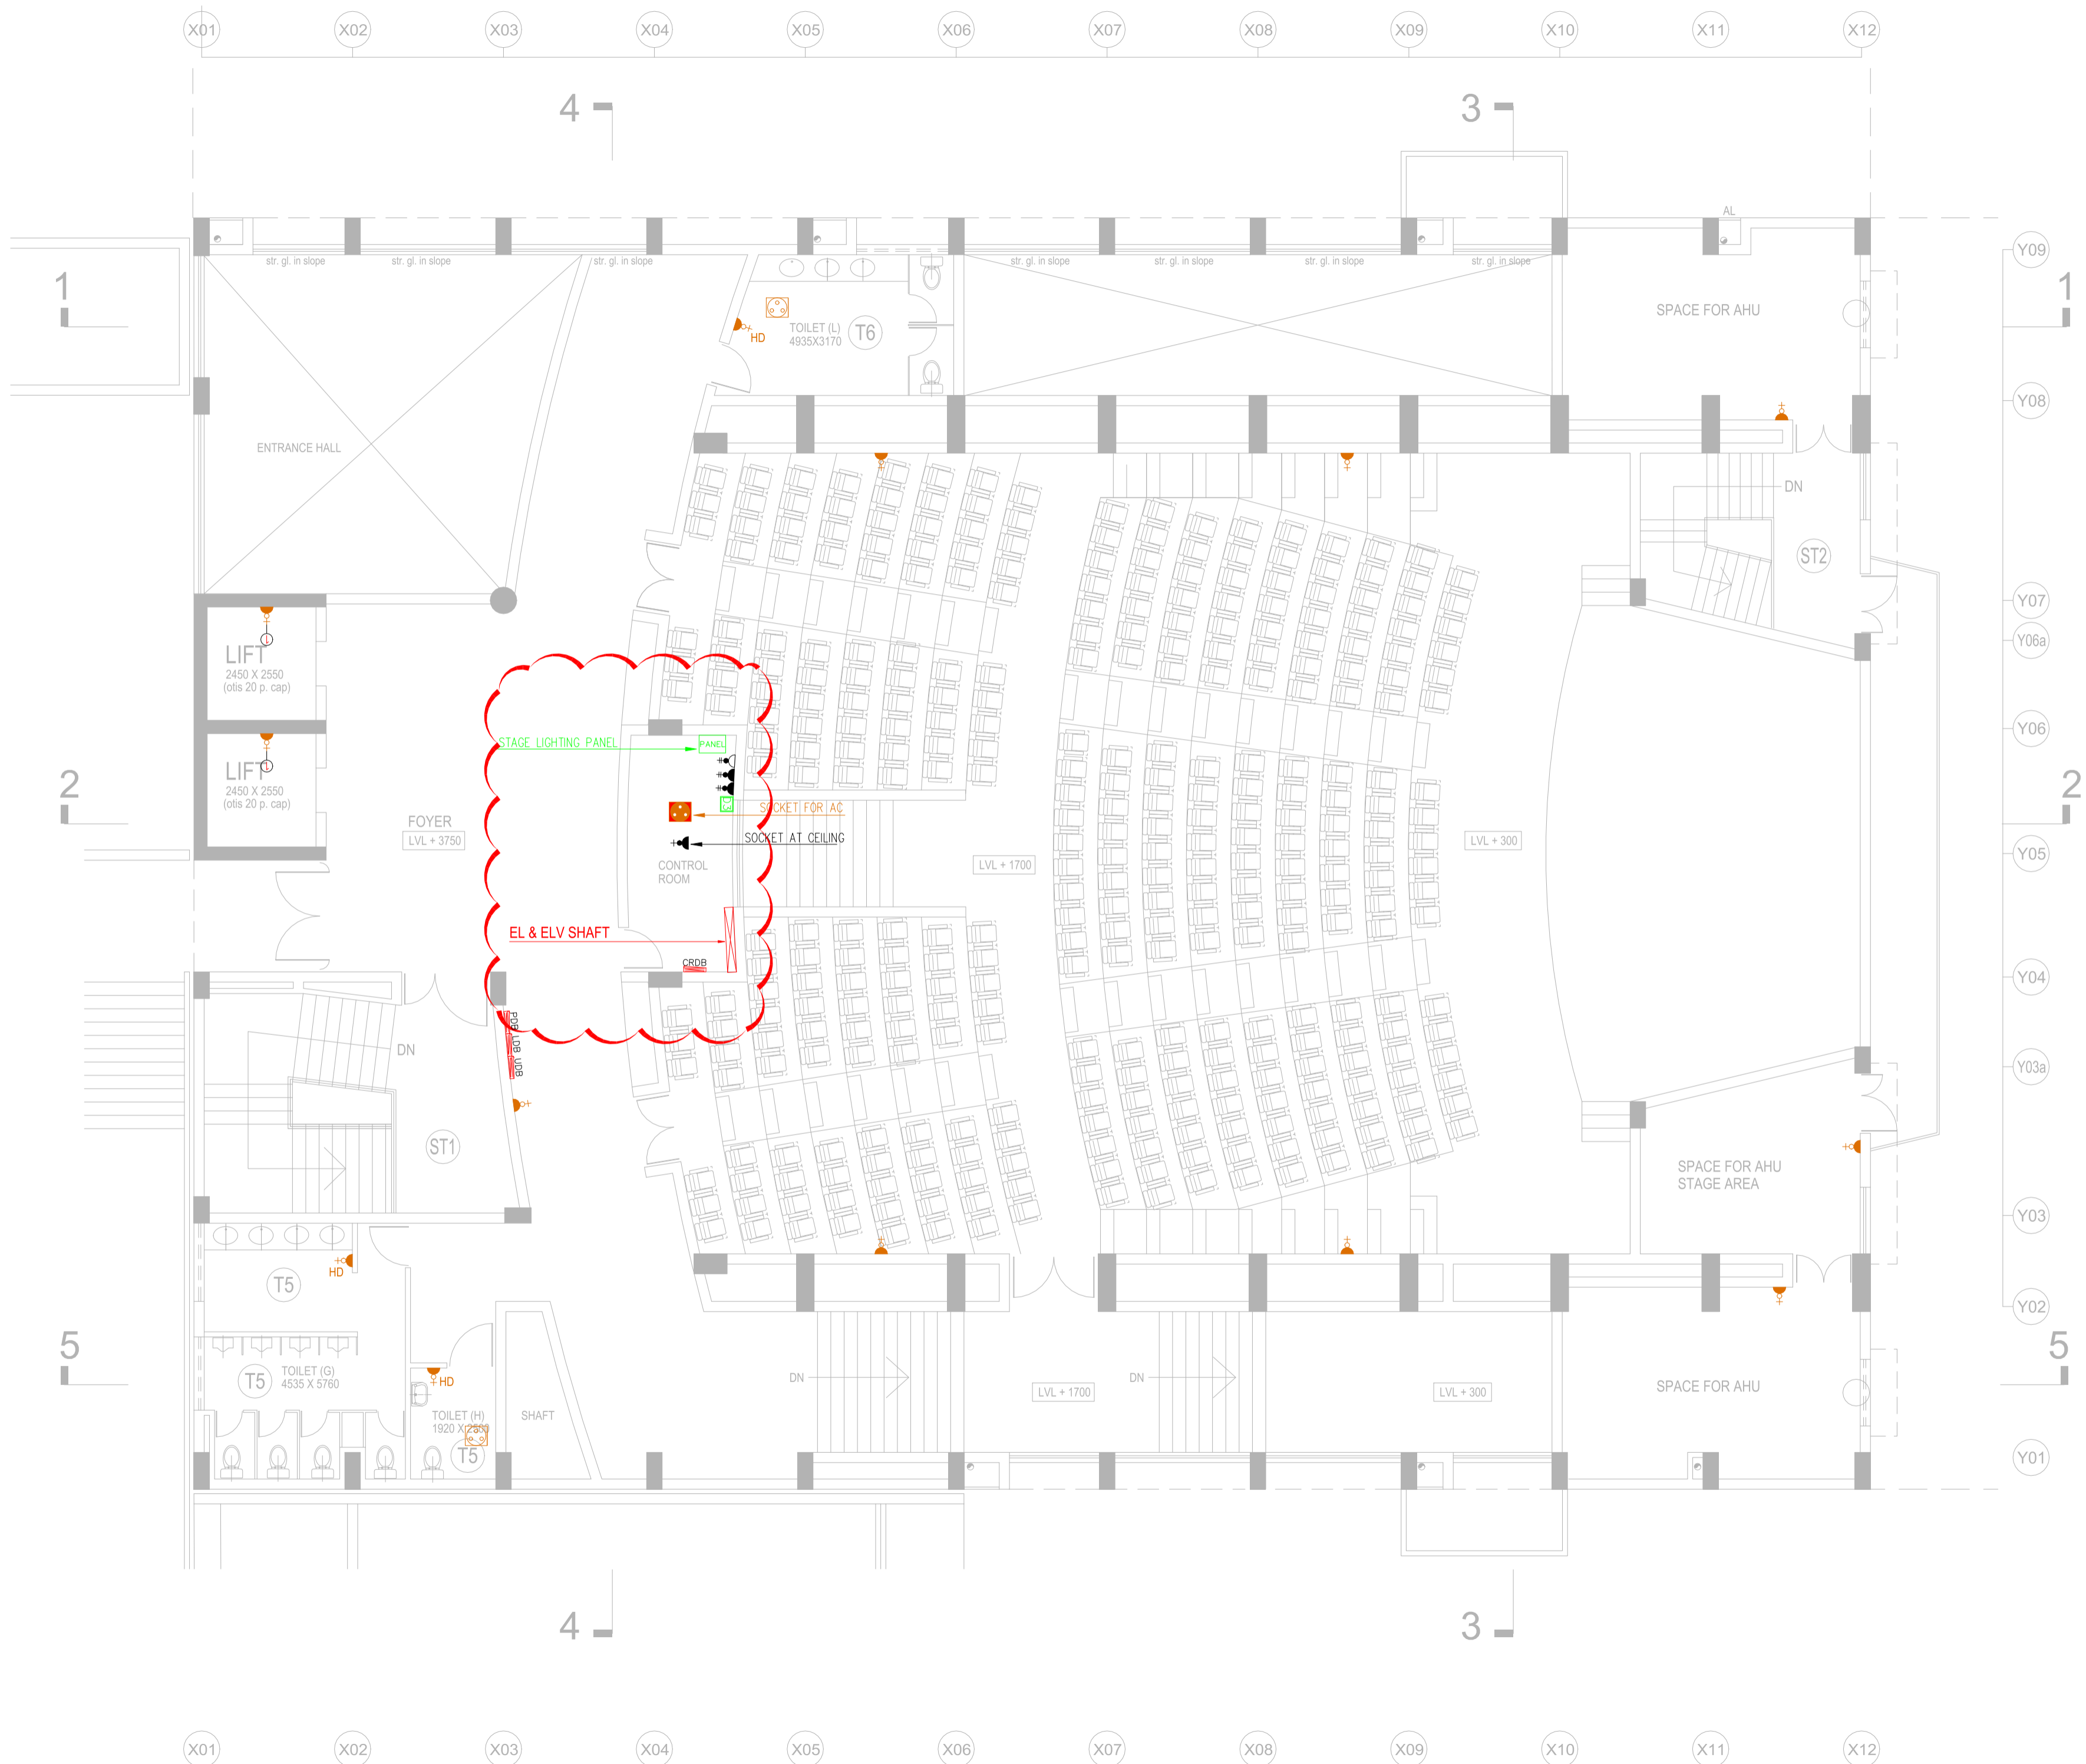

S.NO.	LEGENDS	TABLE
01.		1 NO. 6A SOCKET & 1 NO. 6A SWITCH
02.		2 NOS. 6A (RAW) SOCKET & 2 NOS. 6A SWITCH
03.		1 NO. 16A SOCKET & 1 NO. 16A SWITCH
04.		1 NO. 16A SOCKET & 1 NO. 16A SWITCH FOR HAND DRYER
05.		1 NO. 16A (UPS) SOCKET & 1 NO. 16A SWITCH
06.		3 NOS. DATA OUTLET
07.		1 NO. TELEVISION OUTLET
08.		1 NO. TELEPHONE OUTLET
09.		2 NOS. 6A (UPS) SOCKET & 2 NOS. 6A SWITCH
10.		2 NOS. 6/16A (UPS) SOCKET & 2 NOS. 16A SWITCH
11.		1 NO. HDMI
12.		1 NO. 16A SOCKET FOR INLINE FAN

LEGENDS

2 Nos. 25mm Ø PVC Conduit From Basement up to Terrace for 16A S.S.Outlet, Circuit From DB Location in Lift Machine Room.

1 No. 25mm Ø PVC Conduit From Basement up to Terrace for Bulk Head Light, Circuit From DB Location in Lift Machine Room.

Note:- In Every Lift Well, Give a 16A Switched Socket Outlet at Alternative Floor Starting From Basement till Terrace Floor and Bulkhead Light to be provided at each floor level.

PROJECT NAME
IIM SHILLONG, UMSAWLI CAMPUS SHILLONG

ARCHITECT
AKSHAYA JAIN & ASSOCIATES
ARCHITECTURE. PLANNING. INTERIOR DESIGN
C-6 / 6098, VASANT KUNJ, NEW DELHI - 110070
TELEPHONES +91-11-26136098, 26132304, 41601615
FAX +91-11-26132304 E-Mail : mail@akshayajain.com

ELECTRICAL SERVICES CONSULTANT
**ECMS INDIA PVT. LTD.**
WP-21 C-282, BASEMENT
NOIDA SECTOR-71,
UTTAR PRADESH-201307
E-mail: ecms.tech01@gmail.com
URL: www.ecmsindia.com
Ph.No. 0120-3502815

DRAWING TITLE-
EL-POWER LAYOUT (PLAN LEVEL -2)
CONVENTION CENTRE (SITE - 10)-SEMINAR HALL

<input type="checkbox"/> FOR APPROVAL	<input type="checkbox"/> ADVANCE COPY
<input checked="" type="checkbox"/> TENDER DRAWING	<input type="checkbox"/> GOOD FOR CONSTRUCTION

DRAWN BY	DEEPAK	REV NO.	RD(25.06.2025)
CKD BY	YASHI	SCALE	1:100(A2)
FIN. YEAR	2024-25	JOB NO.	2516
DRAWING NO.	IIM/ECMS/CON./CENTRE/SEM./LVL.-2/PWR-02		



S.NO.	LEGENDS TABLE	
01.		2' x 2' LED PANEL LIGHT
02.		LED CEILING DOWNLIGHT-1
03.		LED CEILING DOWNLIGHT-2
04.		LED CEILING DOWNLIGHT-3
05.		LED CEILING DOWNLIGHT-4
06.		LED CEILING COVE LIGHT
07.		LED WALL MOUNTED BATTEN LIGHT
08.		LED MIRROR LIGHT
09.		BULK HEAD LIGHT
10.		1200MMØ CEILING FAN


PROJECT NAME
IIM SHILLONG, UMSAWLI CAMPUS SHILLONG

ARCHITECT
AKSHAYA JAIN & ASSOCIATES
ARCHITECTURE. PLANNING. INTERIOR DESIGN
C-6 / 6098, VASANT KUNJ, NEW DELHI - 110070
TELEPHONES +91-11-26136098, 26132304, 41601615
FAX +91-11-26132304 E-Mail : mail@akshayajain.com

ELECTRICAL SERVICES CONSULTANT
**ECMS INDIA PVT. LTD.**
WP-21 C-282, BASEMENT
NOIDA SECTOR-71,
UTTAR PRADESH-201307
E-mail: ecms.tech01@gmail.com
URL: www.ecmsindia.com
Ph.No. 0120-3502815

DRAWING TITLE-
EL-LIGHTING LAYOUT (BASEMENT)
CONVENTION CENTRE (SITE - 10)-CAFETERIA

<input type="checkbox"/> FOR APPROVAL	<input type="checkbox"/> ADVANCE COPY
<input checked="" type="checkbox"/> TENDER DRAWING	<input type="checkbox"/> GOOD FOR CONSTRUCTION
DRAWN BY DEEPAK	REV NO. R0(25.06.2025)
CKD BY YASHI	SCALE 1:100(A2)
FIN. YEAR 2024-25	JOB NO. 2516
DRAWING NO.	IIM/ECMS/CON./CENTRE/CAFE./BASE./EL/L-01

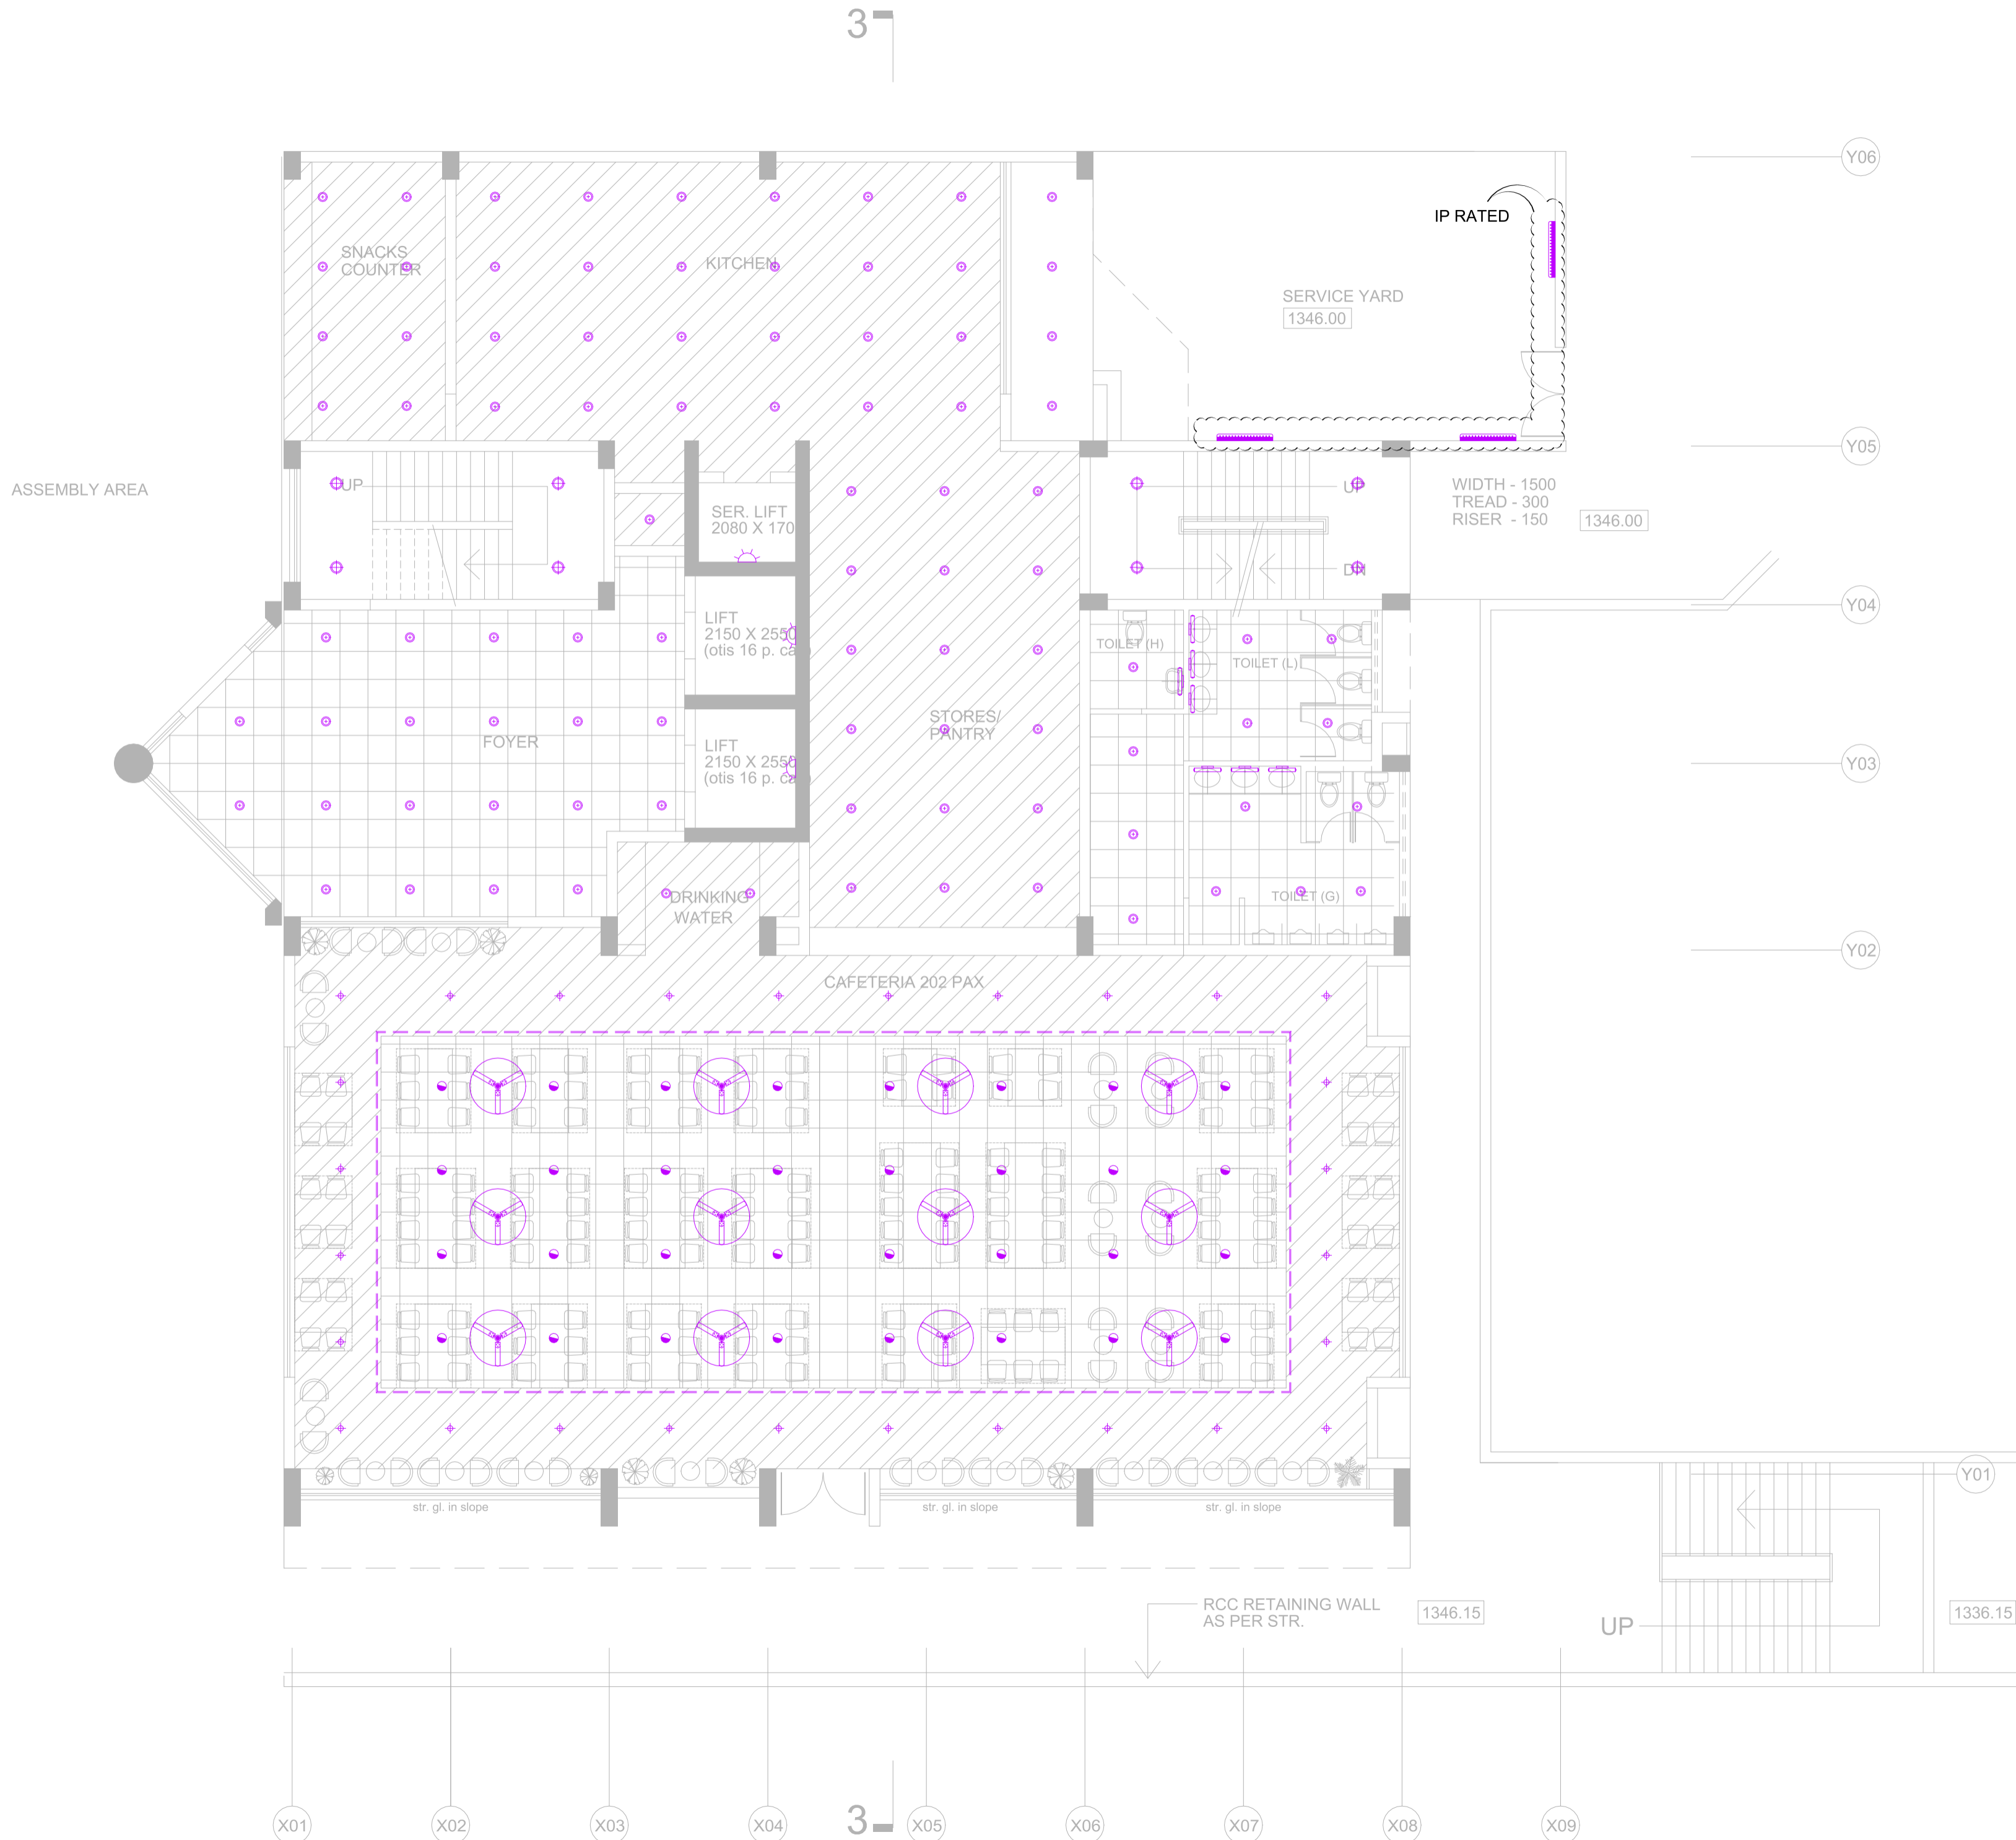

S.NO.	LEGENDS	TABLE
01.		2' x 2' LED PANEL LIGHT
02.		LED CEILING DOWNLIGHT-1
03.		LED CEILING DOWNLIGHT-2
04.		LED CEILING DOWNLIGHT-3
05.		LED CEILING DOWNLIGHT-4
06.		LED CEILING COVE LIGHT
07.		LED WALL MOUNTED BATTEN LIGHT
08.		LED MIRROR LIGHT
09.		BULK HEAD LIGHT
10.		1200MMØ CEILING FAN


PROJECT NAME

IIM SHILLONG, UMSAWLI CAMPUS SHILLONG

ARCHITECT

AKSHAYA JAIN & ASSOCIATES
ARCHITECTURE. PLANNING. INTERIOR DESIGN
C-6 / 6098, VASANT KUNJ, NEW DELHI - 110070
TELEPHONES +91-11-26136098, 26132304, 41601615
FAX +91-11-26132304 E-Mail : mail@akshayajain.com

ELECTRICAL SERVICES CONSULTANT

**ECMS INDIA PVT. LTD.**
WP-21 C-282, BASEMENT
NOIDA SECTOR-71,
UTTAR PRADESH-201307
E-mail: ecms.tech01@gmail.com
URL: www.ecmsindia.com
Ph.No. 0120-3502815

DRAWING TITLE-			
EL-LIGHTING LAYOUT (PLAN LEVEL -1)			
CONVENTION CENTRE (SITE - 10)-CAFETERIA			
<input type="checkbox"/> FOR APPROVAL		<input type="checkbox"/> ADVANCE COPY	
<input checked="" type="checkbox"/> TENDER DRAWING		<input type="checkbox"/> GOOD FOR CONSTRUCTION	
DRAWN BY	DEEPAK	REV NO.	RO(25.06.2025)
CKD BY	YASHI	SCALE	1:100(A2)
FIN. YEAR	2024-25	JOB NO.	2516
DRAWING NO.	IIM/ECMS/CON./CENTRE/CAFE./LVL.-1/EL/L-02		



S.NO.	LEGENDS TABLE	
01.		2' x 2' LED PANEL LIGHT
02.		LED CEILING DOWNLIGHT-1
03.		LED CEILING DOWNLIGHT-2
04.		LED CEILING DOWNLIGHT-3
05.		LED CEILING DOWNLIGHT-4
06.		LED CEILING COVE LIGHT
07.		LED WALL MOUNTED BATTEN LIGHT
08.		LED MIRROR LIGHT
09.		BULK HEAD LIGHT
10.		1200MMØ CEILING FAN

PROJECT NAME
IIM SHILLONG, UMSAWLI CAMPUS SHILLONG

ARCHITECT
AKSHAYA JAIN & ASSOCIATES
ARCHITECTURE. PLANNING. INTERIOR DESIGN
C-6 / 6098, VASANT KUNJ, NEW DELHI - 110070
TELEPHONES +91-11-26136098, 26132304, 41601615
FAX +91-11-26132304 E-Mail : mail@akshayajain.com

ELECTRICAL SERVICES CONSULTANT
**ECMS INDIA PVT. LTD.**
WP-21 C-282, BASEMENT
NOIDA SECTOR-71,
UTTAR PRADESH-201307
E-mail: ecms.tech01@gmail.com
URL: www.ecmsindia.com
Ph.No. 0120-3502815

DRAWING TITLE-
EL-LIGHTING LAYOUT (PLAN LEVEL-2)
CONVENTION CENTRE (SITE - 10)-CONFERENCE

<input type="checkbox"/> FOR APPROVAL	<input type="checkbox"/> ADVANCE COPY
<input checked="" type="checkbox"/> TENDER DRAWING	<input type="checkbox"/> GOOD FOR CONSTRUCTION

DRAWN BY	DEEPAK	REV NO.	RD(25.06.2025)
CKD BY	YASHI	SCALE	1:100(A2)
FIN. YEAR	2024-25	JOB NO.	2516
DRAWING NO.	IIM/ECMS/CON./CENTRE/CON./LVL.-2/EL/L-03		



S.NO.	LEGENDS TABLE	
01.		2' x 2' LED PANEL LIGHT
02.		LED CEILING DOWNLIGHT-1
03.		LED CEILING DOWNLIGHT-2
04.		LED CEILING DOWNLIGHT-3
05.		LED CEILING DOWNLIGHT-4
06.		LED CEILING COVE LIGHT
07.		LED WALL MOUNTED BATTEN LIGHT
08.		LED MIRROR LIGHT
09.		BULK HEAD LIGHT
10.		1200MMØ CEILING FAN


PROJECT NAME
IIM SHILLONG, UMSAWLI CAMPUS SHILLONG

ARCHITECT
AKSHAYA JAIN & ASSOCIATES
ARCHITECTURE. PLANNING. INTERIOR DESIGN
C-6 / 6098, VASANT KUNJ, NEW DELHI - 110070
TELEPHONES +91-11-26136098, 26132304, 41601615
FAX +91-11-26132304 E-Mail : mail@akshayajain.com

ELECTRICAL SERVICES CONSULTANT
**ECMS INDIA PVT. LTD.**
WP-21 C-282, BASEMENT
NOIDA SECTOR-71,
UTTAR PRADESH-201307
E-mail: ecms.tech01@gmail.com
URL: www.ecmsindia.com
Ph.No. 0120-3502815

DRAWING TITLE-
EL-LIGHTING LAYOUT (TERRACE)
CONVENTION CENTRE (SITE - 10)-CONFERENCE

<input type="checkbox"/> FOR APPROVAL	<input type="checkbox"/> ADVANCE COPY
<input checked="" type="checkbox"/> TENDER DRAWING	<input type="checkbox"/> GOOD FOR CONSTRUCTION
DRAWN BY DEEPAK	REV NO. R0(25.06.2025)
CKD BY YASHI	SCALE 1:100(A2)
FIN. YEAR 2024-25	JOB NO. 2516
DRAWING NO.	IIM/ECMS/CON./CENTRE/CON./TER./EL/L-04

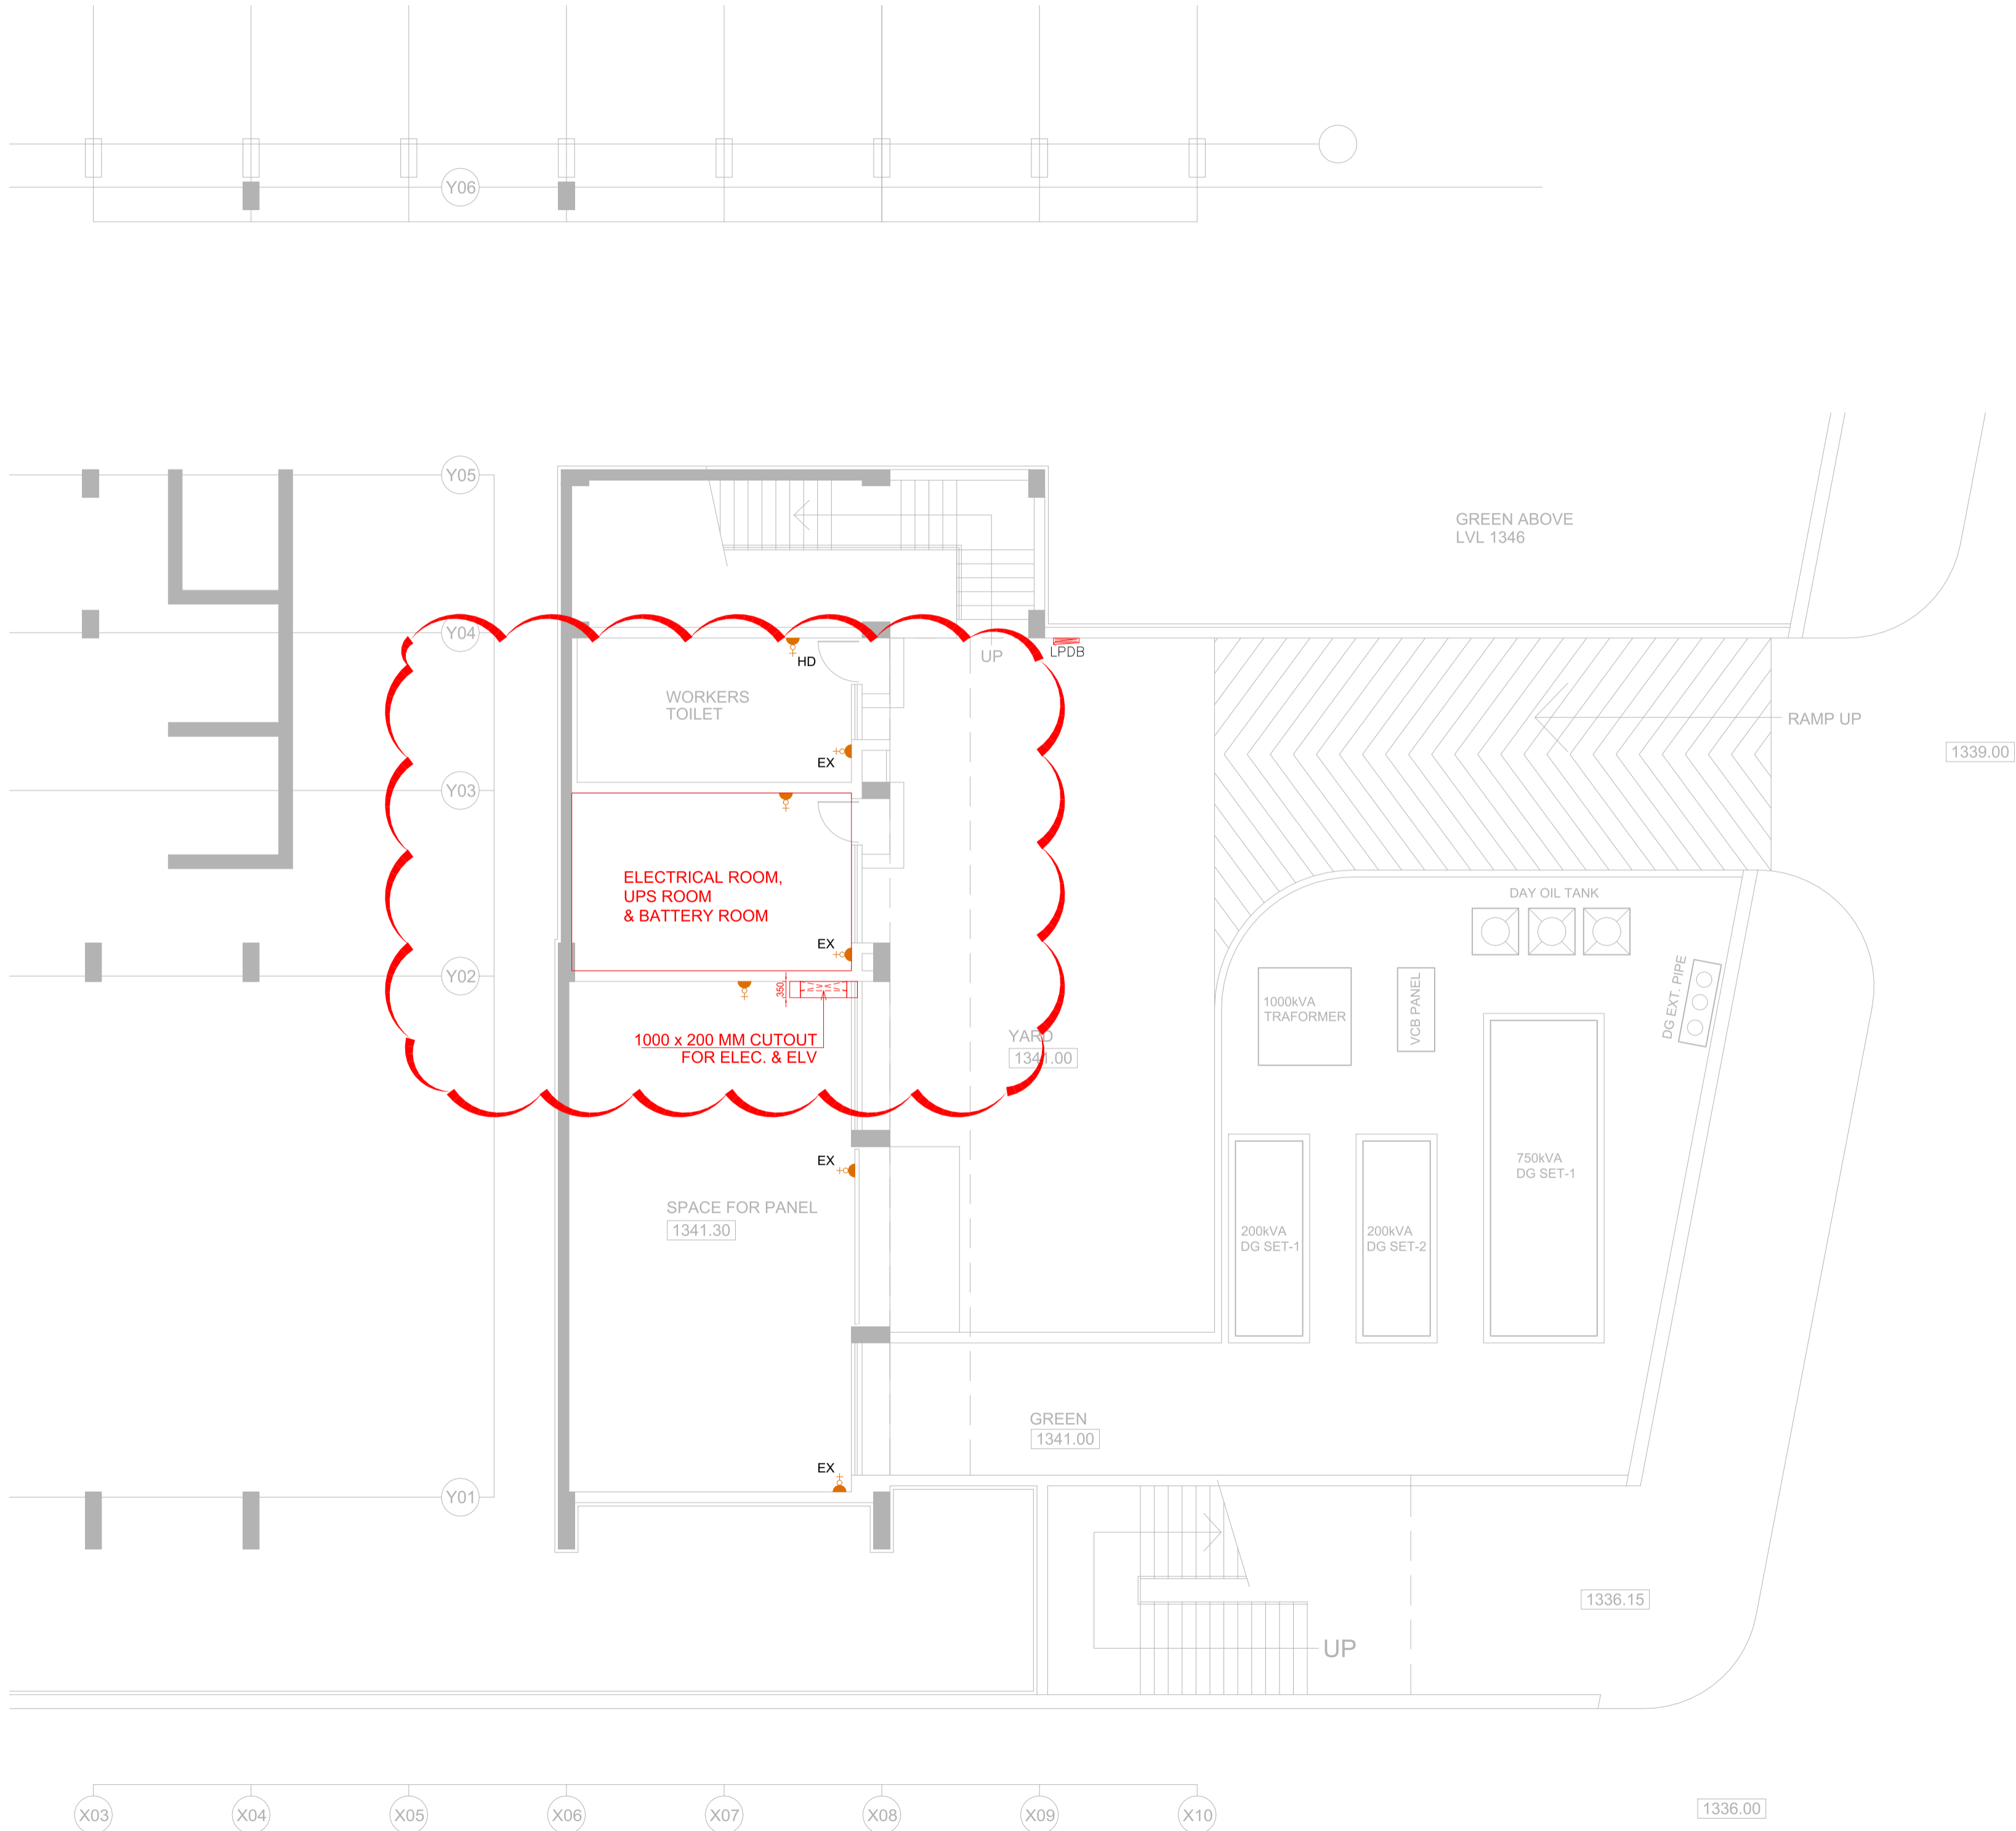

S.NO.	LEGENDS	TABLE
01.		1 NO. 6A SOCKET & 1 NO. 6A SWITCH
02.		1 NO. 6A SOCKET & 1 NO. 6A SWITCH NEAR R.O.
03.		1 NO. 16A SOCKET & 1 NO. 16A SWITCH
04.		1 NO. 16A SOCKET & 1 NO. 16A SWITCH FOR GEYSER
05.		1x20A 5 PIN INDUSTRIAL SOCKET AND PLUG TOP CONTROLLED BY 20A FP MCB
06.		1 NO. DATA OUTLET
07.		2 NO. 6A (UPS) SOCKET & 2 NO. 6A SWITCH
08.		1 NO. 6A (UPS) SOCKET & 1 NO. 6A SWITCH
09.		1 NO. HDMI
10.		1 NO. 16A SOCKET FOR INLINE FAN
11.		1 NO. 16A SOCKET FOR AC
LEGENDS		
	2 Nos. 25mm Ø PVC Conduit From Basement up to Terrace for 16A S.S.Outlet, Circuit From DB Location in Lift Machine Room.	
	1 No. 25mm Ø PVC Conduit From Basement up to Terrace for Bulk Head Light, Circuit From DB Location in Lift Machine Room.	
Note:-	In Every Lift Well, Give a 16A Switched Socket Outlet at Alternative Floor Starting From Basement till Terrace Floor and Bulkhead Light to be provided at each floor level.	

PROJECT NAME
IIM SHILLONG, UMSAWLI CAMPUS SHILLONG

ARCHITECT
AKSHAYA JAIN & ASSOCIATES
ARCHITECTURE. PLANNING. INTERIOR DESIGN
C-6 / 6098, VASANT KUNJ, NEW DELHI - 110070
TELEPHONES +91-11-26136098, 26132304, 41601615
FAX +91-11-26132304 E-Mail : mail@akshayajain.com

ELECTRICAL SERVICES CONSULTANT

ECMS INDIA PVT. LTD.
WP-21 C-282, BASEMENT
NOIDA SECTOR-71,
UTTAR PRADESH-201307
E-mail: ecms.tech01@gmail.com
URL: www.ecmsindia.com
Ph.No. 0120-3502815

DRAWING TITLE-
EL-POWER LAYOUT (BASEMENT)
CONVENTION CENTRE (SITE - 10)


<input type="checkbox"/> FOR APPROVAL	<input type="checkbox"/> ADVANCE COPY
<input checked="" type="checkbox"/> TENDER DRAWING	<input type="checkbox"/> GOOD FOR CONSTRUCTION

DRAWN BY	DEEPAK	REV NO.	RD(25.06.2025)
CKD BY	YASHI	SCALE	1:100(A2)
FIN. YEAR	2024-25	JOB NO.	2516
DRAWING NO.	IIM/ECMS/CON./CENTRE/BASE./LVL./PWR-01		

1

ASSEMBLY AREA
1346.60 (+600)

2

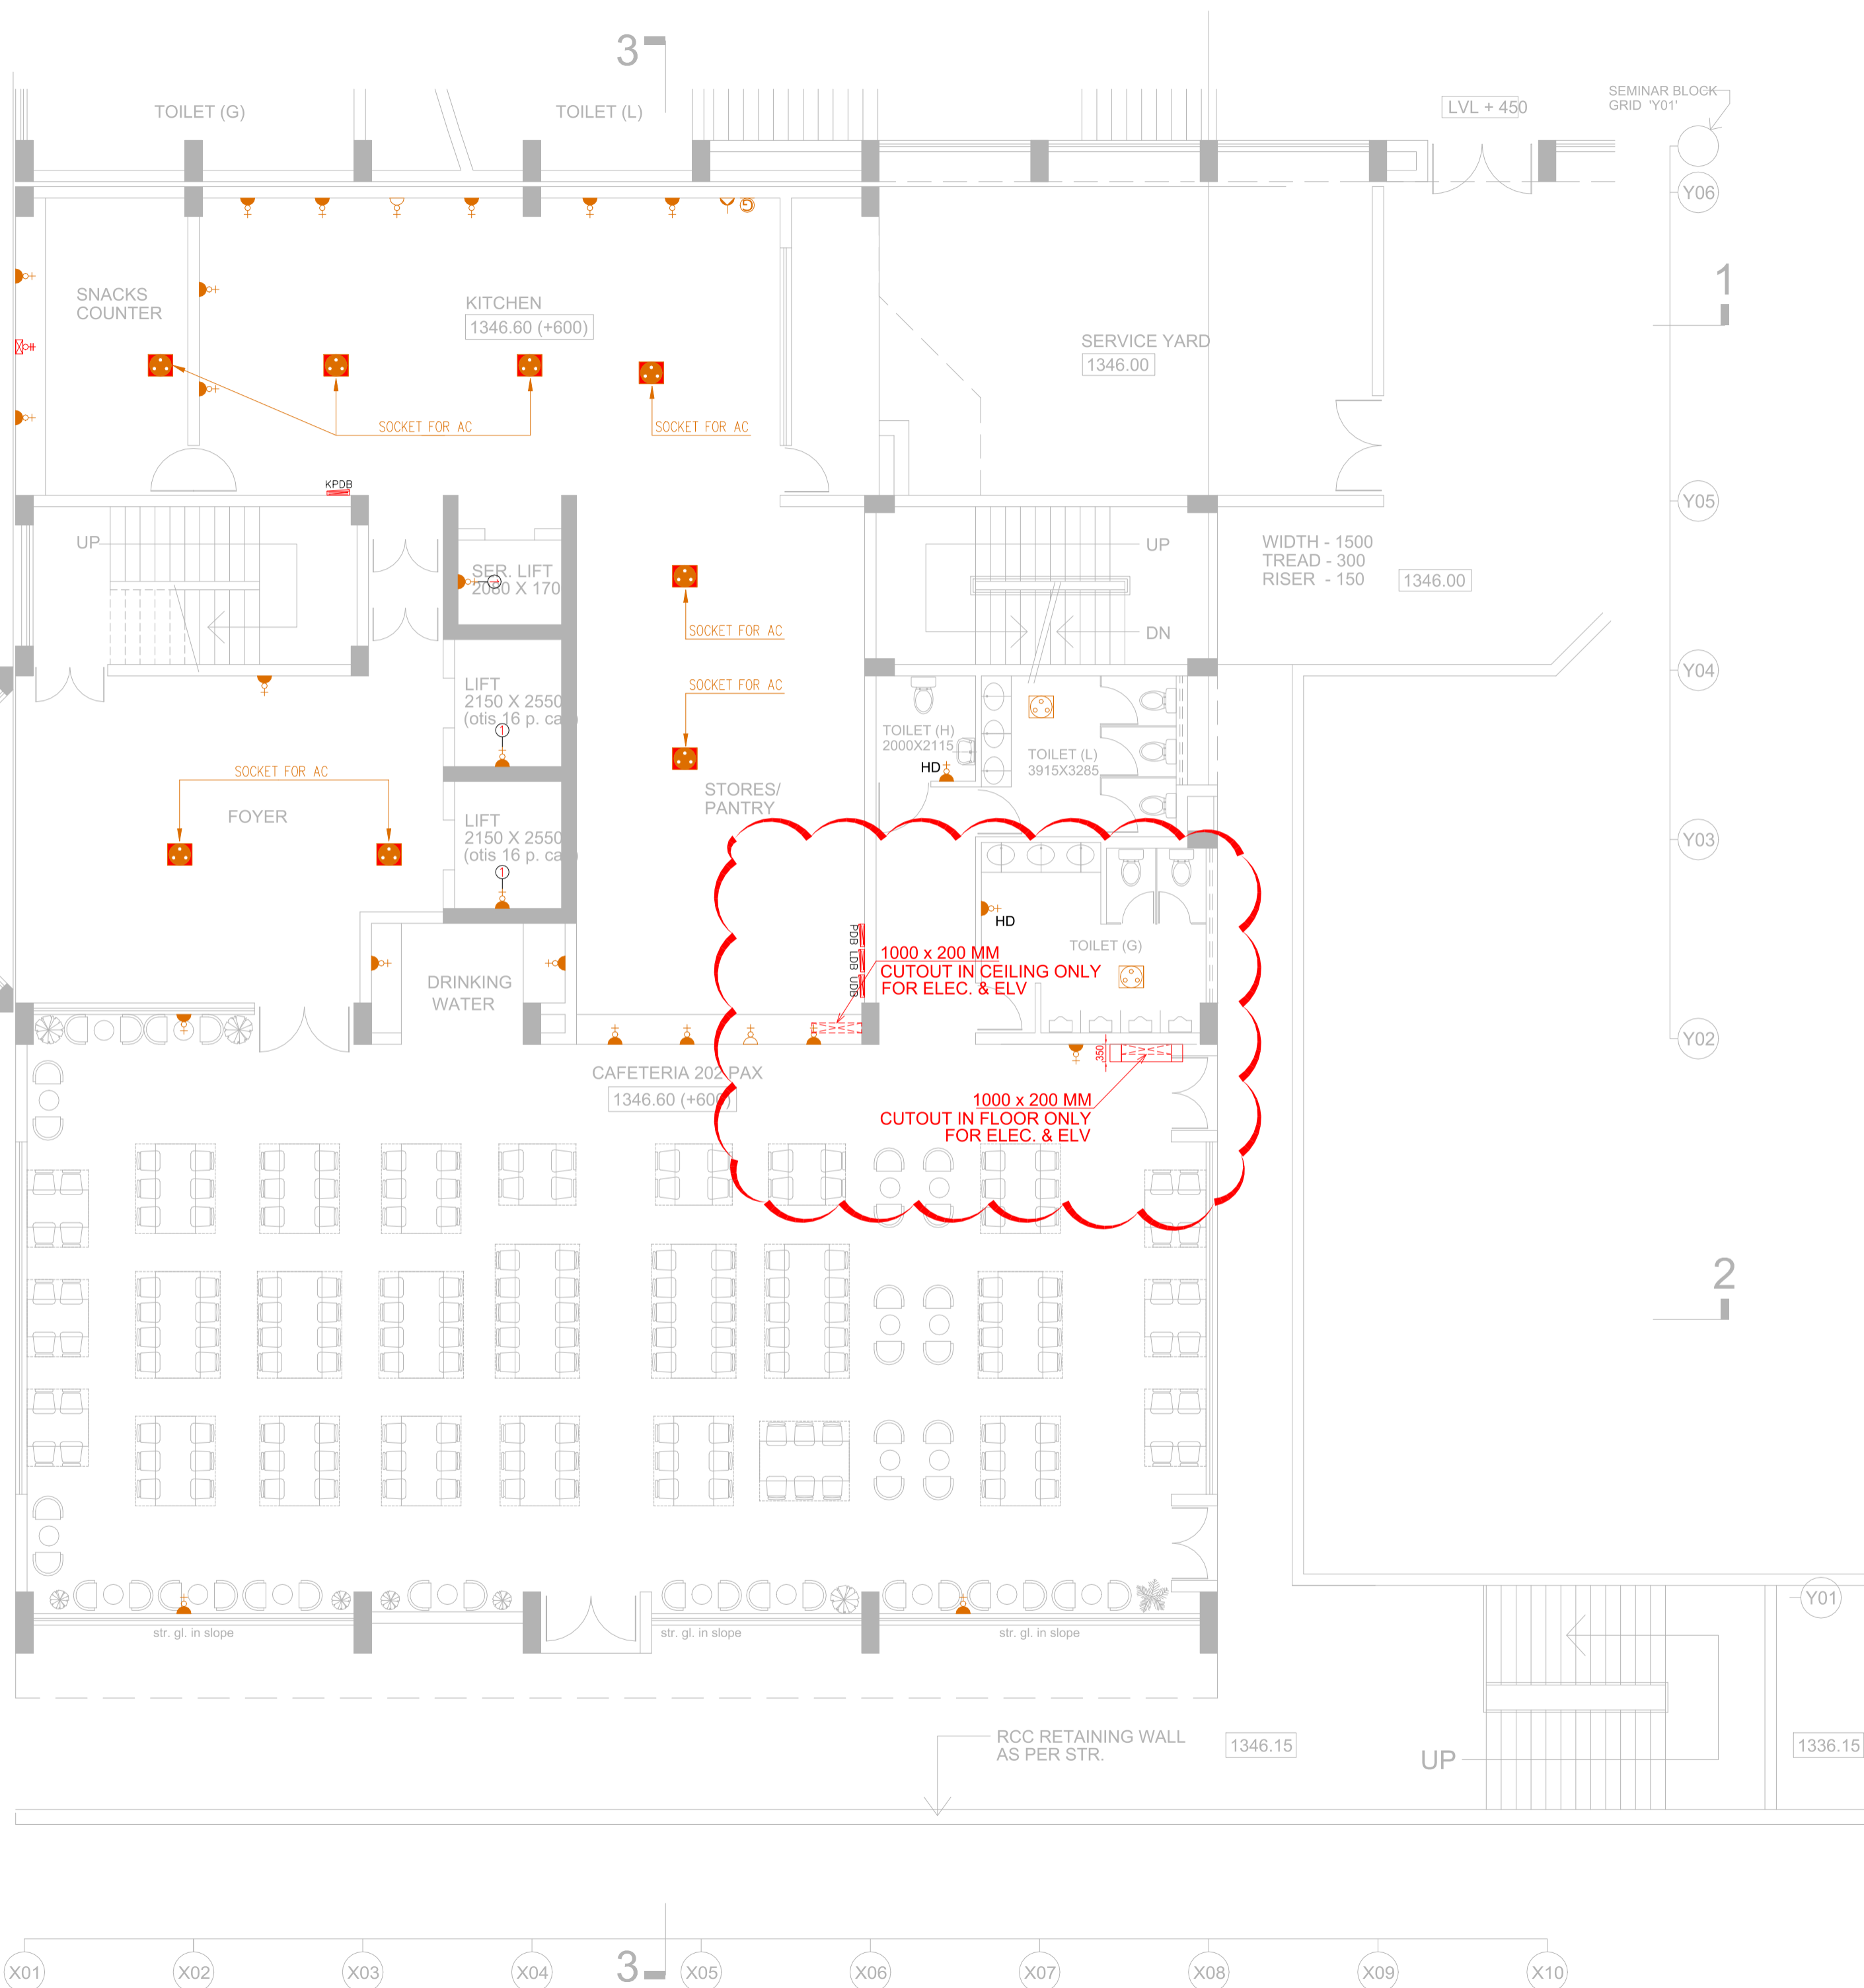

S.NO.		LEGENDS	
TABLE			
01.		1 NO. 6A SOCKET & 1 NO. 6A SWITCH	
02.		1 NO. 6A SOCKET & 1 NO. 6A SWITCH NEAR R.O.	
03.		1 NO. 16A SOCKET & 1 NO. 16A SWITCH	
04.		1 NO. 16A SOCKET & 1 NO. 16A SWITCH FOR GEYSER	
05.		1x20A 5 PIN INDUSTRIAL SOCKET AND PLUG TOP CONTROLLED BY 20A FP MCB	
06.		1 NO. DATA OUTLET	
07.		2 NO. 6A (UPS) SOCKET & 2 NO. 6A SWITCH	
08.		1 NO. 6A (UPS) SOCKET & 1 NO. 6A SWITCH	
09.		1 NO. HDMI	
10.		1 NO. 16A SOCKET FOR INLINE FAN	
11.		1 NO. 16A SOCKET FOR AC	
LEGENDS			
	2 Nos. 25mm Ø PVC Conduit From Basement up to Terrace for 16A S.S.Outlet, Circuit From DB Location in Lift Machine Room.		
	1 No. 25mm Ø PVC Conduit From Basement up to Terrace for Bulk Head Light, Circuit From DB Location in Lift Machine Room.		
Note:-			
In Every Lift Well, Give a 16A Switched Socket Outlet at Alternative Floor Starting From Basement till Terrace Floor and Bulkhead Light to be provided at each floor level.			

PROJECT NAME
IIM SHILLONG, UMSAWLI CAMPUS SHILLONGARCHITECT
AKSHAYA JAIN & ASSOCIATES
ARCHITECTURE. PLANNING. INTERIOR DESIGN
C-6 / 6098, VASANT KUNJ, NEW DELHI - 110070
TELEPHONES +91-11-26136098, 26132304, 41601615
FAX +91-11-26132304 E-Mail : mail@akshayajain.comELECTRICAL SERVICES CONSULTANT
**ECMS INDIA PVT. LTD.**
WP-21 C-282, BASEMENT
NOIDA SECTOR-71,
UTTAR PRADESH-201307
E-mail: ecms.tech01@gmail.com
URL: www.ecmsindia.com
Ph.No. 0120-3502815DRAWING TITLE-
EL-POWER LAYOUT (PLAN LEVEL -1)
CONVENTION CENTRE (SITE - 10)-CAFETERIA

	FOR APPROVAL		ADVANCE COPY
	TENDER DRAWING		GOOD FOR CONSTRUCTION

DRAWN BY DEEPAK REV NO. R0(25.06.2025)

CKD BY YASHI SCALE 1:100(A2)

FIN. YEAR 2024-25 JOB NO. 2516

DRAWING NO. IIM/ECMS/CON./CENTRE/CAFE./LVL.-1/PWR-02



S.NO. LEGENDS TABLE		
01.		1 NO. 6A SOCKET & 1 NO. 6A SWITCH
02.		1 NO. 6A SOCKET & 1 NO. 6A SWITCH NEAR R.O.
03.		1 NO. 16A SOCKET & 1 NO. 16A SWITCH
04.		1 NO. 16A SOCKET & 1 NO. 16A SWITCH FOR GEYSER
05.		1x20A 5 PIN INDUSTRIAL SOCKET AND PLUG TOP CONTROLLED BY 20A FP MCB
06.		1 NO. DATA OUTLET
07.		2 NO. 6A (UPS) SOCKET & 2 NO. 6A SWITCH
08.		1 NO. 6A (UPS) SOCKET & 1 NO. 6A SWITCH
09.		1 NO. HDMI
10.		1 NO. 16A SOCKET FOR INLINE FAN
11.		1 NO. 16A SOCKET FOR AC
S.NO. LEGENDS TABLE		
01.		2 NO. 6A (RAW) SOCKET & 2 NO. 6A SWITCH
		2 NO. 6A (UPS) SOCKET & 2 NO. 6A SWITCH
02.		1 NO. DATA OUTLET
		1 NO. TELEPHONE OUTLET
LEGENDS		
	2 Nos. 25mm Ø PVC Conduit From Basement up to Terrace for 16A S.S.Outlet, Circuit From DB Location in Lift Machine Room.	
	1 No. 25mm Ø PVC Conduit From Basement up to Terrace for Bulk Head Light, Circuit From DB Location in Lift Machine Room.	
Note:- In Every Lift Well, Give a 16A Switched Socket Outlet at Alternative Floor Starting From Basement till Terrace Floor and Bulkhead Light to be provided at each floor level.		

PROJECT NAME
IIM SHILLONG, UMSAWLI CAMPUS SHILLONG


ARCHITECT
AKSHAYA JAIN & ASSOCIATES
ARCHITECTURE. PLANNING. INTERIOR DESIGN
C-6 / 6098, VASANT KUNJ, NEW DELHI - 110070
TELEPHONES +91-11-26136098, 26132304, 41601615
FAX +91-11-26132304 E-Mail : mail@akshayajain.com

ELECTRICAL SERVICES CONSULTANT
**ECMS INDIA PVT. LTD.**
WP-21 C-282, BASEMENT
NOIDA SECTOR-71,
UTTAR PRADESH-201307
E-mail: ecms.tech01@gmail.com
URL: www.ecmsindia.com
Ph.No. 0120-3502815

DRAWING TITLE-
EL-POWER LAYOUT (PLAN LEVEL-2)
CONVENTION CENTRE (SITE - 10)-CONFERENCE

	FOR APPROVAL		ADVANCE COPY
	TENDER DRAWING		GOOD FOR CONSTRUCTION

DRAWN BY	DEEPAK	REV NO.	RD(25.06.2025)
CKD BY	YASHI	SCALE	1:100(A2)
FIN. YEAR	2024-25	JOB NO.	2516
DRAWING NO.	IIM/ECMS/CON./CENTRE/CON./LVL-2/PWR-03		

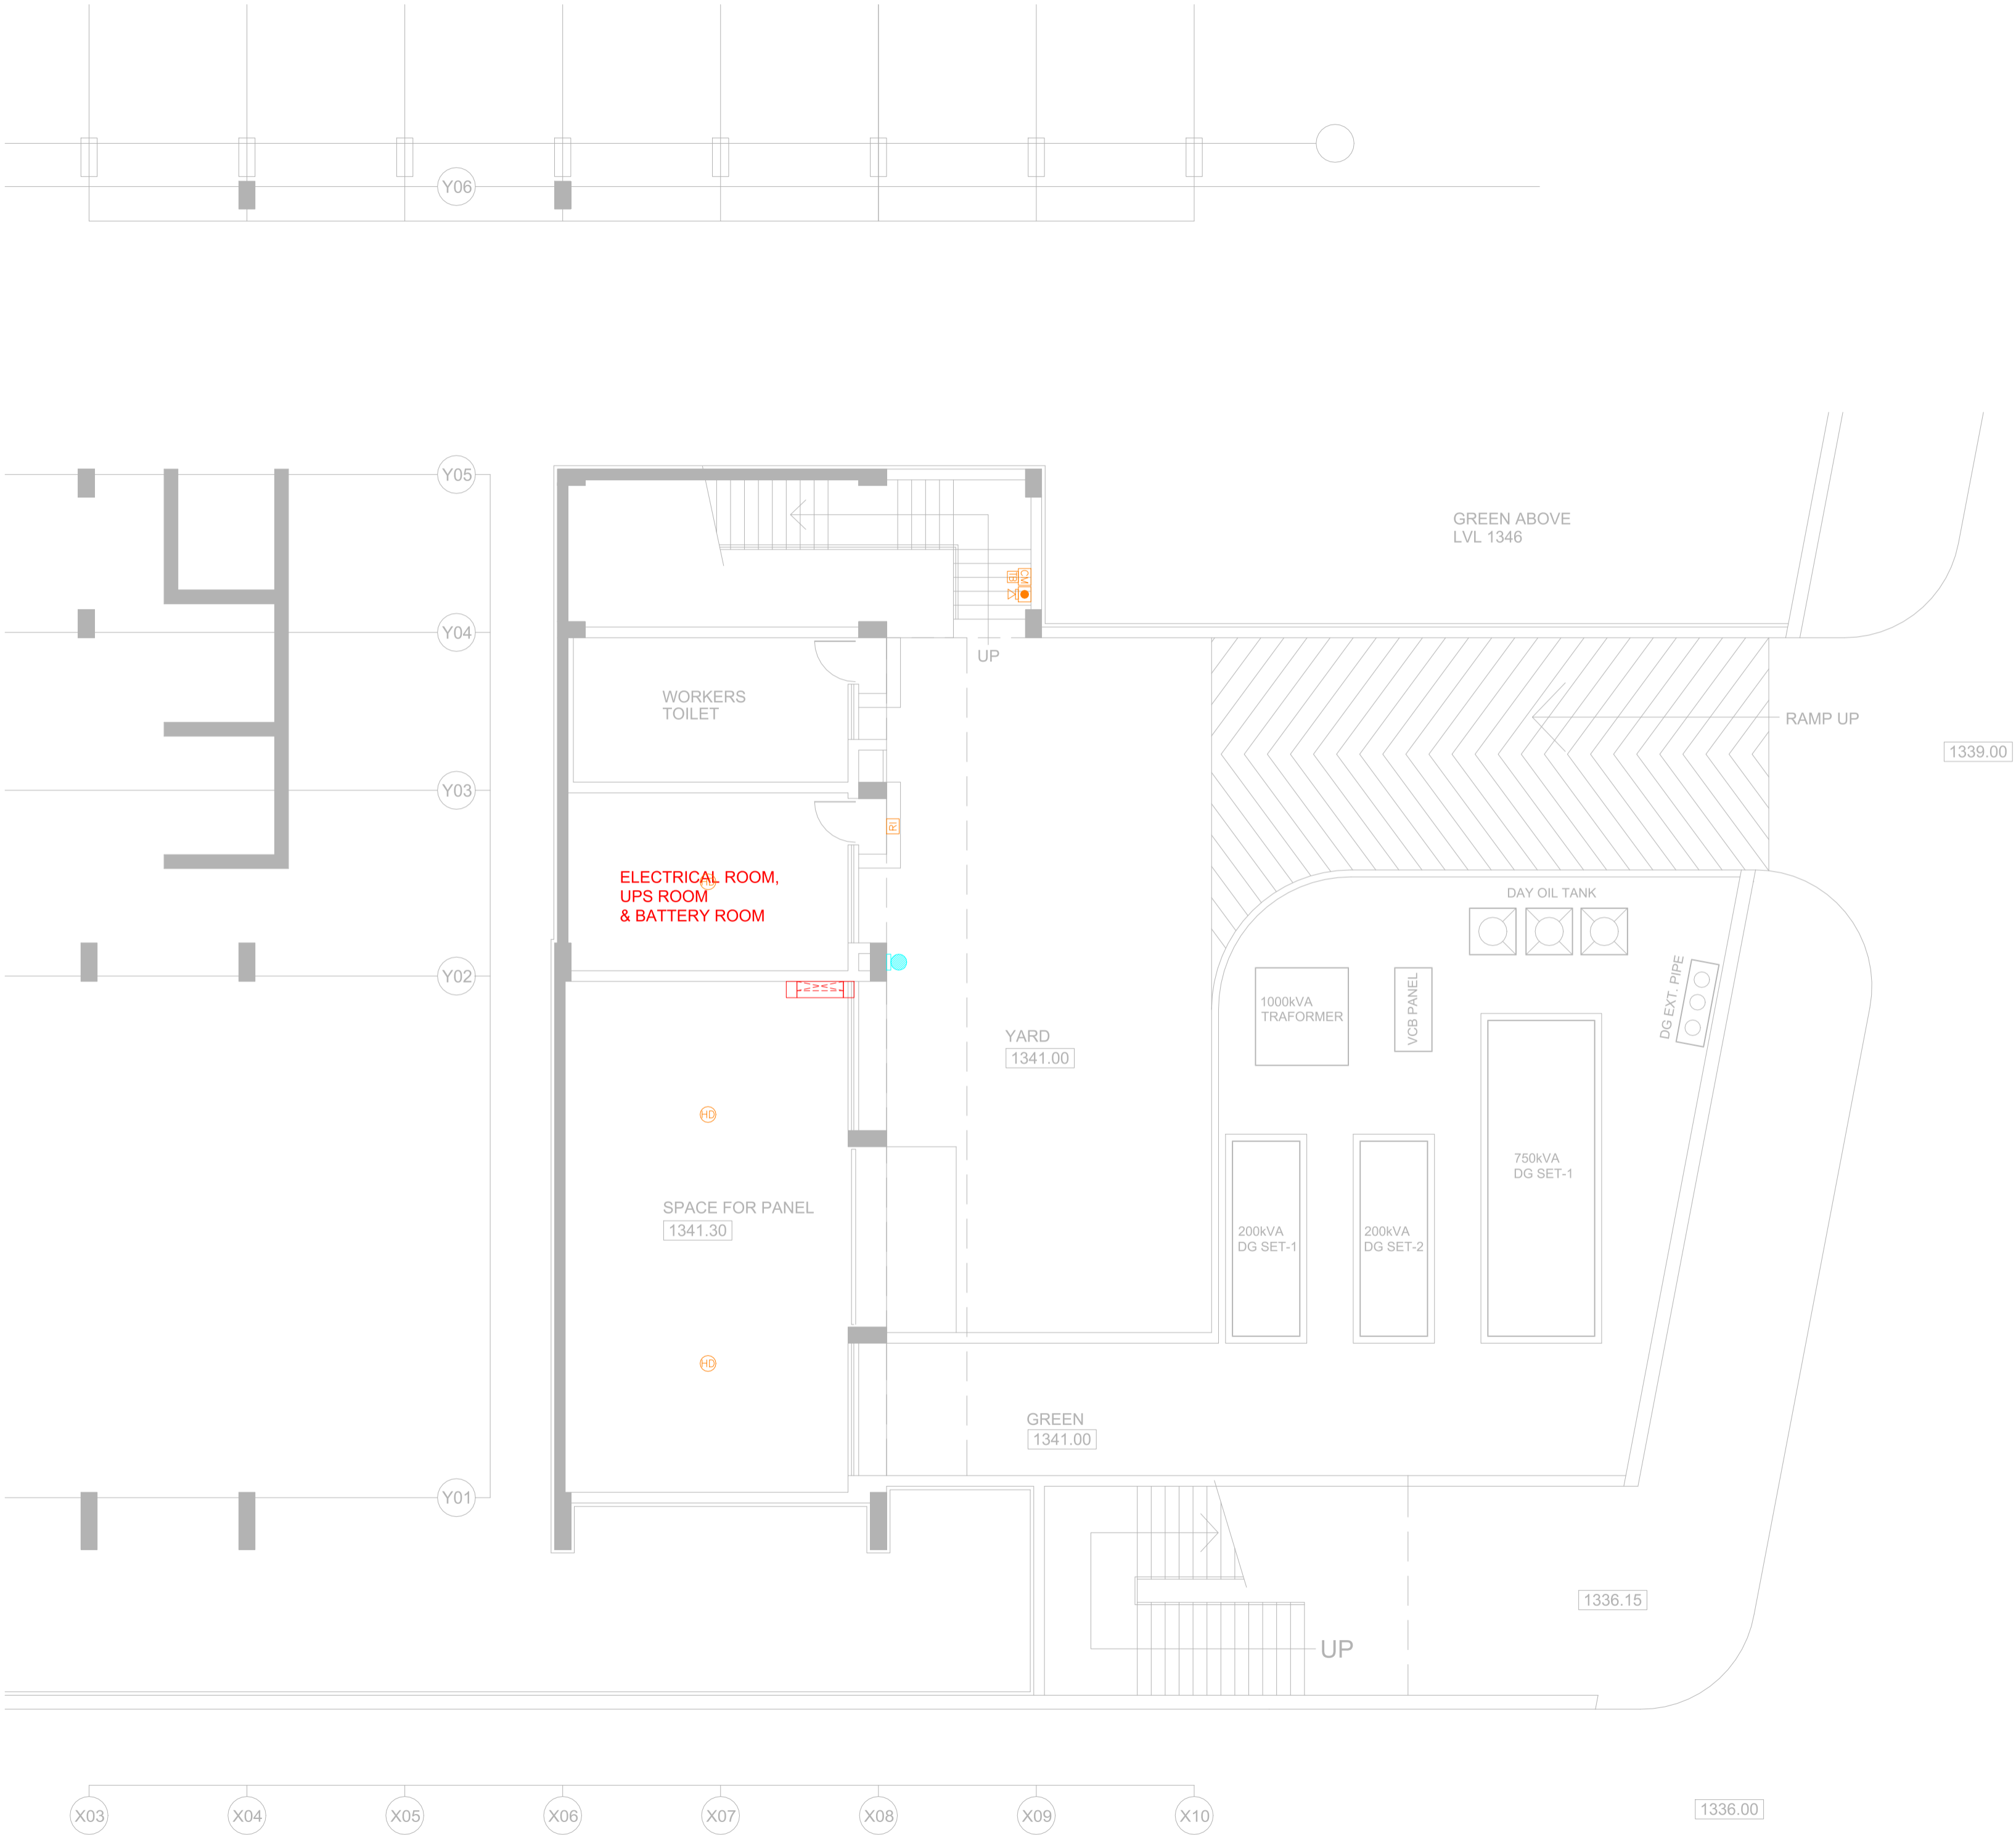

S.NO.	LEGENDS TABLE FIRE ALARM SYSTEM
01.	FIRE ALARM CONTROL PANEL
02.	SMOKE DETECTOR ON FALSE CEILING
03.	SMOKE DETECTOR ON SLAB
04.	HEAT DETECTOR ON SLAB
05.	MANUAL CALL POINT DEVICE
06.	RESPONSE INDICATOR
07.	HOOTER CUM STROBE
08.	CONTROL MODULE DEVICE
09.	MONITOR MODULE DEVICE @FHC's SHAFT
10.	FAULT ISOLATOR DEVICE AS PER LOOP @25D
11.	RELAY MODULE DEVICE
12.	BEAM DETECTOR
13.	BEAM RECEIVER
14.	TALK BACK DEVICE

S.NO.	LEGENDS TABLE CCTV SYSTEM
01.	NETWORK VIDEO RECORDER AS PER SITE
02.	DOME CAMERA
03.	BULLET CAMERA
04.	PTZ CAMERA

S.NO.	LEGENDS TABLE PUBLIC ADDRESS SYSTEM
01.	AMPLIFIER UNIT
02.	CEILING MOUNTED SPEAKER
03.	WALL MOUNTED SPEAKER
04.	MICROPHONE
05.	VOLUME CONTROLLER

PROJECT NAME
IIM SHILLONG, UMSAWLI CAMPUS SHILLONG


ARCHITECT
AKSHAYA JAIN & ASSOCIATES
ARCHITECTURE. PLANNING. INTERIOR DESIGN
C-6 / 6098, VASANT KUNJ, NEW DELHI - 110070
TELEPHONES +91-11-26136098, 26132304, 41601615
FAX +91-11-26132304 E-Mail : mail@akshayajain.com

ELECTRICAL SERVICES CONSULTANT
ECMS INDIA PVT. LTD.
WP-21 C-282, BASEMENT
NOIDA SECTOR-71,
UTTAR PRADESH-201307
E-mail: ecms.tech01@gmail.com
URL: www.ecmsindia.com
Ph.No. 0120-3502815

DRAWING TITLE-
ELV- FAS, PAS & CCTV LAYOUT (BASEMENT)
CONVENTION CENTRE (SITE - 10)-CAFETERIA

<input type="checkbox"/> FOR APPROVAL	<input type="checkbox"/> ADVANCE COPY
<input checked="" type="checkbox"/> TENDER DRAWING	<input type="checkbox"/> GOOD FOR CONSTRUCTION
DRAWN BY DEEPAK	REV NO. R0(25.06.2025)
CKD BY YASHI	SCALE 1:100(A2)
FIN. YEAR 2024-25	JOB NO. 2516
DRAWING NO. IIM/ECMS/CON./CENTRE/CAFE./BASE./FAS/PAS/CCTV-01	

ASSEMBLY AREA

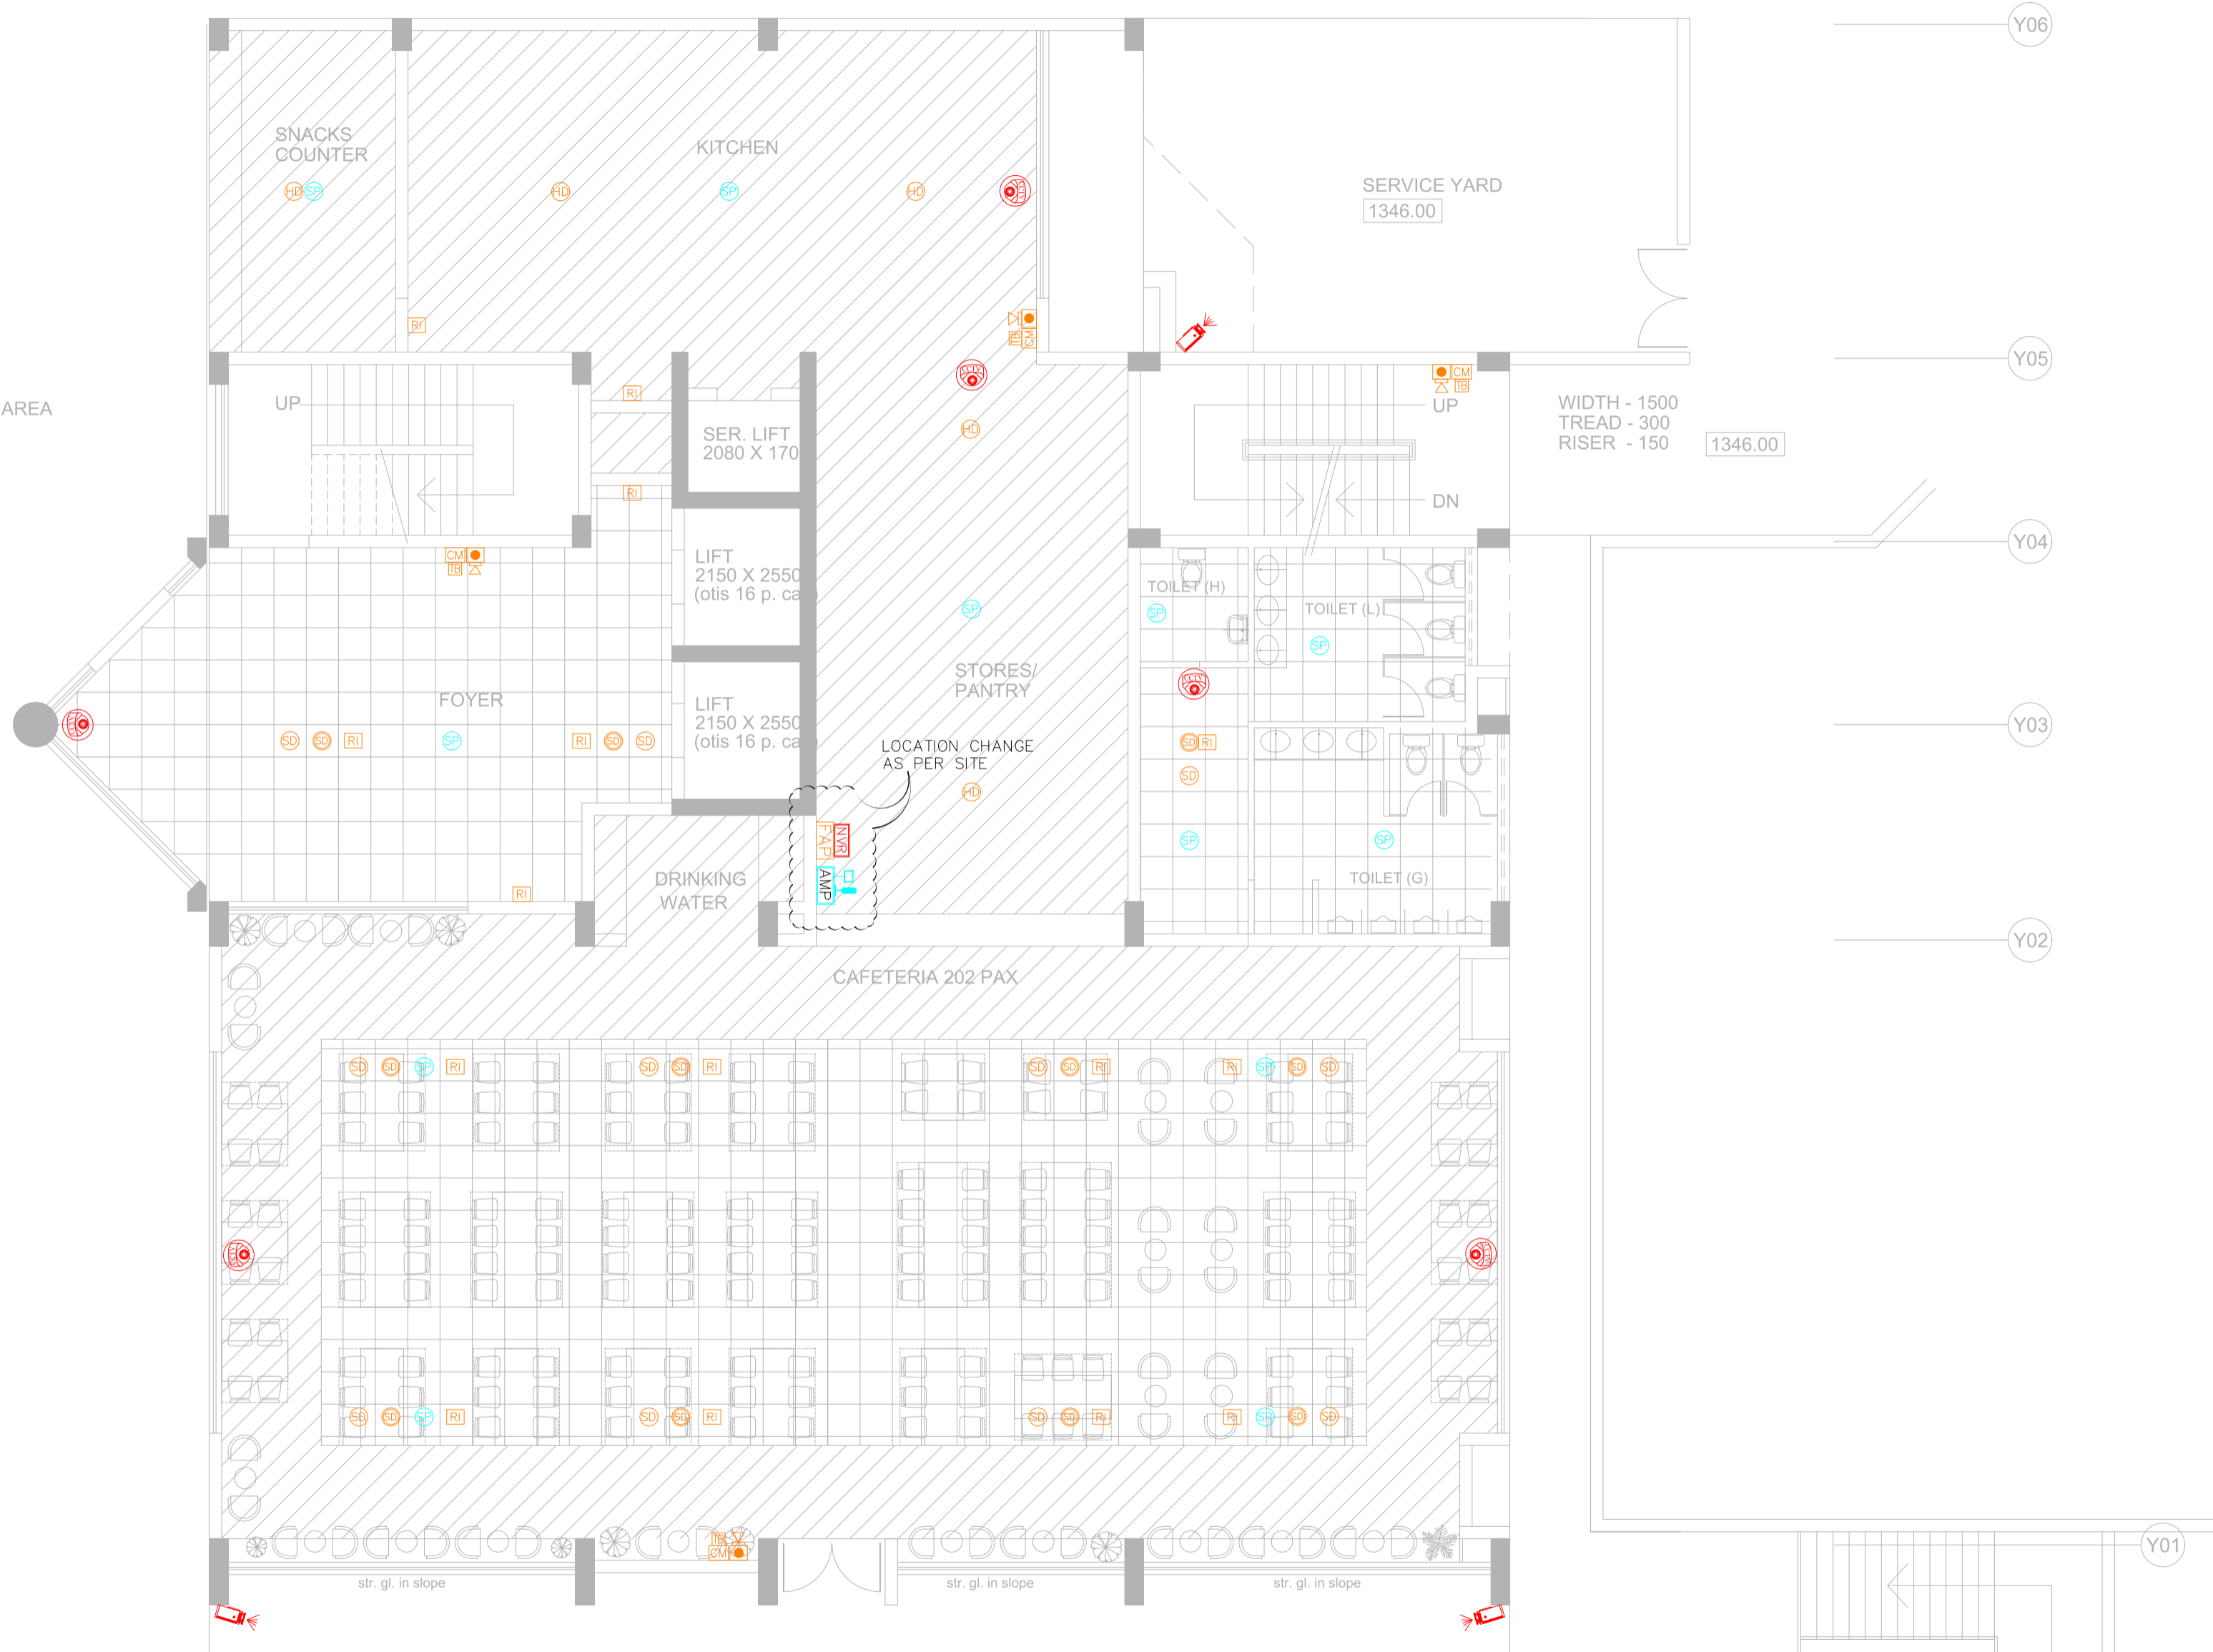

RCC RETAINING WALL
AS PER STR.

1346.15

UP

1336.15

S.NO.	LEGENDS TABLE FIRE ALARM SYSTEM
01.	FIRE ALARM CONTROL PANEL
02.	SMOKE DETECTOR ON FALSE CEILING
03.	SMOKE DETECTOR ON SLAB
04.	HEAT DETECTOR ON SLAB
05.	MANUAL CALL POINT DEVICE
06.	RESPONSE INDICATOR
07.	HOOTER CUM STROBE
08.	CONTROL MODULE DEVICE
09.	MONITOR MODULE DEVICE @FHC's SHAFT
10.	FAULT ISOLATOR DEVICE AS PER LOOP @25D
11.	RELAY MODULE DEVICE
12.	BEAM DETECTOR
13.	BEAM RECEIVER
14.	TALK BACK DEVICE

S.NO.	LEGENDS TABLE CCTV SYSTEM
01.	NETWORK VIDEO RECORDER AS PER SITE
02.	DOME CAMERA
03.	BULLET CAMERA
04.	PTZ CAMERA

S.NO.	LEGENDS TABLE PUBLIC ADDRESS SYSTEM
01.	AMPLIFIER UNIT
02.	CEILING MOUNTED SPEAKER
03.	WALL MOUNTED SPEAKER
04.	MICROPHONE
05.	VOLUME CONTROLLER

PROJECT NAME
IIM SHILLONG, UMSAWLI CAMPUS SHILLONG

ARCHITECT
AKSHAYA JAIN & ASSOCIATES
ARCHITECTURE. PLANNING. INTERIOR DESIGN
C-6 / 6098, VASANT KUNJ, NEW DELHI - 110070
TELEPHONES +91-11-26136098, 26132304, 41601615
FAX +91-11-26132304 E-Mail : mail@akshayajain.com

ELECTRICAL SERVICES CONSULTANT
ECMS INDIA PVT. LTD.
WP-21 C-282, BASEMENT
NOIDA SECTOR-71,
UTTAR PRADESH-201307
E-mail: ecms.tech01@gmail.com
URL: www.ecmsindia.com
Ph.No. 0120-3502815

DRAWING TITLE-
ELV- FAS, PAS & CCTV LAYOUT (PLAN LEVEL -1)
CONVENTION CENTRE (SITE - 10)-CAFETERIA

FOR APPROVAL	ADVANCE COPY
TENDER DRAWING	GOOD FOR CONSTRUCTION

DRAWN BY	DEEPAK	REV NO.	RD(25.06.2025)
CKD BY	YASHI	SCALE	1:100(A2)
FIN. YEAR	2024-25	JOB NO.	2516
DRAWING NO.	IIM/ECMS/CON./CENTRE/CAFE./LVL.-1/FAS/PAS/CCTV-02		



S.NO.	LEGENDS TABLE FIRE ALARM SYSTEM
01.	FIRE ALARM CONTROL PANEL
02.	SMOKE DETECTOR ON FALSE CEILING
03.	SMOKE DETECTOR ON SLAB
04.	HEAT DETECTOR ON SLAB
05.	MANUAL CALL POINT DEVICE
06.	RESPONSE INDICATOR
07.	HOOTER CUM STROBE
08.	CONTROL MODULE DEVICE
09.	MONITOR MODULE DEVICE @FHC's SHAFT
10.	FAULT ISOLATOR DEVICE AS PER LOOP @25D
11.	RELAY MODULE DEVICE
12.	BEAM DETECTOR
13.	BEAM RECEIVER
14.	TALK BACK DEVICE

S.NO.	LEGENDS TABLE CCTV SYSTEM
01.	NETWORK VIDEO RECORDER AS PER SITE
02.	DOME CAMERA
03.	BULLET CAMERA
04.	PTZ CAMERA

S.NO.	LEGENDS TABLE PUBLIC ADDRESS SYSTEM
01.	AMPLIFIER UNIT
02.	CEILING MOUNTED SPEAKER
03.	WALL MOUNTED SPEAKER
04.	MICROPHONE
05.	VOLUME CONTROLLER

PROJECT NAME
IIM SHILLONG, UMSAWLI CAMPUS SHILLONG

ARCHITECT
AKSHAYA JAIN & ASSOCIATES
ARCHITECTURE. PLANNING. INTERIOR DESIGN
C-6 / 6098, VASANT KUNJ, NEW DELHI - 110070
TELEPHONES +91-11-26136098, 26132304, 41601615
FAX +91-11-26132304 E-Mail : mail@akshayajain.com


ELECTRICAL SERVICES CONSULTANT









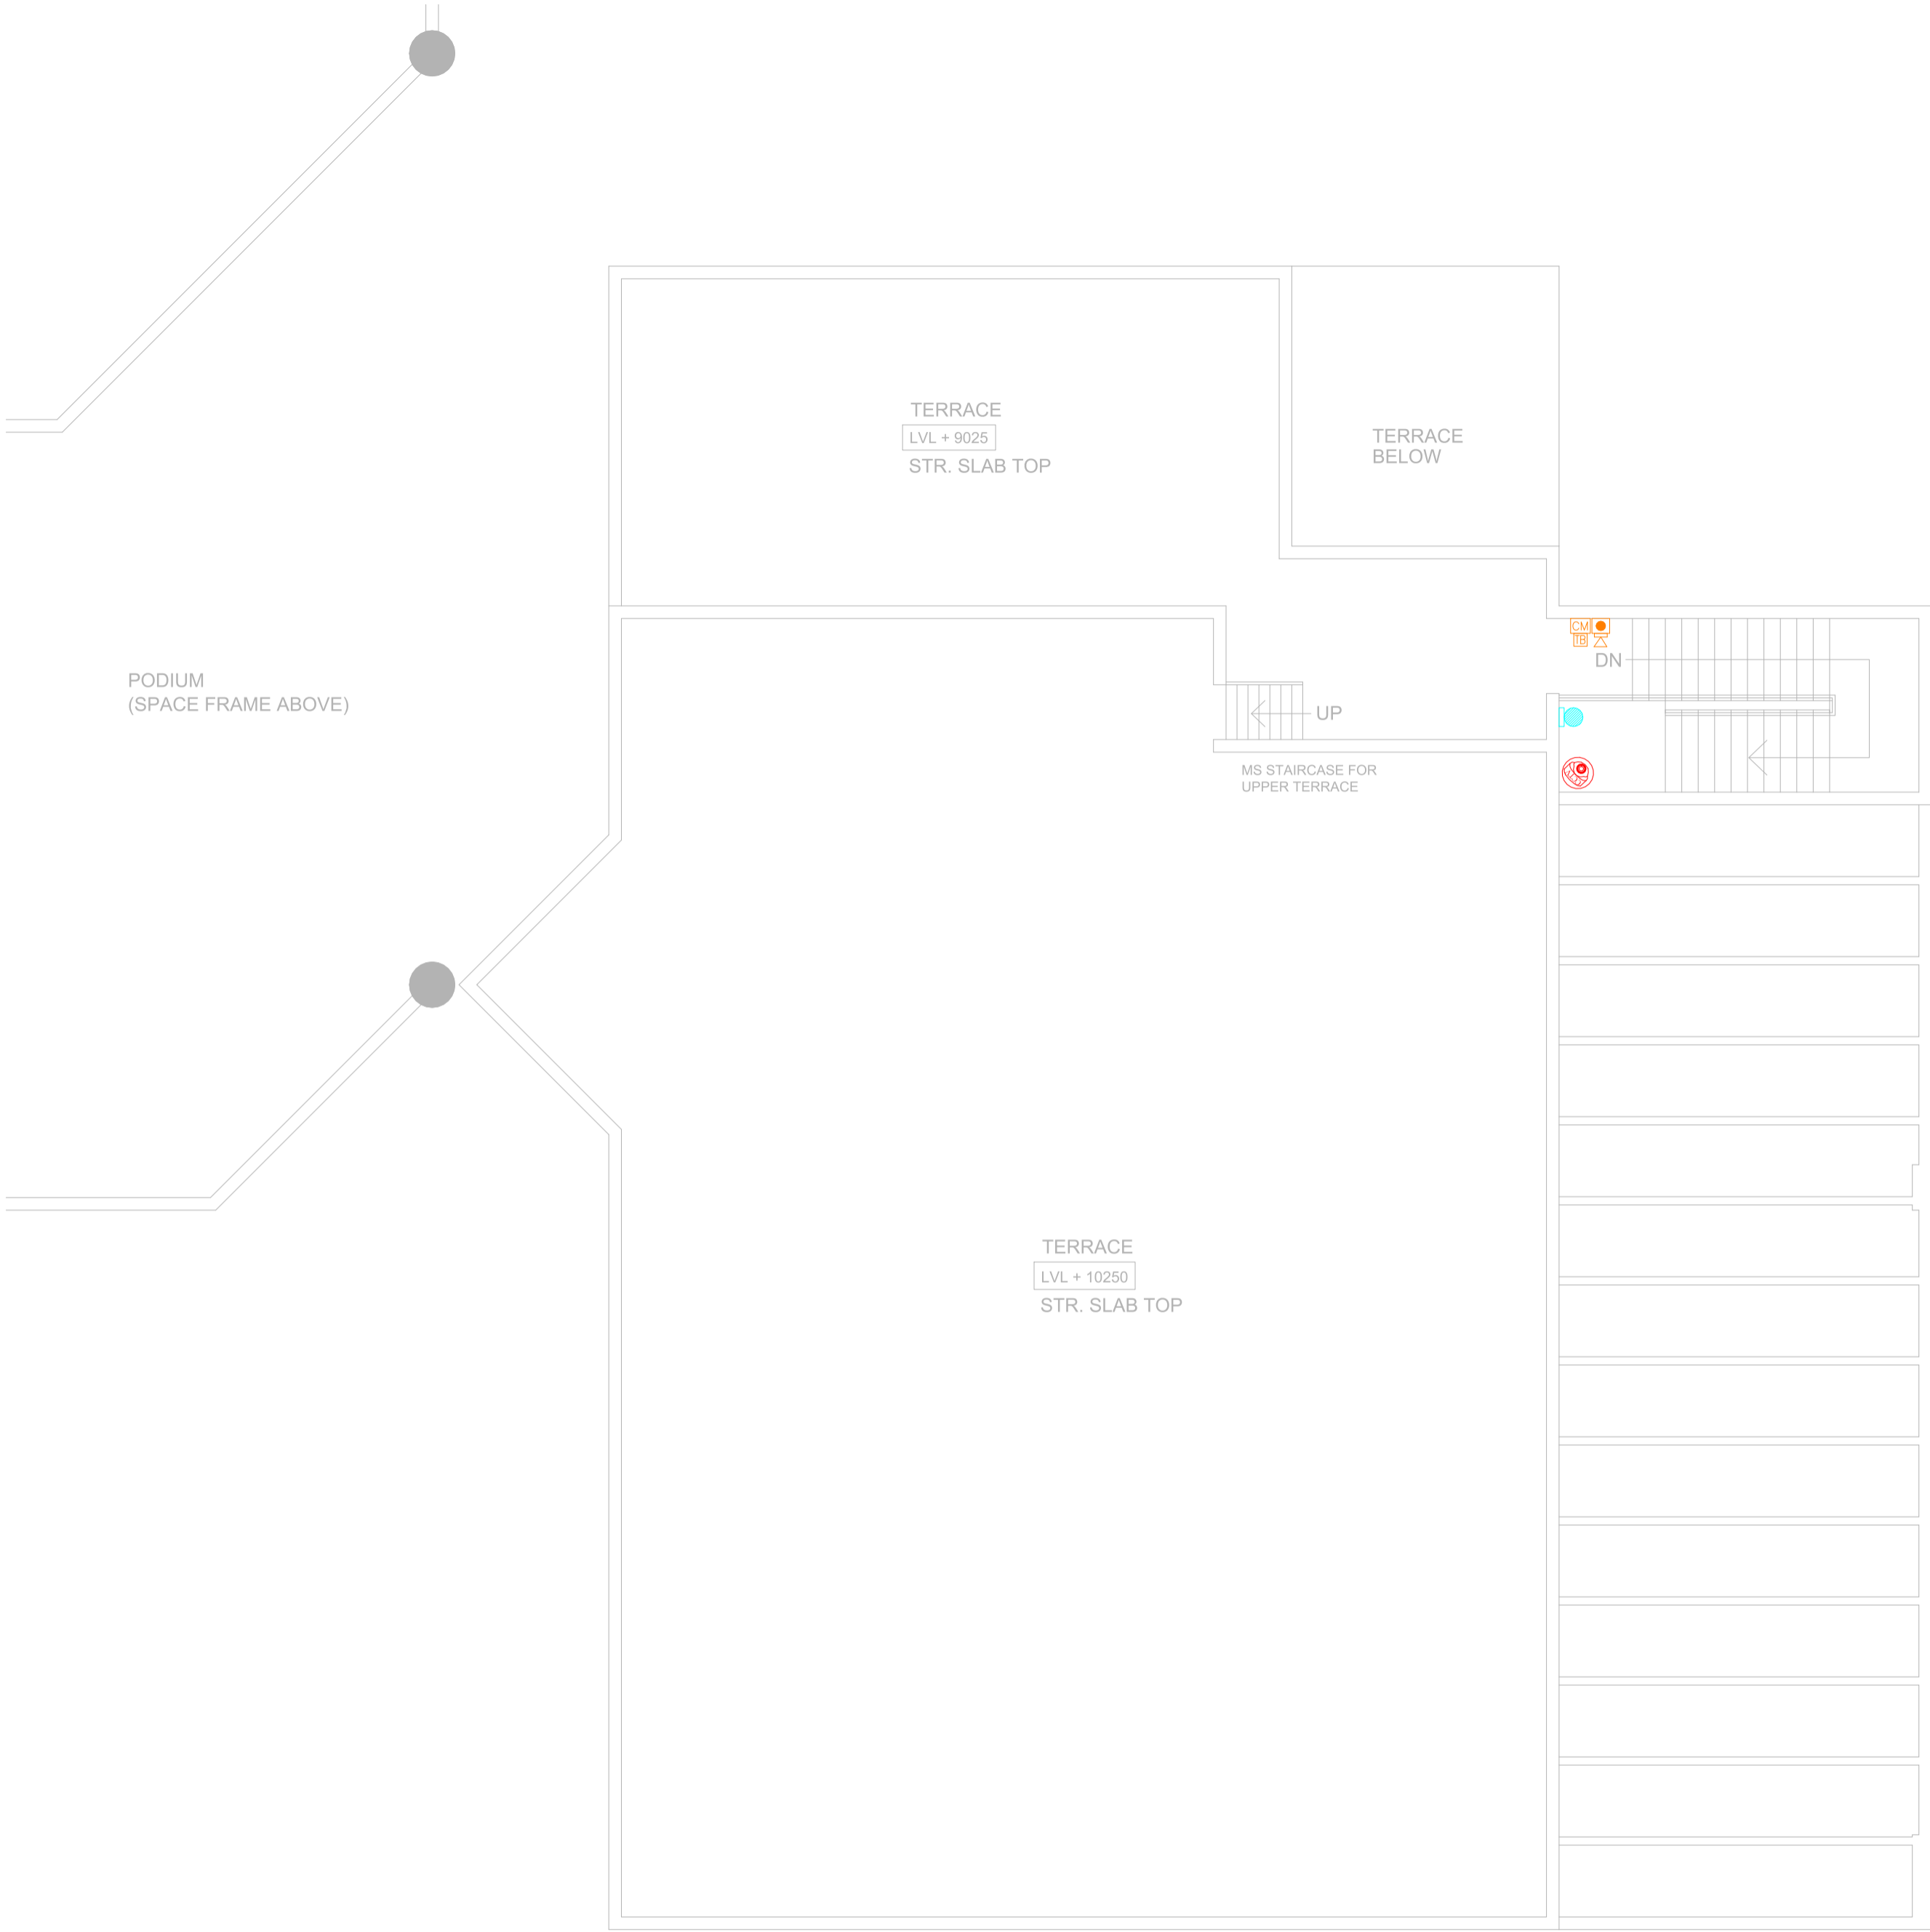




 
ECMS INDIA PVT. LTD.
WP-21 C-282, BASEMENT
NOIDA SECTOR-71,
UTTAR PRADESH-201307
E-mail: ecms.tech01@gmail.com
URL: www.ecmsindia.com
Ph.No. 0120-3502815





DRAWING TITLE-
ELV- FAS, PAS & CCTV LAYOUT (PLAN LEVEL-2)
CONVENTION CENTRE (SITE - 10)-CONFERENCE






FOR APPROVAL	ADVANCE COPY
TENDER DRAWING	GOOD FOR CONSTRUCTION

DRAWN BY	DEEPAK	REV NO.	RD(25.06.2025)
CKD BY	YASHI	SCALE	1:100(A2)
FIN. YEAR	2024-25	JOB NO.	2516
DRAWING NO.	IIM/ECMS/CON./CENTRE/CON./LVL.-2/FAS/PAS/CCTV-03		



S.NO.	LEGENDS TABLE FIRE ALARM SYSTEM	
01.		FIRE ALARM CONTROL PANEL
02.		SMOKE DETECTOR ON FALSE CEILING
03.		SMOKE DETECTOR ON SLAB
04.		HEAT DETECTOR ON SLAB
05.		MANUAL CALL POINT DEVICE
06.		RESPONSE INDICATOR
07.		HOOTER CUM STROBE
08.		CONTROL MODULE DEVICE
09.		MONITOR MODULE DEVICE @FHC's SHAFT
10.		FAULT ISOLATOR DEVICE AS PER LOOP @25D
11.		RELAY MODULE DEVICE
12.		BEAM DETECTOR
13.		BEAM RECEIVER
14.		TALK BACK DEVICE

S.NO.	LEGENDS TABLE CCTV SYSTEM	
01.		NETWORK VIDEO RECORDER AS PER SITE
02.		DOME CAMERA
03.		BULLET CAMERA
04.		PTZ CAMERA

S.NO.	LEGENDS TABLE PUBLIC ADDRESS SYSTEM	
01.		AMPLIFIER UNIT
02.		CEILING MOUNTED SPEAKER
03.		WALL MOUNTED SPEAKER
04.		MICROPHONE
05.		VOLUME CONTROLLER

PROJECT NAME
IIM SHILLONG, UMSAWLI CAMPUS SHILLONG

ARCHITECT
AKSHAYA JAIN & ASSOCIATES
ARCHITECTURE. PLANNING. INTERIOR DESIGN
C-6 / 6098, VASANT KUNJ, NEW DELHI - 110070
TELEPHONES +91-11-26136098, 26132304, 41601615
FAX +91-11-26132304 E-Mail : mail@akshayajain.com

ELECTRICAL SERVICES CONSULTANT
**ECMS INDIA PVT. LTD.**
WP-21 C-282, BASEMENT
NOIDA SECTOR-71,
UTTAR PRADESH-201307
E-mail: ecms.tech01@gmail.com
URL: www.ecmsindia.com
Ph.No. 0120-3502815

DRAWING TITLE-
ELV- FAS, PAS & CCTV LAYOUT (TERRACE)
CONVENTION CENTRE (SITE - 10)-CONFERENCE


<input type="checkbox"/> FOR APPROVAL	<input type="checkbox"/> ADVANCE COPY
<input checked="" type="checkbox"/> TENDER DRAWING	<input type="checkbox"/> GOOD FOR CONSTRUCTION

DRAWN BY DEEPAK REV NO. R0(25.06.2025)


CKD BY YASHI SCALE 1:100(A2)

FIN. YEAR 2024-25 JOB NO. 2516

DRAWING NO. IIM/ECMS/CON./CENTRE/CON./TER./FAS/PAS/CCTV-04

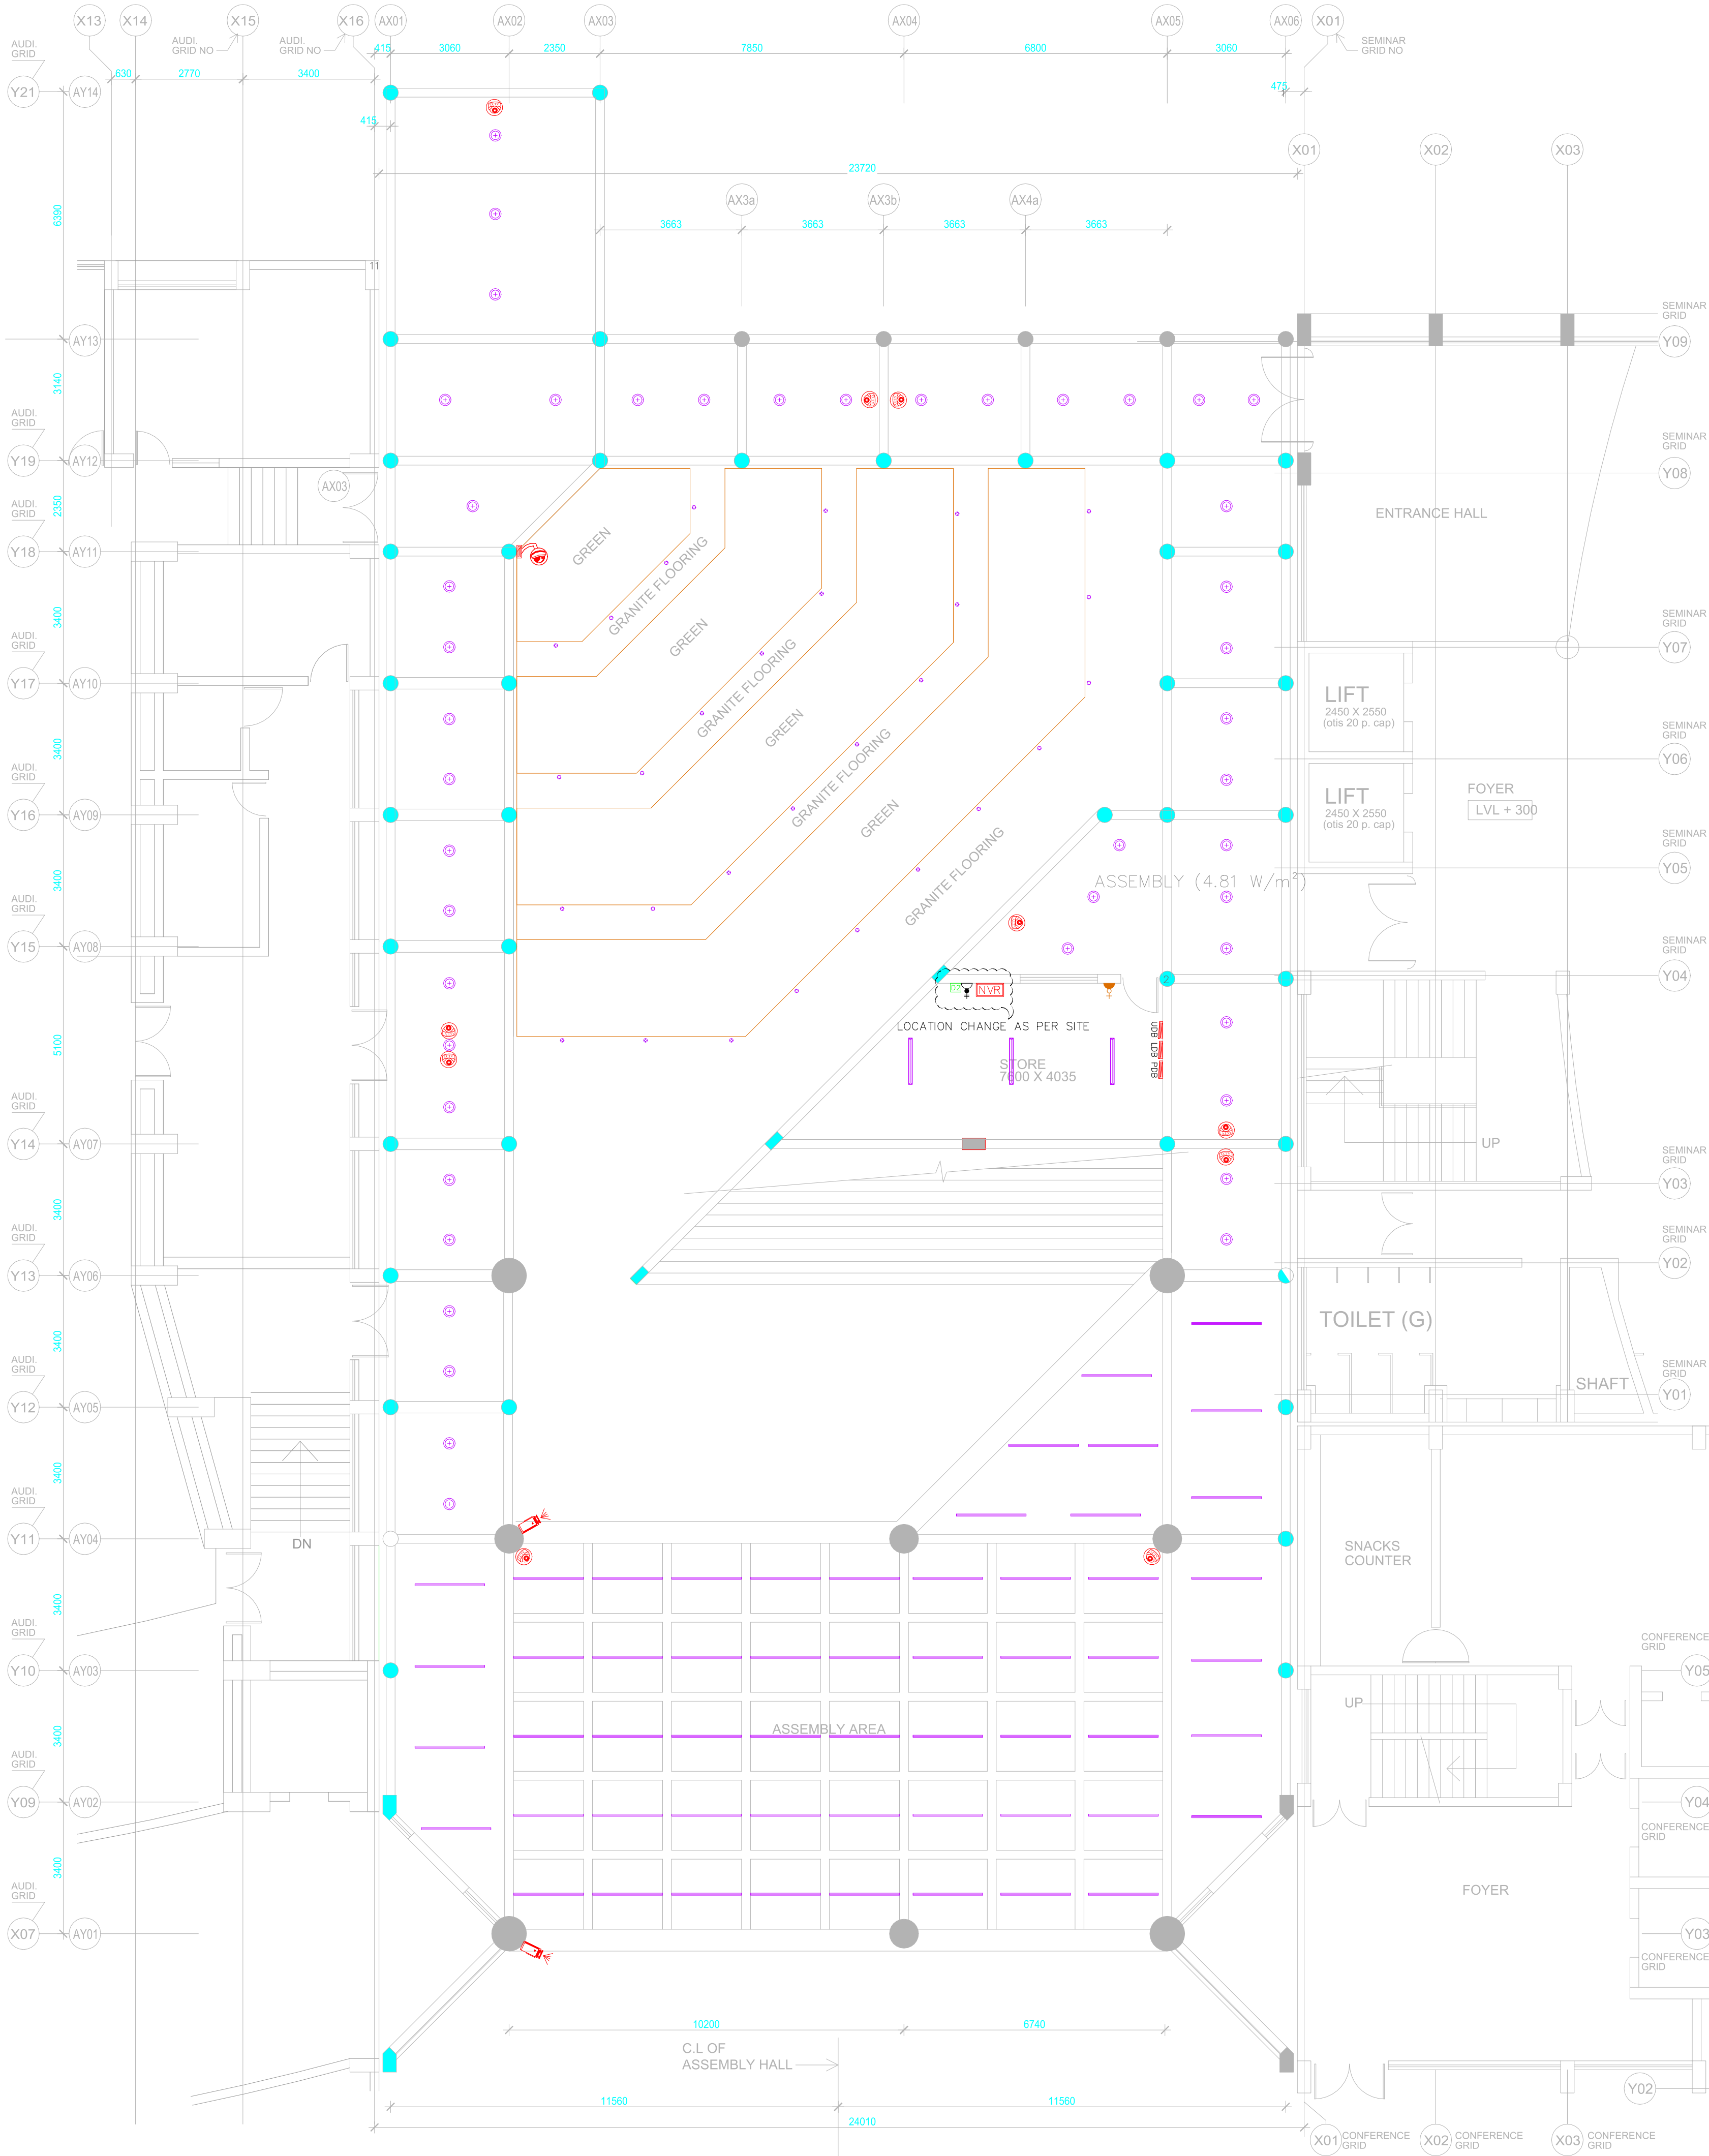

S.NO.	LEGENDS TABLE LIGHTING SYSTEM
01.	GROUND BURIAL LIGHT
02.	18W LED DOWN LIGHTER
03.	30W LED SUSPENDED LINEAR LIGHT-1800MM
04.	20W LED BATTEN LIGHT-1200MM
S.NO.	LEGENDS TABLE
01.	1x6/16A SOCKET & 1x16A SWITCH
02.	2x6A (UPS) SOCKET & 2x6A SWITCH
03.	1 NO. DATA OUTLET
S.NO.	LEGENDS TABLE CCTV SYSTEM
01.	NETWORK VIDEO RECORDER AS PER SITE
02.	DOME CAMERA
03.	BULLET CAMERA
04.	PTZ CAMERA

PROJECT NAME IIM SHILLONG, UMSAWLI CAMPUS SHILLONG	
ARCHITECT AKSHAYA JAIN & ASSOCIATES ARCHITECTURE. PLANNING. INTERIOR DESIGN C-6 / 6098, VASANT KUNJ, NEW DELHI - 110070 TELEPHONES +91-11-26136098, 26132304, 41601615 FAX +91-11-26132304 E-Mail : mail@okshayajain.com	
ELECTRICAL SERVICES CONSULTANT  ECMS INDIA PVT. LTD. WP-21 C-282, BASEMENT NOIDA SECTOR-71, UTTAR PRADESH-201307 E-mail: ecms.tech01@gmail.com URL: www.ecmsindia.com Ph.No. 0120-3502815	
DRAWING TITLE- EL-LIGHTING, POWER & LV LAYOUT (PLAN LEVEL -1) CONVENTION CENTRE (SITE - 10)-ASSEMBLY AREA	
<input type="checkbox"/> FOR APPROVAL	<input type="checkbox"/> ADVANCE COPY
<input checked="" type="checkbox"/> TENDER DRAWING	<input type="checkbox"/> GOOD FOR CONSTRUCTION
DRAWN BY DEEPAK	REV NO. R0(25.06.2025)
CKD BY YASHI	SCALE 1:140(A2)
FIN. YEAR 2024-25	JOB NO. 2516
DRAWING NO.	IIM/ECMS/CON./CENTRE/ASSEMBLY/LVL.-1/EL-01